


nationalgrid

PROPOSED
20-INCH GAS MAIN INSTALLATION
IN
SERVICE ROAD
SANDWICH, MASSACHUSETTS

JUNE 19, 2014

DRAWING INDEX

DRAWING NUMBER	DRAWING TITLE
15-646.01-G-001	COVER SHEET & INDEX
15-646.01-G-002	LEGEND & NOTES
15-646.01-G-003	TRENCH & MECHANICAL DETAILS
15-646.01-G-004	MISCELLANEOUS DETAILS
15-646.01-G-005	TIE-IN DETAILS
15-646.01-TMP-001 - 005	TRAFFIC MANAGEMENT PLANS

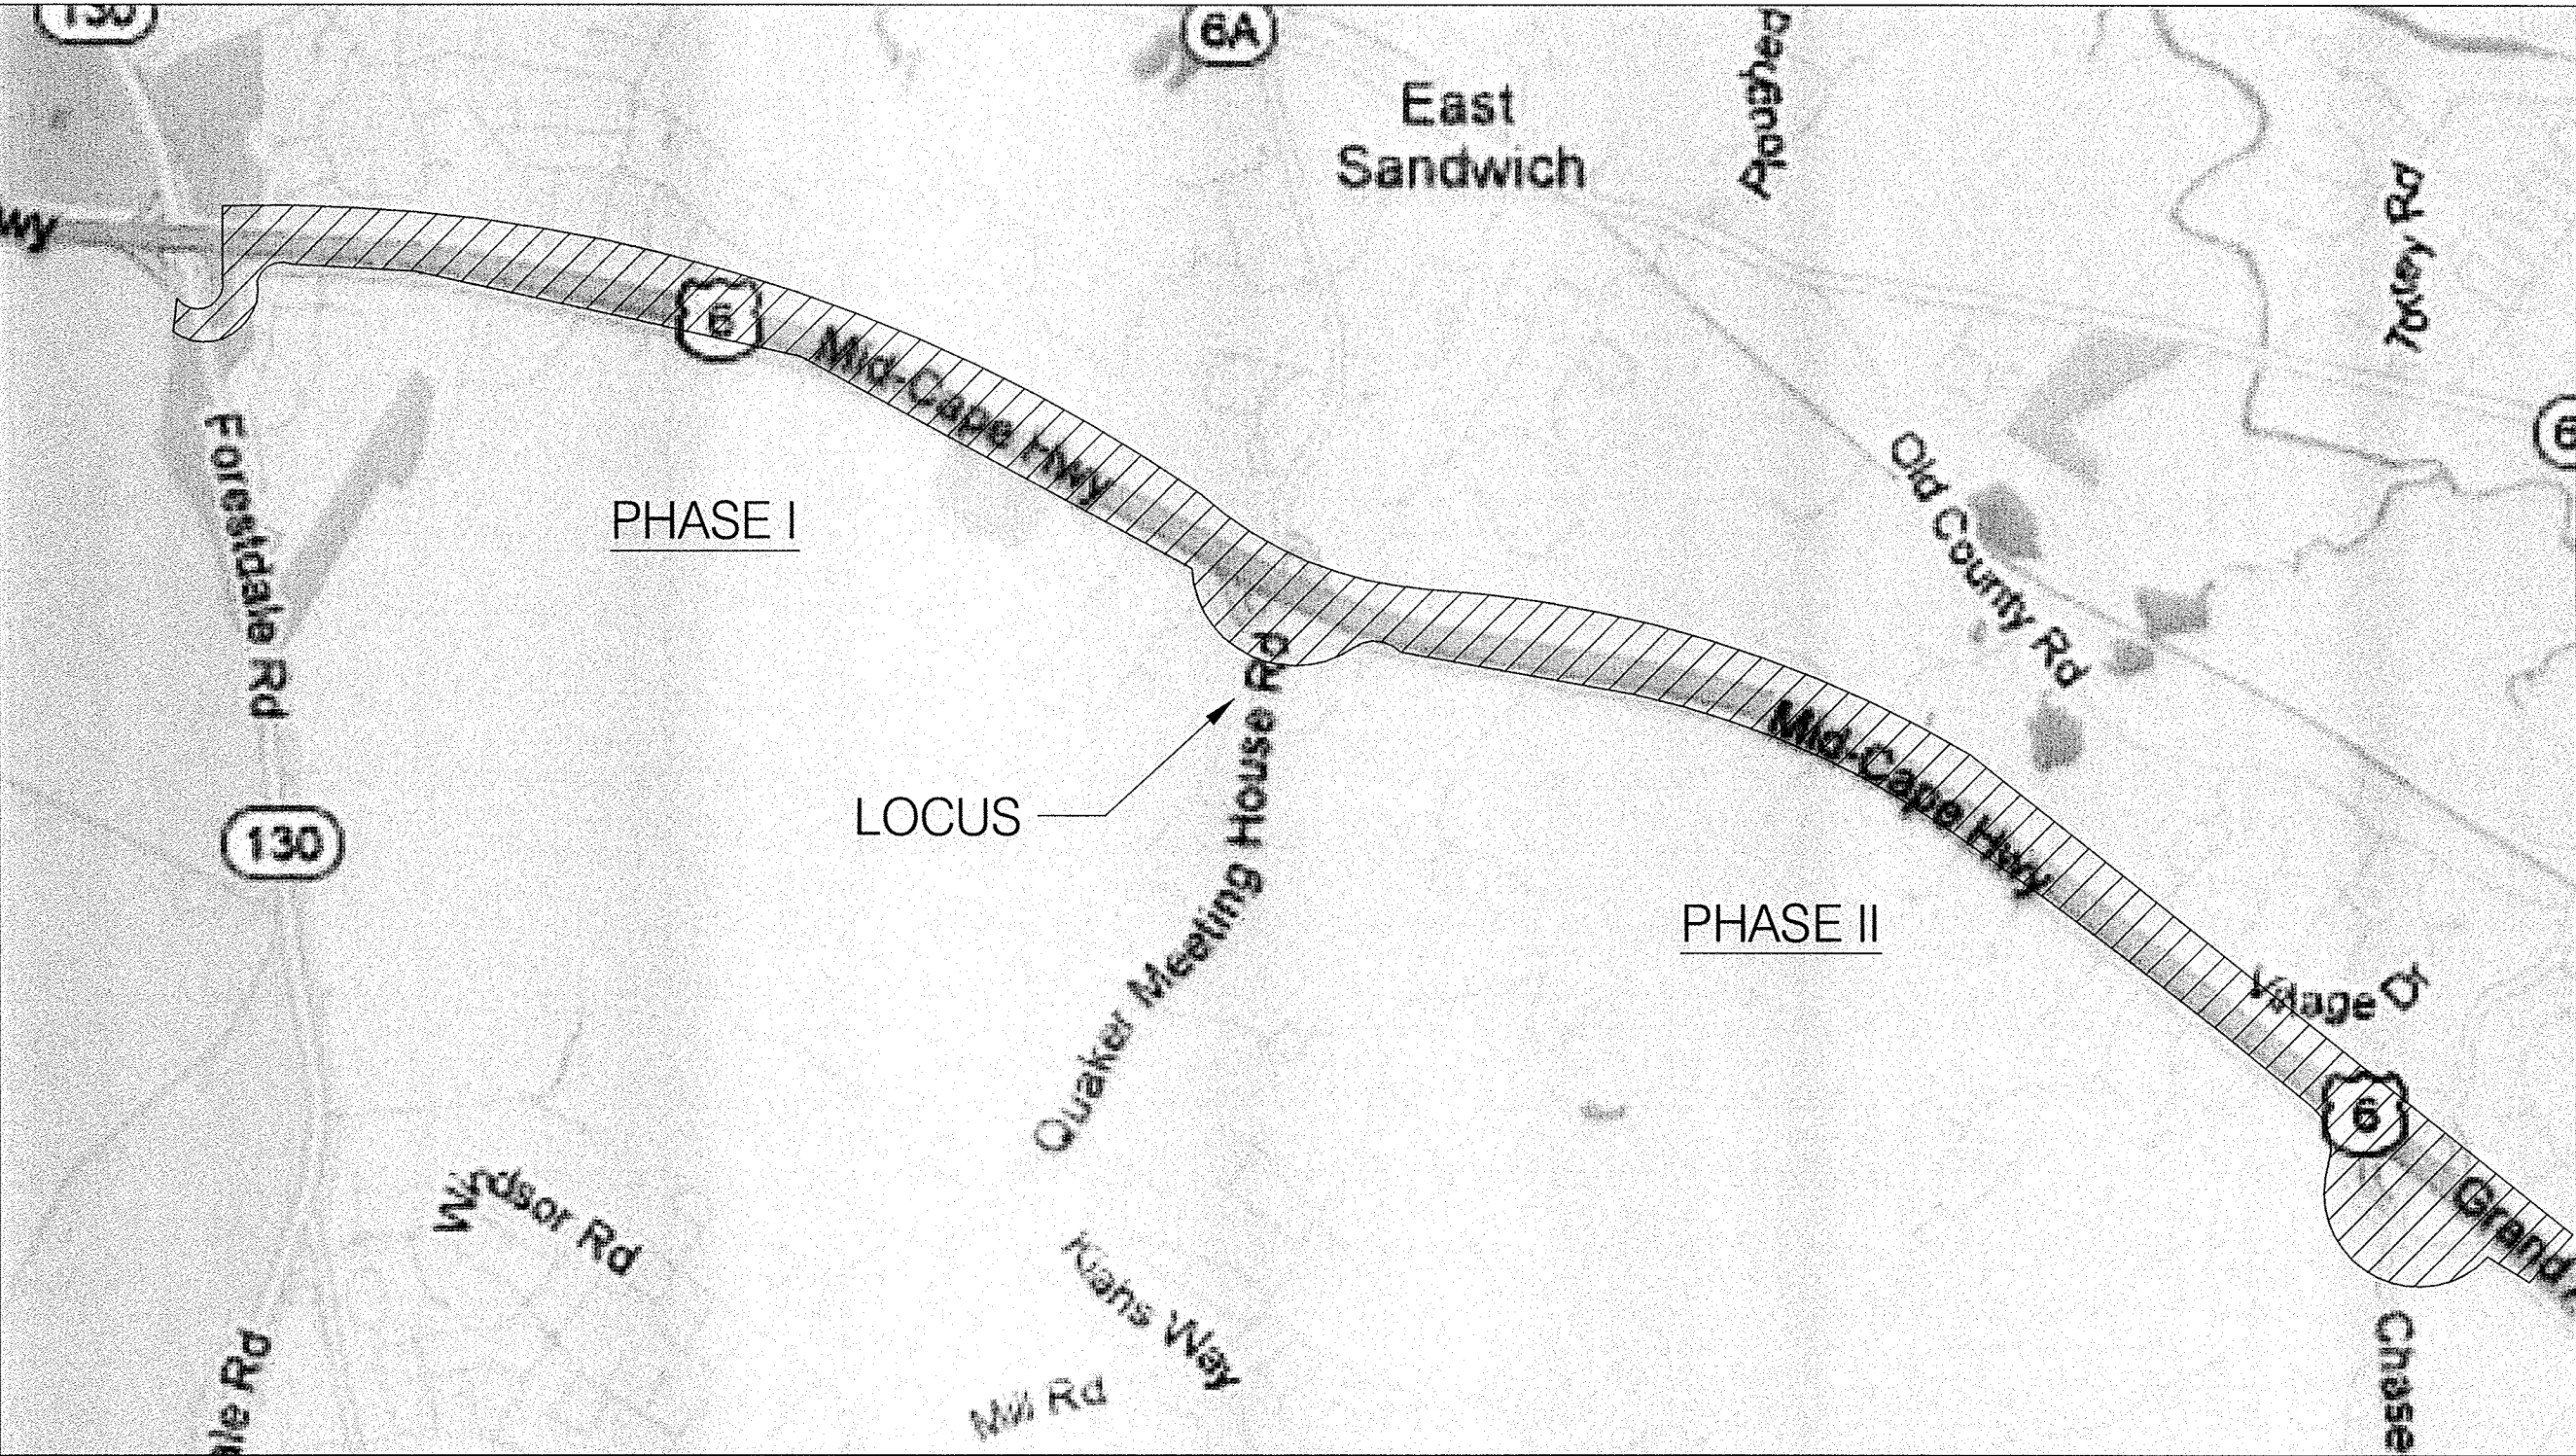

LOCUS PLAN
N.T.S.

PHASE I	
15-646.01-C-001	SERVICE ROAD ALIGNMENT
15-646.01-C-001A	ROAD CROSSING DETAIL
15-646.01-C-002	SERVICE ROAD ALIGNMENT
15-646.01-C-003	SERVICE ROAD ALIGNMENT
15-646.01-C-004	SERVICE ROAD ALIGNMENT
15-646.01-C-005	SERVICE ROAD ALIGNMENT
15-646.01-C-006	SERVICE ROAD ALIGNMENT
15-646.01-C-007	SERVICE ROAD ALIGNMENT
15-646.01-C-008	SERVICE ROAD ALIGNMENT
15-646.01-C-009	SERVICE ROAD ALIGNMENT
15-646.01-C-010	SERVICE ROAD ALIGNMENT
15-646.01-C-011	SERVICE ROAD ALIGNMENT
15-646.01-C-012	SERVICE ROAD ALIGNMENT
15-646.01-C-013	SERVICE ROAD ALIGNMENT
15-646.01-C-014	SERVICE ROAD ALIGNMENT
15-646.01-C-015	SERVICE ROAD ALIGNMENT
15-646.01-C-016	SERVICE ROAD ALIGNMENT
15-646.01-C-017	SERVICE ROAD ALIGNMENT
15-646.01-C-018	SERVICE ROAD ALIGNMENT
15-646.01-C-019	SERVICE ROAD ALIGNMENT
15-646.01-C-019A	ROAD CROSSING DETAIL


PHASE II	
15-646.01-C-020	SERVICE ROAD ALIGNMENT
15-646.01-C-021	SERVICE ROAD ALIGNMENT
15-646.01-C-022	SERVICE ROAD ALIGNMENT
15-646.01-C-023	SERVICE ROAD ALIGNMENT
15-646.01-C-024	SERVICE ROAD ALIGNMENT
15-646.01-C-025	SERVICE ROAD ALIGNMENT
15-646.01-C-026	SERVICE ROAD ALIGNMENT
15-646.01-C-027	SERVICE ROAD ALIGNMENT
15-646.01-C-028	SERVICE ROAD ALIGNMENT
15-646.01-C-029	SERVICE ROAD ALIGNMENT
15-646.01-C-030	SERVICE ROAD ALIGNMENT
15-646.01-C-031	SERVICE ROAD ALIGNMENT
15-646.01-C-032	SERVICE ROAD ALIGNMENT
15-646.01-C-033	SERVICE ROAD ALIGNMENT
15-646.01-C-034	SERVICE ROAD ALIGNMENT
15-646.01-C-035	SERVICE ROAD ALIGNMENT
15-646.01-C-036	SERVICE ROAD ALIGNMENT
15-646.01-C-037	SERVICE ROAD ALIGNMENT
15-646.01-C-038	SERVICE ROAD ALIGNMENT
15-646.01-C-038A	ROAD CROSSING DETAIL

File: W:\NATIONAL GRID\2011 RFP 01\01 SANDWICH\DRAWINGS\15-646.01 ALIGN 1-23_REV 0 (ISSUED FOR FINAL EFSB APPROVAL).DWG
Saved: 6/20/2014 4:20:06 PM Plotted: 6/20/2014 4:23:47 PM User: Wenhua, Kevin Lussow@NGS 4340

REFERENCE DRAWINGS				REVISIONS						
DRAWING NO.	TITLE	DRAWING NO.	TITLE	NO.	DATE	REMARKS	REV.	OKD.	COR.	APP.
				0	6/14	REVISED FOR FINAL EFSB APPROVAL	KDW	SAB	KDW	JEO



Prepared For:
COLONIAL GAS COMPANY
d/b/a
nationalgrid
GAS ENGINEERING DEPARTMENT
4 SYLVAN RD.
WALTON, MA 02451













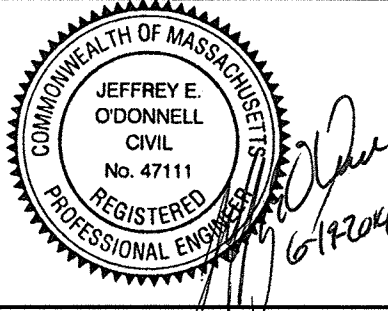


NATIONAL GRID SERVICE COMPANY, USA
COVER SHEET & INDEX
SANDWICH, MA
BARNSTABLE COUNTY, MASSACHUSETTS
File No.: 15-646.01 ALIGN.dwg



APPROVED BY
DATE: SEPTEMBER 7, 2012
MANAGER
NATIONAL GRID SERVICE COMPANY, USA
15-646.01-G-001

TOWN OF SANDWICH
BARNSTABLE COUNTY, MASSACHUSETTS

             LEGEND

PROPOSED GAS LINE	
PROPERTY LINE	
EASEMENT LINE	
EDGE OF PAVEMENT	
RAILROAD	
LIMIT OF WORK	
CONTOUR	
FENCE	
EXISTING GUARDRAIL	
PROPOSED GUARDRAIL	
OVERHEAD WIRES	
DRAIN LINE	
SEWER LINE	
WATER LINE	
GAS LINE	
ELECTRICAL LINE	
TELEPHONE LINE	
CONCRETE BOUND	
IRON PIN	
UTILITY MANHOLE	
UTILITY HANDHOLE	
CATCH BASIN	
UTILITY POLE	
LIGHT POST	
GUY ANCHOR	
WATER GATE	
GAS GATE	
HYDRANT	
MAIL BOX	
TRAFFIC SIGNAL	
GATE POST / BOLLARD	
TREE	
EXISTING STRUCTURE	
PROPOSED GAS VALVE	
SPOT GRADE	
PARKING METER	
CALL BOX	

  ABBREVIATIONS

ABD.	ABANDON
APPROX.	APPROXIMATE
BND.	BOUND
BIT. CONC.	BITUMINOUS CONCRETE
	BASELINE
BLDG.	BUILDING
B.O.	BY OTHERS
B.W.	BOTTOM OF WALL
BWLL	BROKEN WHITE LANE LINE
CTB	CATCH BASIN
C.B.C.I.	CATCH BASIN WITH CURB INLET
CEM.	CEMENT
C.I.	CURB INLET
	CENTERLINE
	CENTERLINE OF CONSTRUCTION
CLDI	CEMENT LINED DUCTILE IRON PIPE
CONC.	CONCRETE
CONST.	CONSTRUCT(ION)
D	DRAIN
DMH	DRAINAGE MANHOLE
DWY	DRIVEWAY
DYCL	DOUBLE YELLOW CENTERLINE
E	ELECTRIC
ELEV. (OR EL)	ELEVATION
EOP	EDGE OF PAVEMENT
EXIST. (OR EX.)	EXISTING
GG	GAS GATE
GRAN.	GRANITE
GRV	GRAVEL
HDPE	HIGH DENSITY POLYETHYLENE PIPE
HMA	HOT MIX ASPHALT
HOR.	HORIZONTAL
HYD.	HYDRANT
L	LENGTH OF CURVE/LEFT
L.P.	LIGHT POLE
MB	MAIL BOX
MH	MANHOLE
MHD	MASS HIGHWAY BOUND
NTS	NOT TO SCALE
PAVT.	PAVEMENT
P.C.	POINT OF CURVATURE
P.C.C.	POINT OF COMPOUND CURVATURE
PGL	PROFILE GRADE LINE
P.I.	POINT OF INTERSECTION
PM	PARKING METER
P.R.C.	POINT OF REVERSE CURVATURE
PROP.	PROPOSED
P.T.	POINT OF TANGENCY
R	RADIUS OF CURVATURE/RIGHT
RCP	REINFORCED CONCRETE PIPE
RD.	ROAD
REM.	REMOVE
RET.	RETAIN
RET. WALL	RETAINING WALL
RMDL	REMODEL
R.O.W.	RIGHT-OF-WAY
R&R	REMOVE AND RESET
R&S	REMOVE AND STACK
S.B.	STONE BOUND
SMH	SEWER MANHOLE
ST.	STREET
STA.	STATION
S.W.	SIDEWALK
SWEL	SOLID WHITE EDGE LINE
SWLL	SOLID WHITE LANE LINE
SYCL	SINGLE YELLOW CENTERLINE
T	TANGENT/TRUCK PERCENTAGE
TAN.	TANGENT DISTANCE OF CURVE
TEMP.	TEMPORARY
TMH	TELEPHONE MANHOLE
TS	TEST STATION
TSP	TRAFFIC SIGNAL POLE
T.W.	TOP OF WALL
TYP.	TYPICAL
UTP	UTILITY POLE
VERT.	VERTICAL
WV	WATER VALVE
W.M.	WATER METER/WATER MAIN
WSO	WATER SHUT OFF
GSO	GAS SHUT OFF
ADJ.	ADJUST
L.F.	LINEAR FEET
MP	MARKER POST

GENERAL NOTES

1. SITE DETAIL SHOWN HEREON IS BASED UPON TOPOGRAPHIC DETAIL SURVEY CONDUCTED BY COLER & COLANTONIO, INC. IN JULY 2011 AND DETAIL SURVEY PROVIDED BY BSC.
2. THE SERVICE ROAD RIGHTS-OF-WAY SHOWN HEREON ARE BASED ON MASSACHUSETTS DEPARTMENT OF TRANSPORTATION RECORD PLANS AND DO NOT REPRESENT A PROPERTY LINE RETRACEMENT SURVEY EFFORT.
3. LOCATION OF ANY IDENTIFIED UNDERGROUND UTILITIES IS APPROXIMATE ONLY, AND IS NOT WARRANTED TO BE CORRECT. ADDITIONAL UTILITIES MAY EXIST WHICH ARE NOT INDICATED ON THESE PLANS. ALL EXISTING UTILITIES SHALL BE VERIFIED BY THE CONTRACTOR FOR SERVICE, SIZE, INVERT ELEVATIONS, LOCATION, ETC. CONTRACTOR MUST NOTIFY DIG-SAFE MASSACHUSETTS 1-888-344-7233 AT LEAST 72 HOURS PRIOR TO ANY CONSTRUCTION.
4. THE PLAN SET IS REFERENCED TO THE MASSACHUSETTS MAINLAND ZONE 2003, NAD83 HORIZONTAL COORDINATE SYSTEM. ELEVATIONS ARE BASED ON NGVD 1988, US SURVEY FEET AND REFERENCED TO TEMPORARY BENCHMARKS AS SHOWN ON THE PLAN.
5. THE LOCUS LIES IN FIRM ZONE "X", DESCRIBED ON COMMUNITY PANEL NUMBERS, PREPARED BY F.E.M.A.: 2500120005D & 2500120006D, REVISED AUGUST 5, 1991, AND 2500120003G & 2500120002F, REVISED JULY 2, 1992.
6. THE PURPOSE OF THIS PLAN SET IS TO IDENTIFY TO THE APPROPRIATE PERMITTING AGENCY THE PROPOSED LOCATION FOR A GAS PIPELINE AND ITS LOCATION RELATIVE TO EXISTING UTILITIES WITHIN THE LIMITS OF A ROAD RIGHT-OF-WAY, INCLUDING ELEVATION INFORMATION WHERE OBTAINABLE.

REFERENCE DRAWINGS


1. PLAN ENTITLED "SANDWICH ~ 1949 LAYOUT ~ 26 SHEETS", SCALE 1"=40'.
2. PLAN ENTITLED "PROPERTY OF NEW ENGLAND TELEPHONE & TELEGRAPH" LOCATION: SANDWICH, EXCHANGE: SAGAMORE, EXCHANGE CODE: 5363
3. PLAN ENTITLED "WATER SYSTEM MAP, SANDWICH, MASSACHUSETTS" PREPARED BY EARTH TECH, DATED JANUARY 2007, SCALE 1"=225'
4. PLAN ENTITLED "PROPOSED NEW 20" STEEL GAS MAIN, WESTERN SEGMENT PHASE 1, SERVICE ROAD, (BETWEEN ROUTE 130 & QUAKER MEETING HOUSE ROAD) IN SANDWICH, MASSACHUSETTS" PREPARED BY BSC GROUP, DATED 09/16/2000, SCALE 1"=40'.
5. COMCAST, MAP NO. 251-587, 252-586 TO 252-587, 253-585 TO 253-586, AND 254-584 TO 254-585 COVERING SERVICE ROAD FROM QUAKER MEETING HOUSE ROAD TO BOXWOOD LANE, SANDICH, MASS, SCALE 1"=100'.

BILL OF MATERIAL				
SUPPLIER	ITEM	DESCRIPTION	SIZE	QTY
NATIONAL GRID	1	PIPE, CARBON STEEL, 20 IN. SCH 40, 0.375 IN WALL, X-52 API-5L PSL2	20"	23,016 ft. ±
NATIONALGRID	2	CASING PIPE, WRAPPED STEEL, 24 IN. SCH 40, 0.500 IN WALL	24"	301 ft. ±
NATIONALGRID	3	ELBOW, WELD, 22.5 DEGREE, 3DIA RADIUS, 20 IN IPS, STEEL, STD. WALL 0.375IN, X-52 API-5L PSL2 *	20"	67
NATIONALGRID	4	ELBOW, WELD, 45 DEGREE, 3DIA RADIUS, 20 IN IPS, STEEL, STD. WALL 0.375IN, X-52 API-5L PSL2 *	20"	21
NATIONALGRID	5	ELBOW, WELD, 90 DEGREE, 3DIA RADIUS, 20 IN IPS, STEEL, STD. WALL 0.375IN, X-52 API-5L PSL2 *	20"	1
NATIONALGRID	6	TEE, BARRED, STEEL, 20 IN. x 20 IN. x 20 IN.	20"	2
NATIONALGRID	8	REDUCER, CARBON STEEL, 20 IN. x 12 IN.	20" x 12"	2
NATIONALGRID	9	TDW, SPHERICAL 3-WAY TEE	12"	2
NATIONALGRID	10	VENT PIPE, STEEL	2"	136' ±

NATIONALGRID	13	FLANGE, 20", CLASS 300LB, ASTM A105, 19.25 BORE, RFWN	20"	2
NATIONALGRID	14	FLANGE, 20", CLASS 300LB BLIND, ASTM A105, RF	20"	2
NATIONALGRID	15	GASKET, 22 3/4" OD, SOFT CUT, COMPRESSED FIBER, 0.125 THICK FOR 20" CLASS 300LB FLANGE	20"	2
NATIONALGRID	16	STUD BOLT FOR 20" CLASS 300LB FLANGE	1-1/8"	40
NATIONALGRID	17	PIPE, CARBON STEEL, 12 IN., SCH 40, 0.375 IN WALL, X-52 API-5L PSL2	12"	50 ft. ±
NATIONALGRID	19	20" CLASS 300LB INSULATING JOINT, WELD END	20"	1
NATIONALGRID	20	12" CLASS 300LB INSULATING JOINT, WELD END	12"	2
NATIONALGRID	21	CASING DETAILS	---	3
NATIONALGRID	22	12" FILTER SOCK WITH STAKES (PHASE I ONLY) **	12"	5,500 ft. ±
NATIONALGRID	23	SILT SACK (CATCH BASIN CONTROL, PHASE I ONLY)	---	18
NATIONALGRID	24	FILTER SOCK (DRAINAGE SWALE CONTROL, PHASE I ONLY)	---	11

* ADDITIONAL ELBOWS MAY BE REQUIRED DEPENDING ON FIELD CONDITIONS. CONTRACTOR TO DETERMINE IF 45° OR 90° ELBOWS WILL BE USED AT TIME OF CONSTRUCTION.


** LOCATION OF FILTER SOCK INSULATION TO BE DETERMINED BY ENVIRONMENTAL ENGINEER AT CONSTRUCTION.

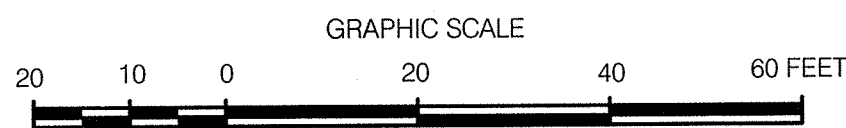

REFERENCE DRAWINGS				REVISIONS							
DRAWING NO.	TITLE	DRAWING NO.	TITLE	NO.	DATE	REMARKS	REV.	OKD.	COR.	APP.	
				0	6/14	REVISED FOR FINAL EFSB APPROVAL	KDW	SAB	KDW	JEO	




Prepared For:
COLONIAL GAS COMPANY
d/b/a
nationalgrid
GAS ENGINEERING DEPARTMENT
40 SYLVAN RD.
WALTHAM, MA 02451

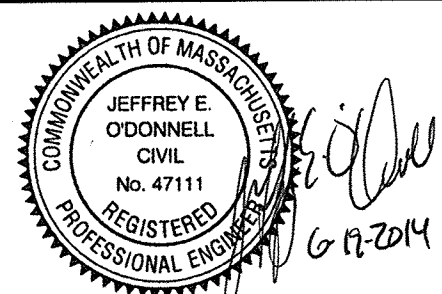


NATIONAL GRID SERVICE COMPANY, USA
LEGEND & NOTES
SANDWICH, MA
BARNSTABLE COUNTY, MASSACHUSETTS
File No.: 15-646.01 ALIGN.dwg


APPROVED BY
DATE: SEPTEMBER 7, 2012
MANAGER
NATIONAL GRID SERVICE COMPANY, USA
15-646.01-G-002

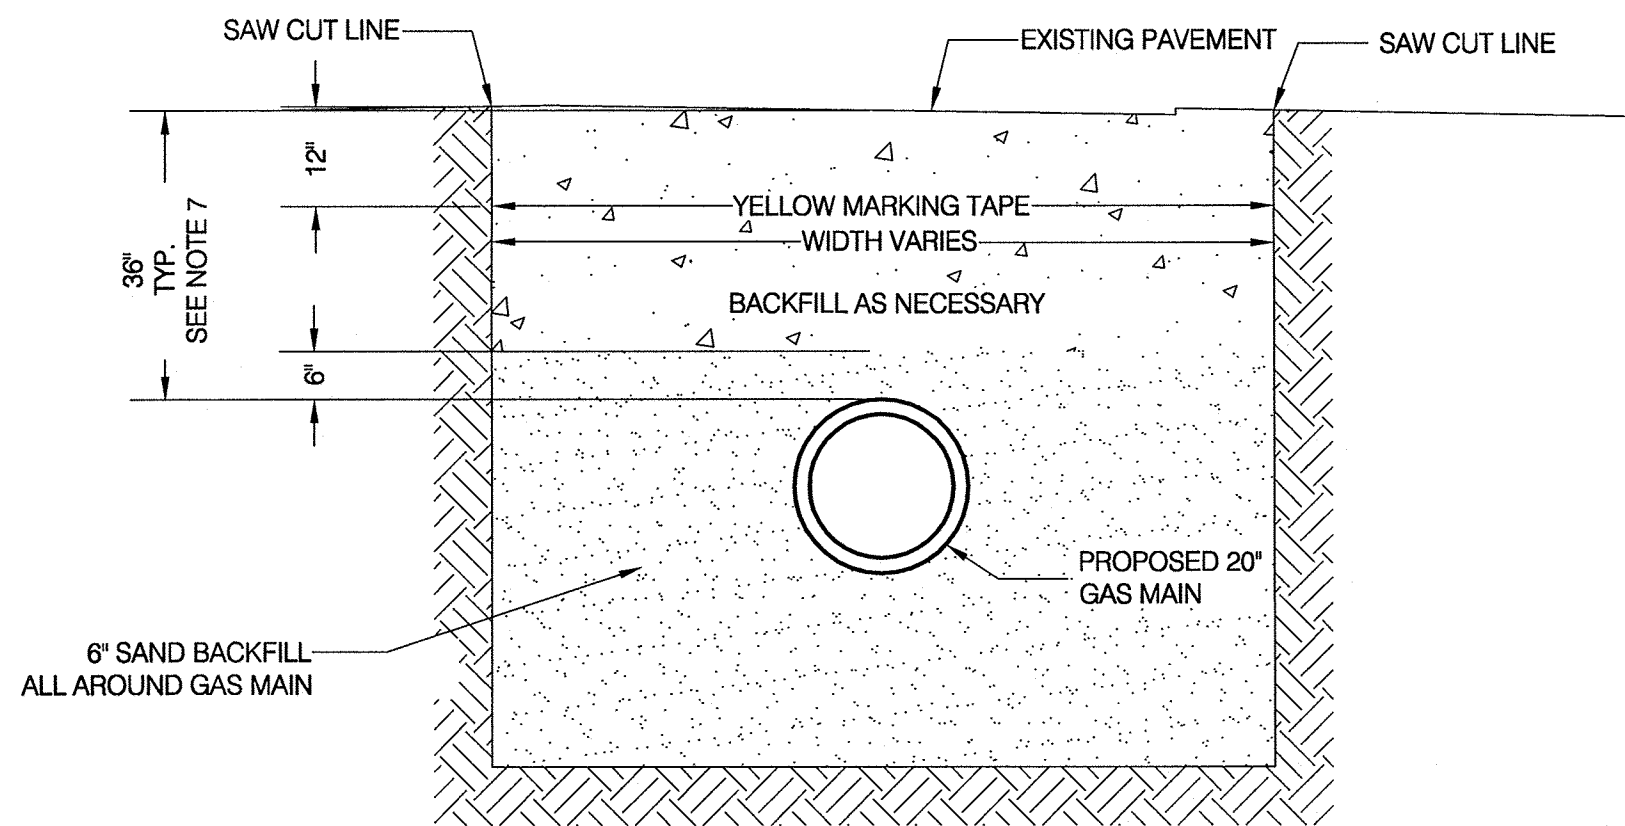

DETAIL
SCALE N.T.S. 1
TRENCH DETAIL

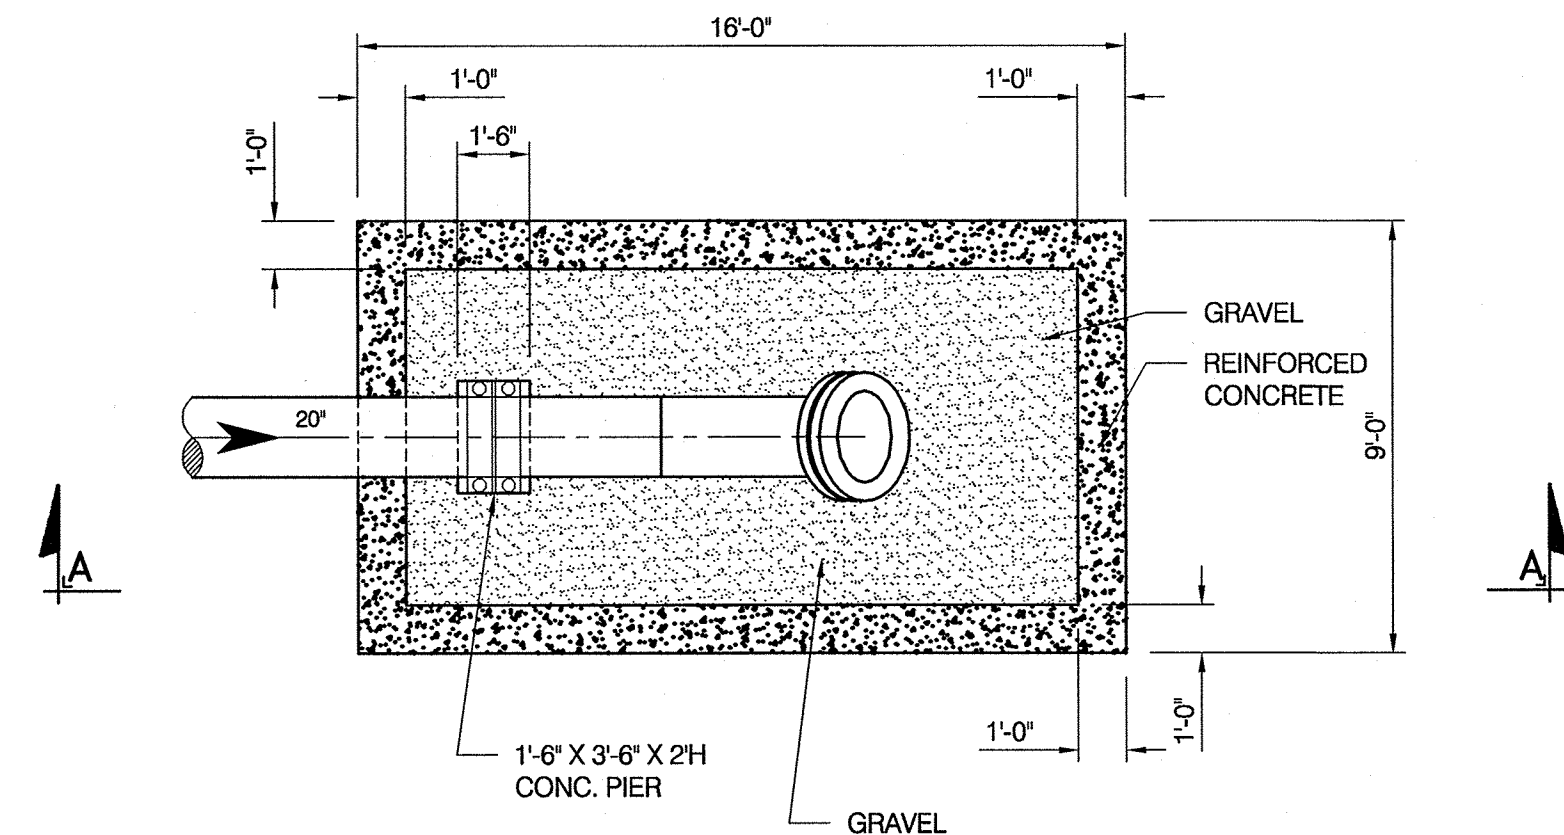

PLAN VIEW

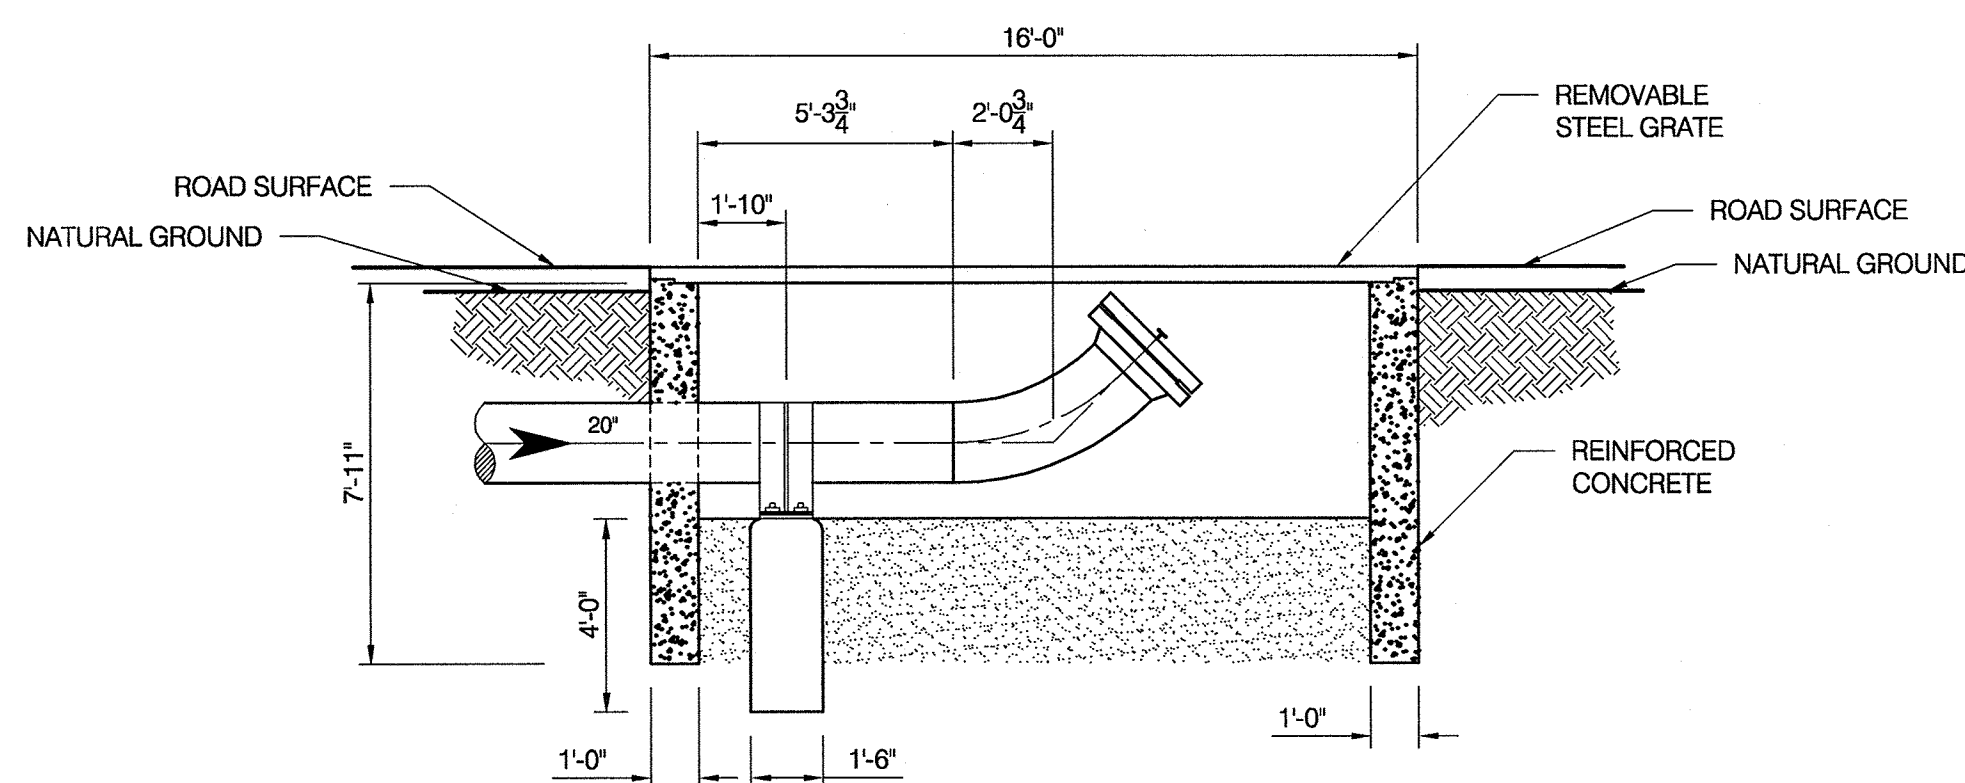


SECTION VIEW - A-A

DETAIL
SCALE 1/4"=1'-0" 3
20" BLOWDOWN DETAIL
NEAR STATION 112+00 & 227+00

NOTES:

1. ALL TRENCH CONSTRUCTION TO CONFORM TO APPLICABLE FEDERAL, STATE AND LOCAL REGULATIONS.
2. BACKFILL MATERIAL WILL CONSIST OF SUITABLE EXCAVATED MATERIAL COMPACTED.
3. CLEAN SAND SHALL BE USED TO BED AND COVER THE PROPOSED PIPES.
4. ALL BACKFILL MATERIAL SHALL BE COMPACTED AT NEAR OPTIMUM MOISTURE CONTENT IN LAYERS NOT EXCEEDING 6 INCHES IN COMPACTED THICKNESS BY PNEUMATIC TAMPERS, VIBRATOR COMPACTORS, OR OTHER APPROVED MEANS TO THE BASE OF THE MATERIAL SHALL BE COMPACTED TO NOT LESS THAN 95 PERCENT OF AASHTO T 99 METHOD C.
5. THE CONTRACTOR SHALL PROVIDE TESTING TO INSURE THAT THE INPLACE DENSITY OF THE BACKFILL MEETS THE ABOVE REQUIREMENTS.
6. PROPOSED PIPE(S) SHALL MAINTAIN A MINIMUM 6" VERTICAL SEPARATION ABOVE / BELOW EXISTING UNDERGROUND UTILITIES / STRUCTURES.
7. THE MINIMUM DEPTH OF BURIAL SHALL BE 36" FOR THE PROPOSED PIPE(S). THE MINIMUM DEPTH OF BURIAL MAY BE REDUCED TO 30" SHOULD EXISTING UNDERGROUND UTILITIES / STRUCTURES BE PRESENT.
8. MWRA PIPE(S) WILL BE EXPOSED TO CONFIRM DEPTH OF COVERAGE PRIOR TO THE INSTALLATION OF THE PROPOSED GAS MAIN.




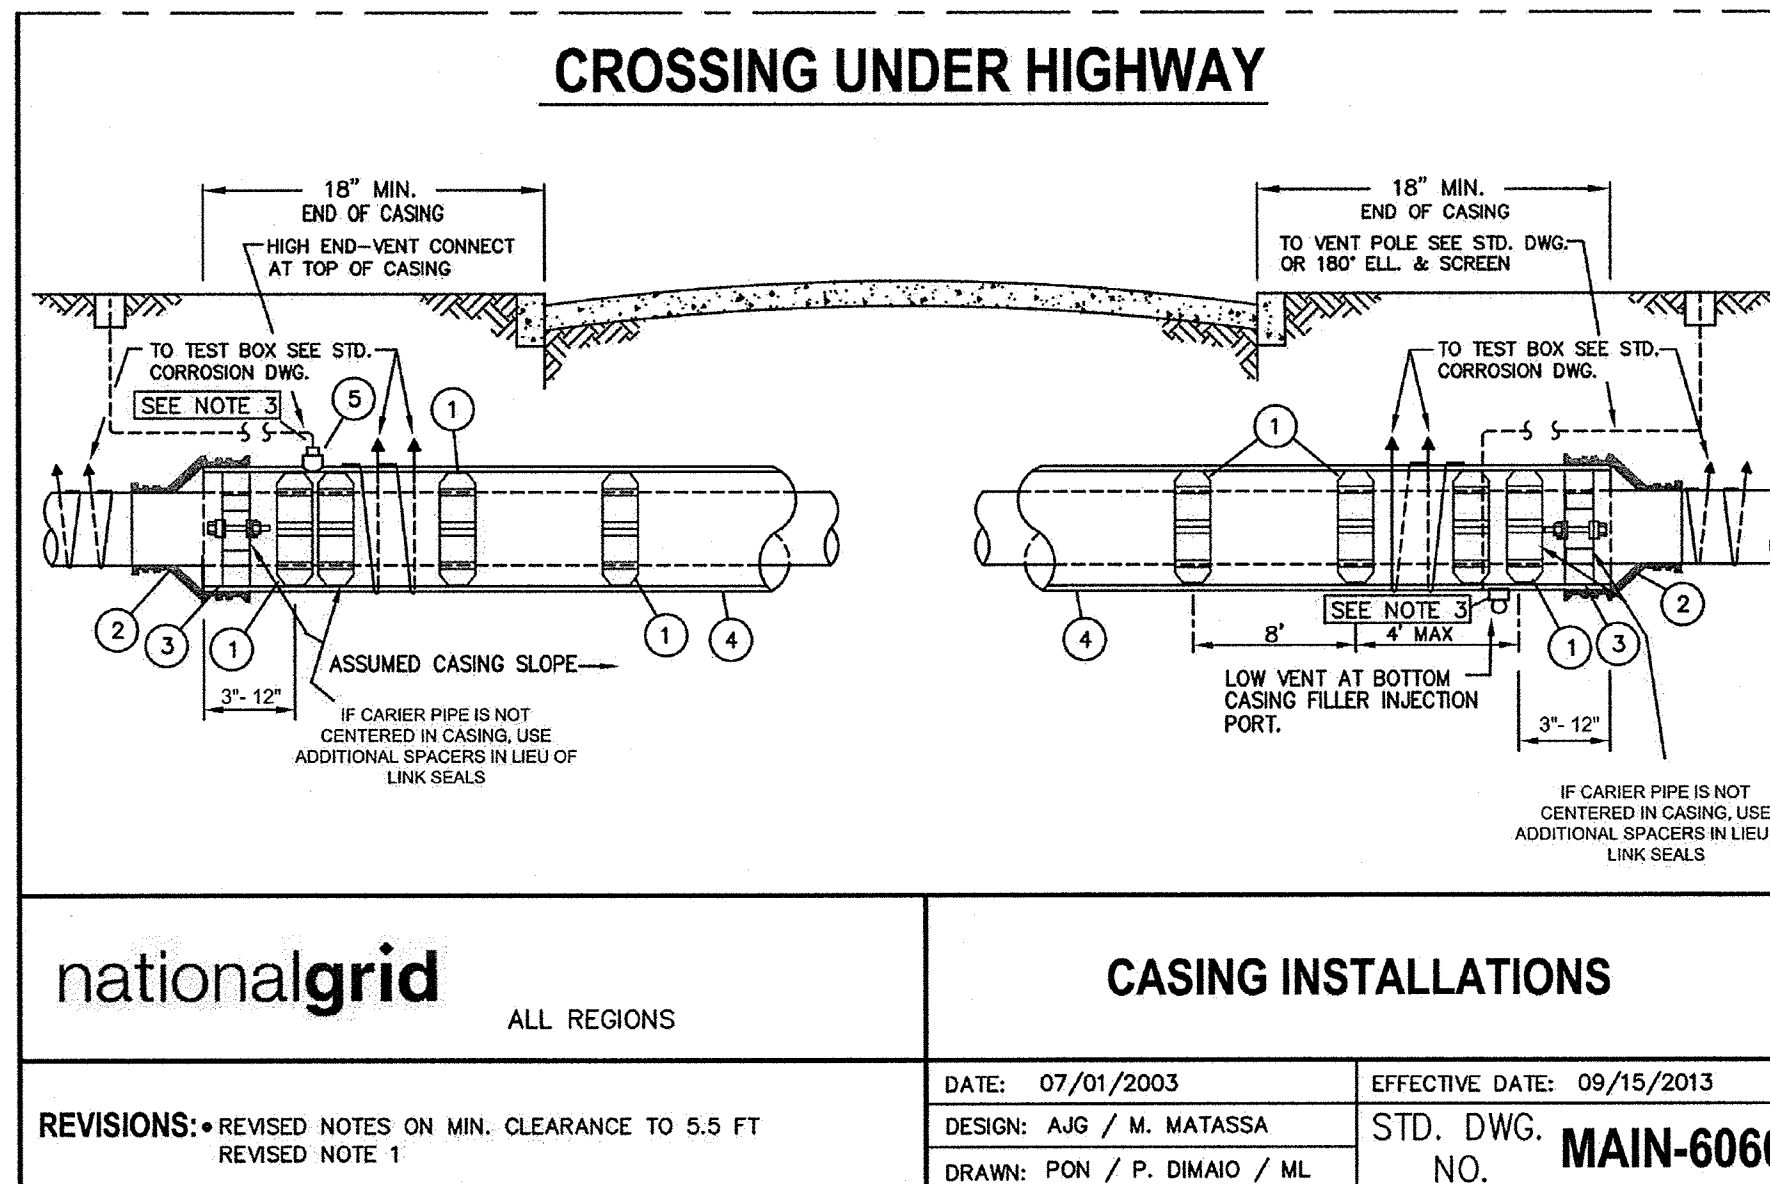


UNCONTROLLED WHEN PRINTED 1 OF 6 © National Grid Gas plc 2013 - All Rights Reserved

BILL OF MATERIAL				
SUPPLIER	ITEM	DESCRIPTION	SIZE	QTY
NATIONAL GRID	1	INSULATING SPACER #9341031	20"-24"	50 ±
NATIONALGRID	2	END SEAL #9342440	20"-24"	6
NATIONALGRID	3	LINK, SEAL, ASSY. MODEL LS-400-C #9339728	20"-24"	8
NATIONALGRID	4	CASING WRAPPED STEEL #9340800	24"	301' ±
NATIONALGRID	5	THREAD-O-LET #9342054	2"	6

DETAIL
SCALE N.T.S. 4
CASING DETAILS
(ITEM NO. 21)

REFERENCE DRAWINGS				REVISIONS					
DRAWING NO.	TITLE	DRAWING NO.	TITLE	NO.	DATE	REMARKS	REV.	CKD.	COR. APP.
				0	6/14	REVISED FOR FINAL EFSB APPROVAL	KDW	SAB	KDW JEO

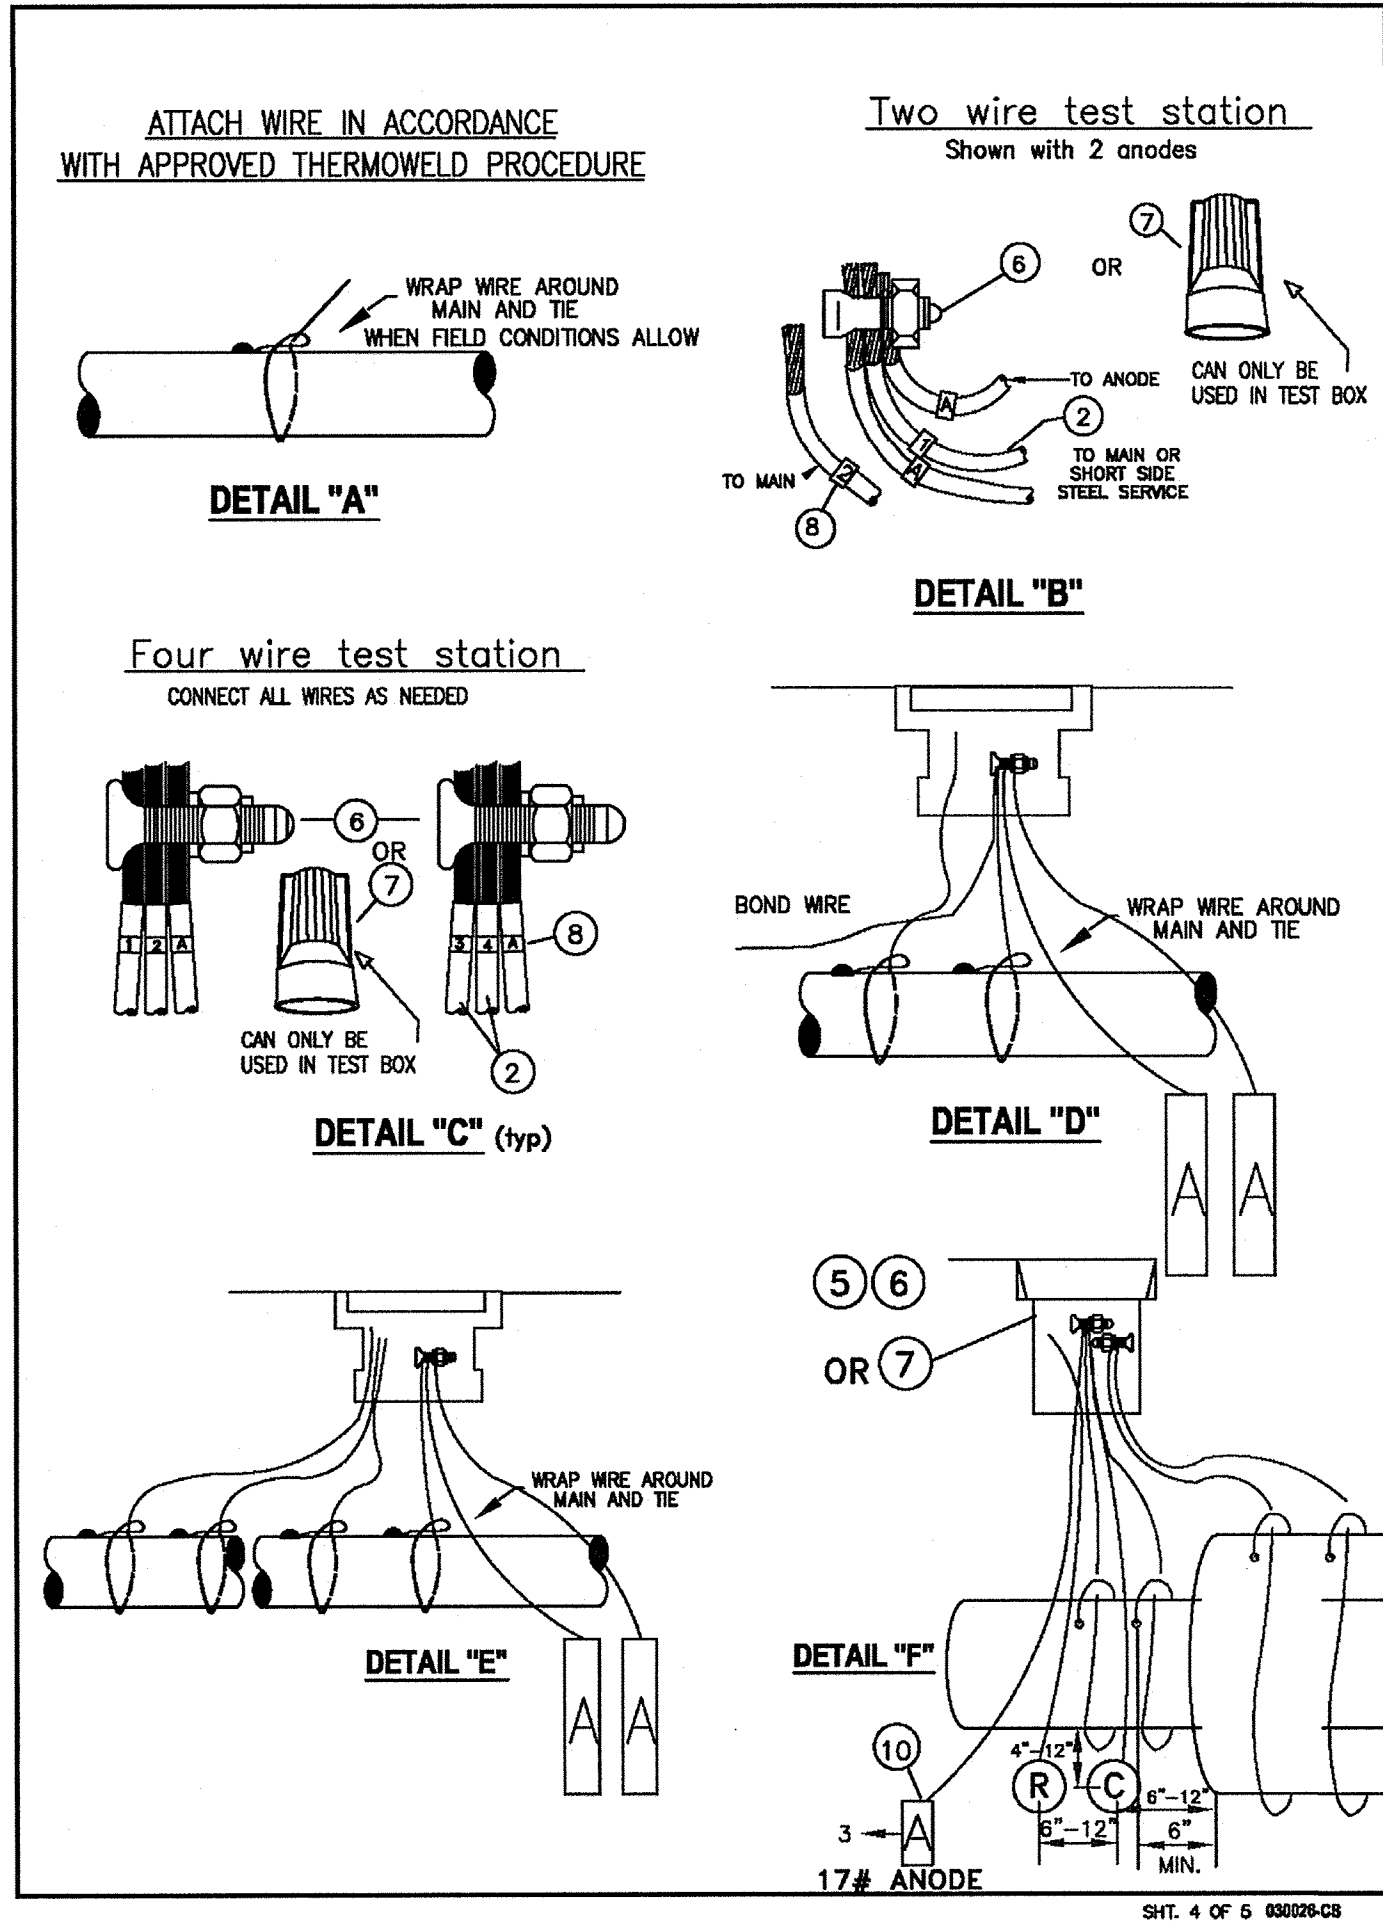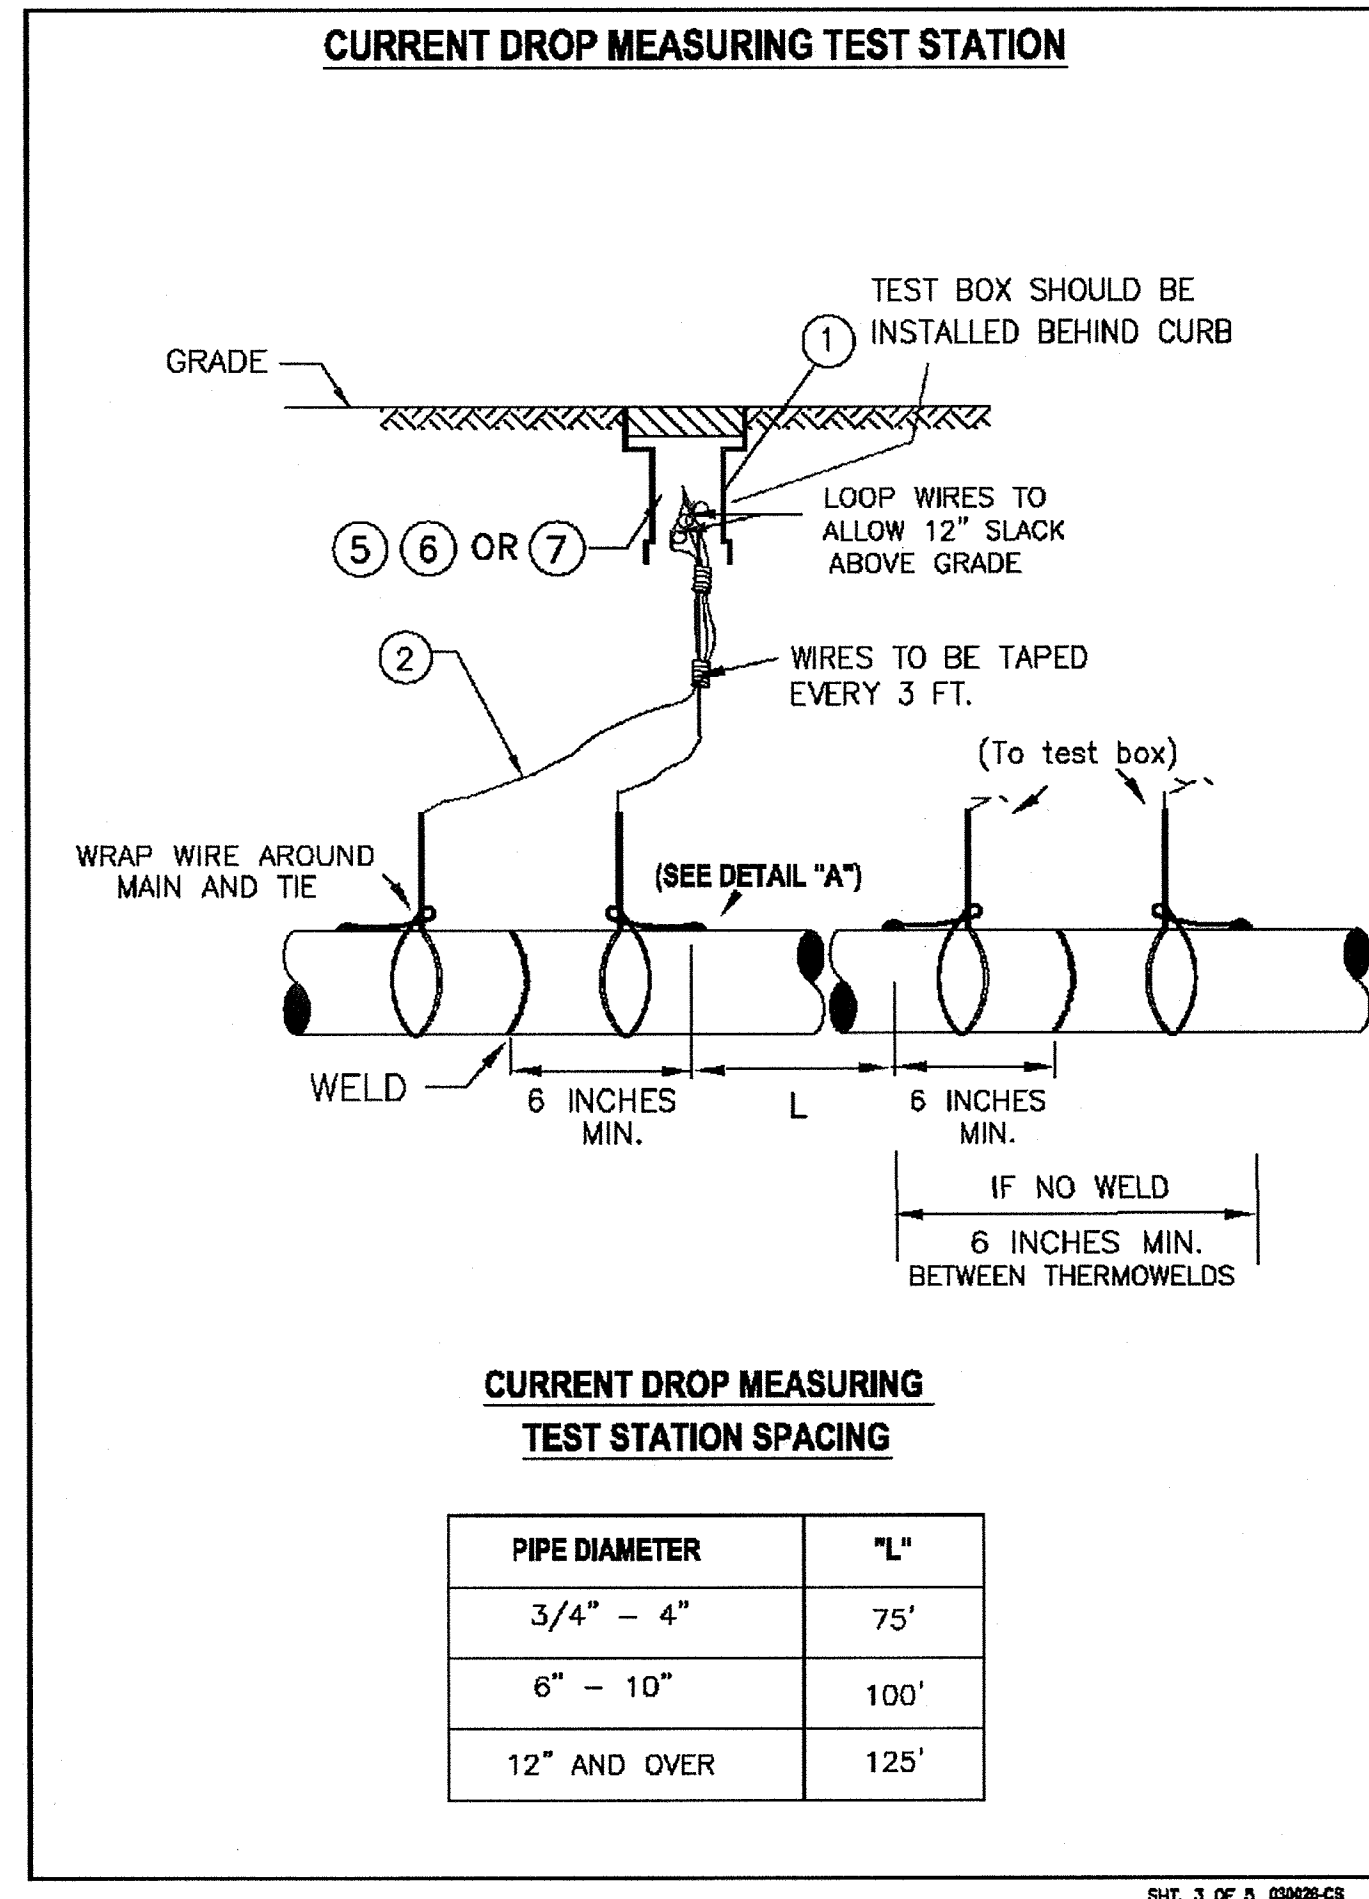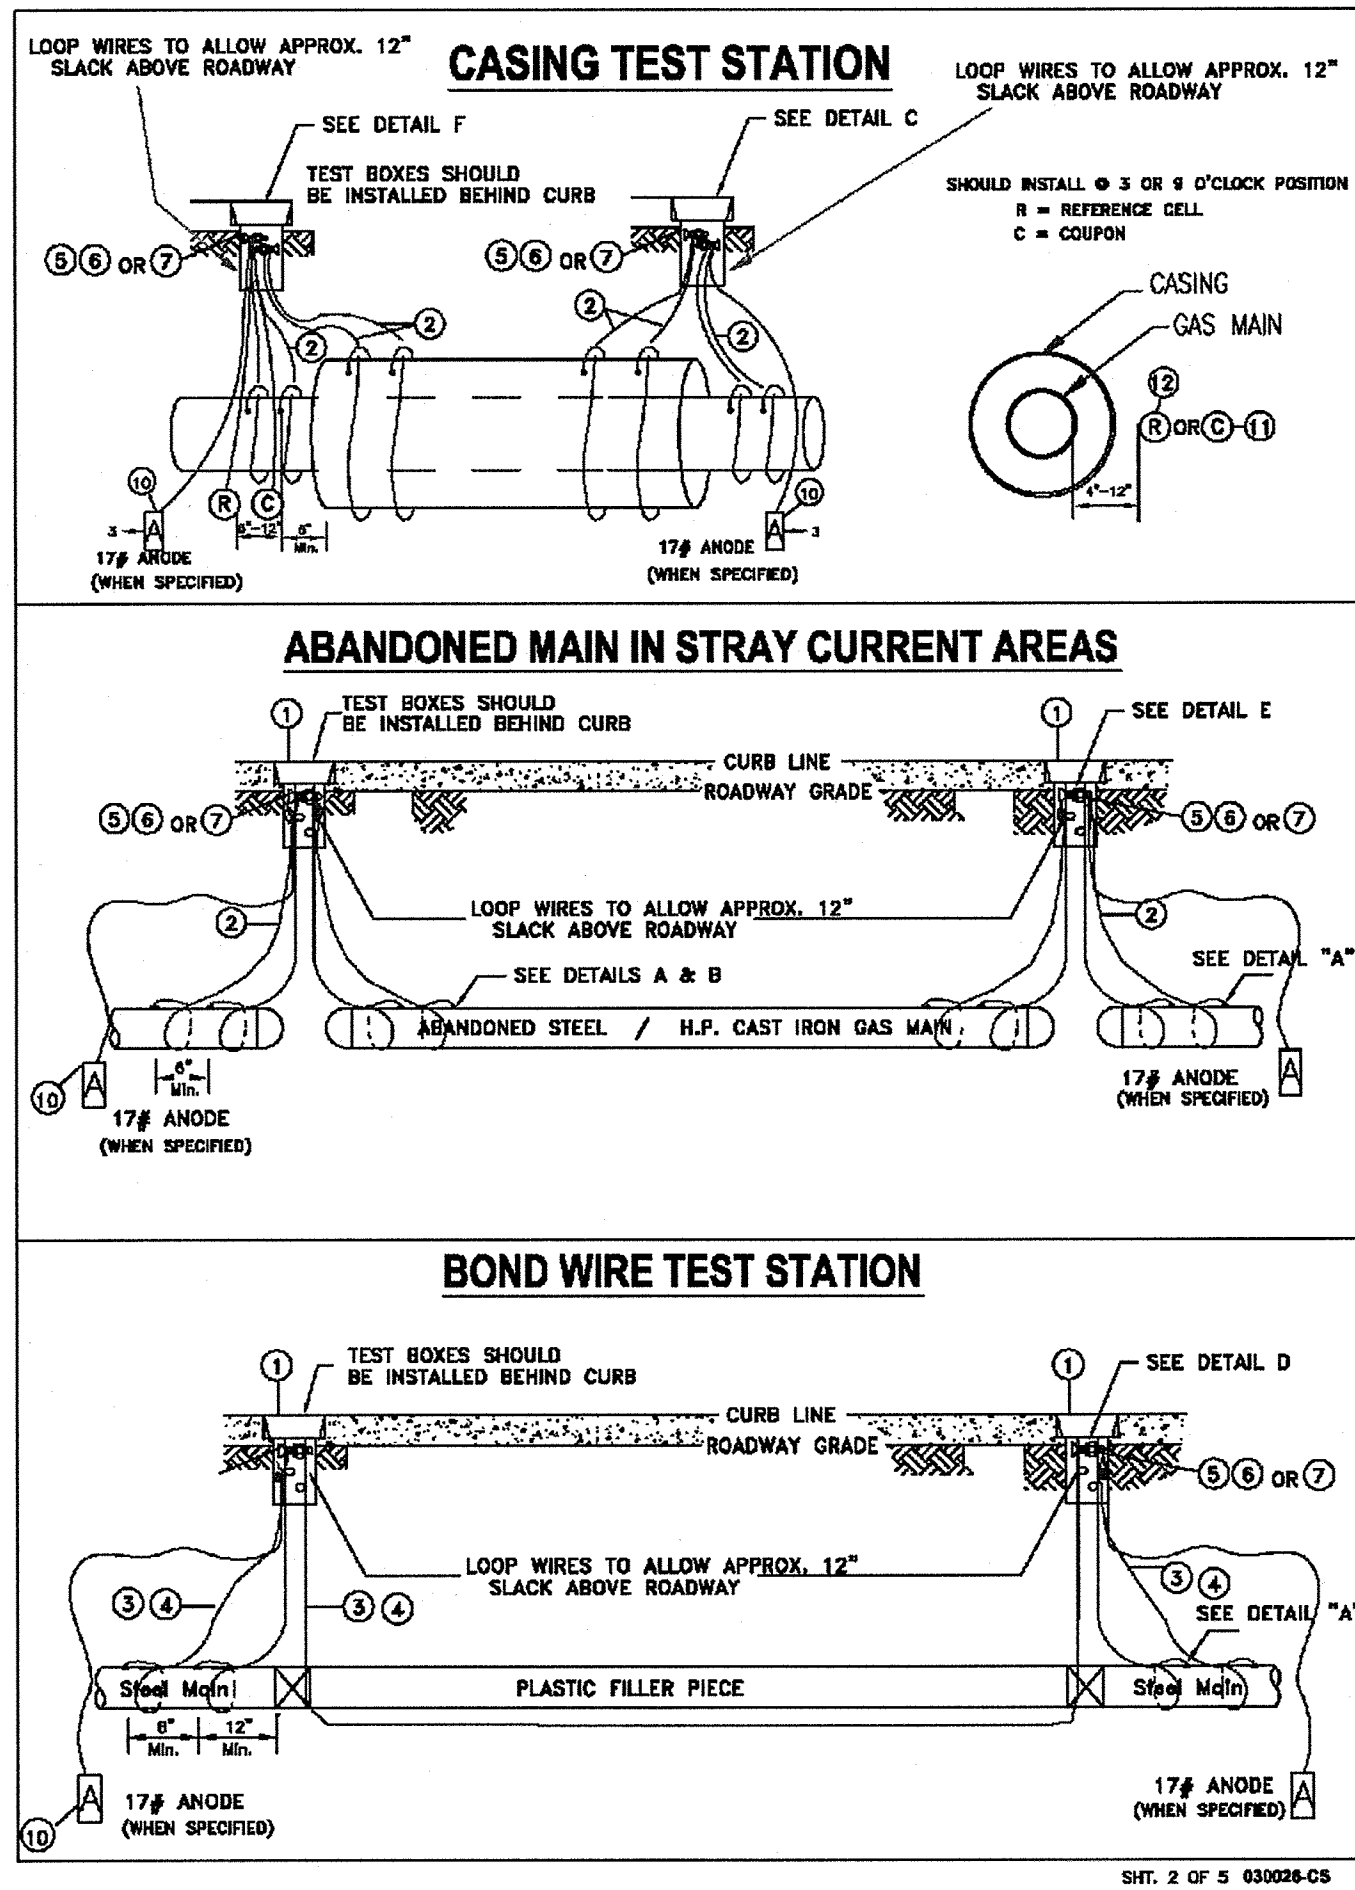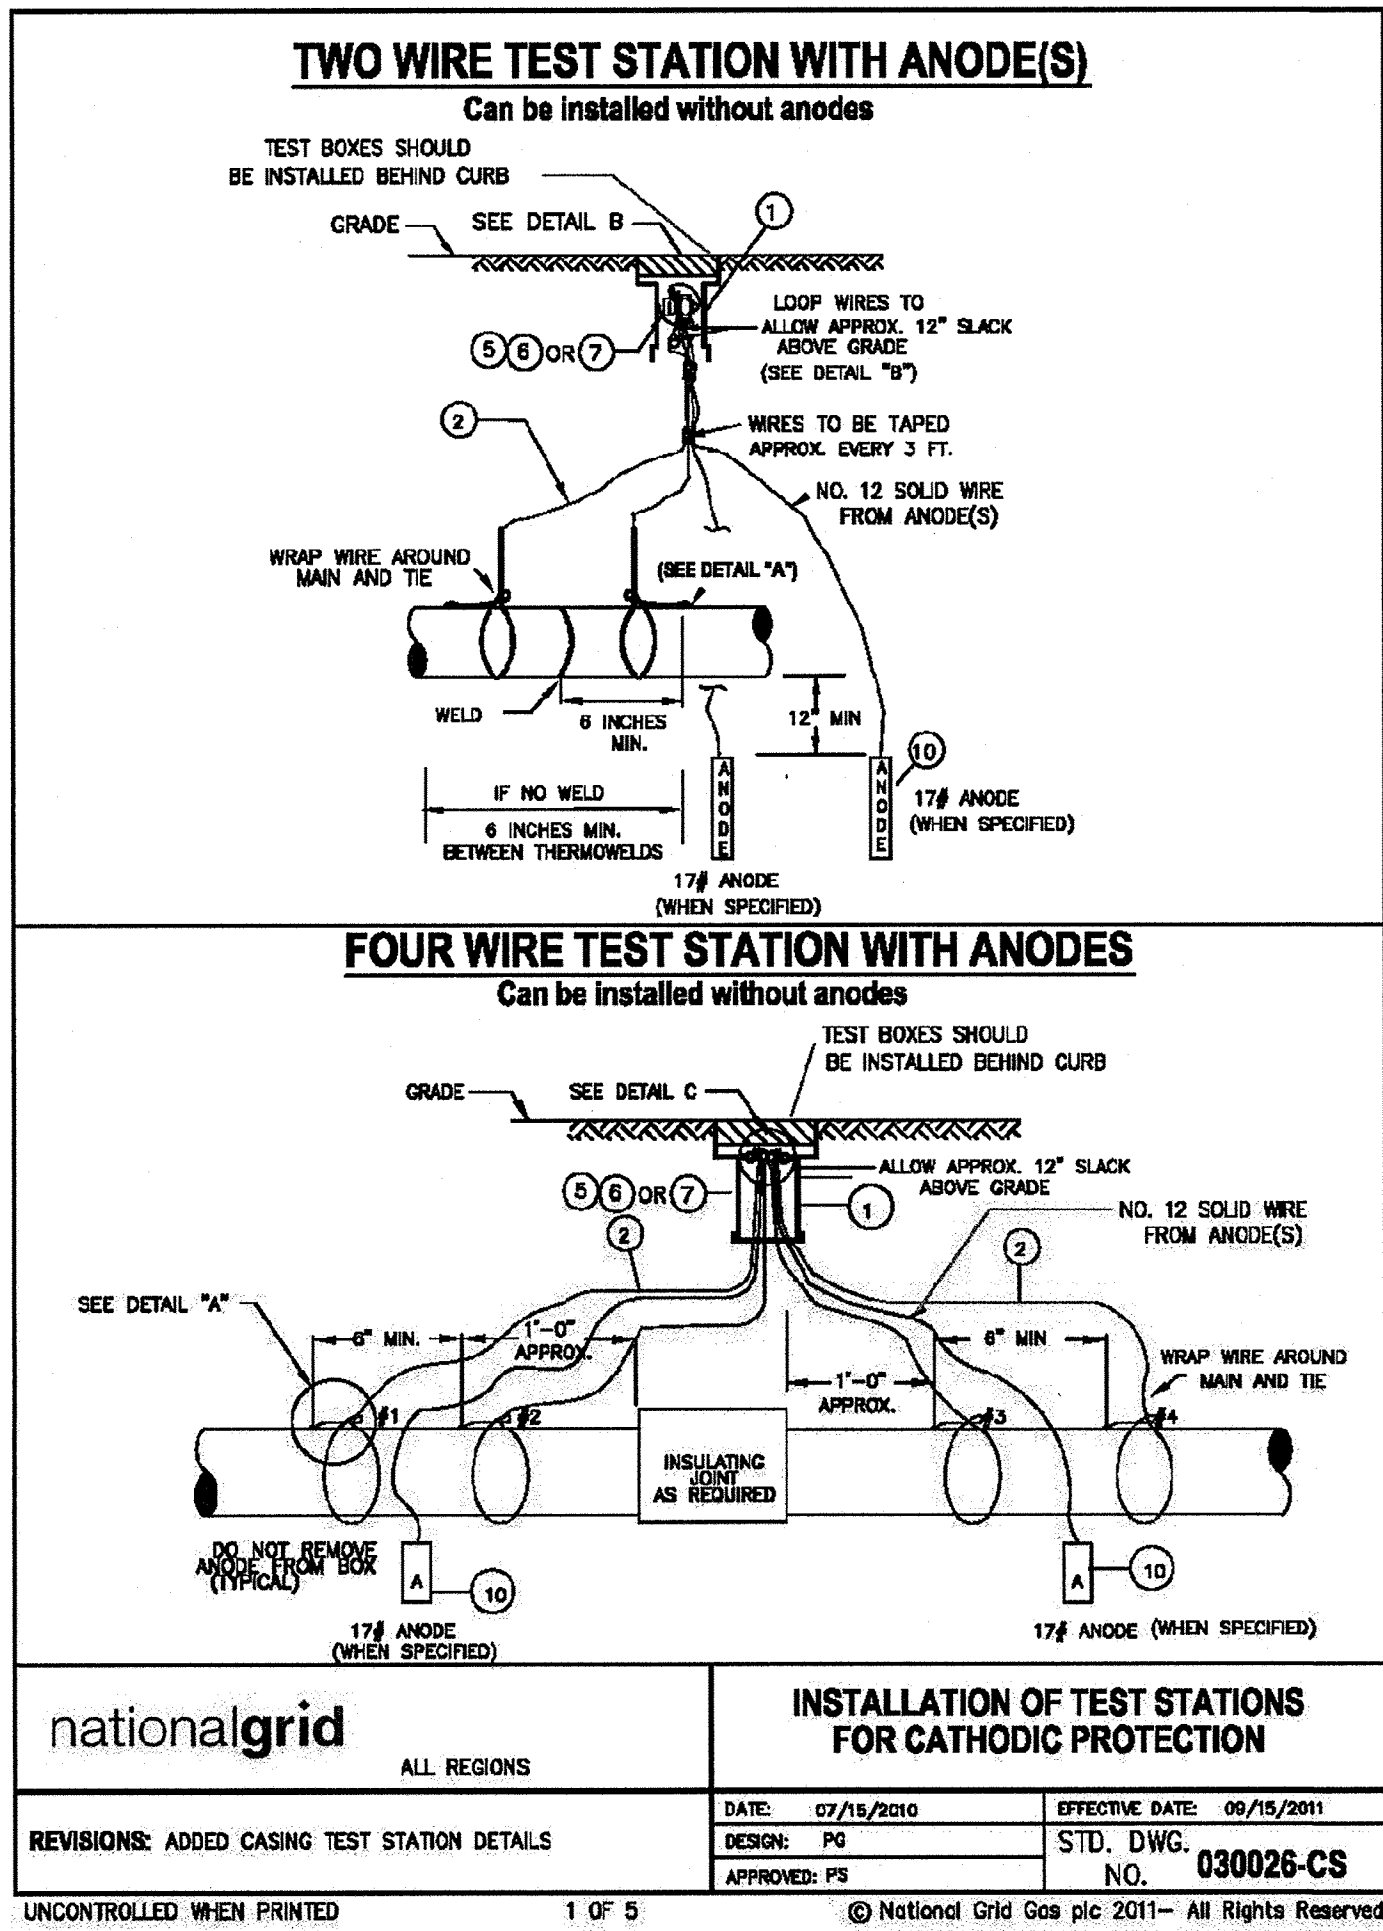

MATERIAL LIST					
Description	Down State ORACLE Item I.D.	Upstate PEOPLE SOFT Item I.D.	New England ORACLE Item I.D.	Rhode Island PEOPLE SOFT Item I.D.	MATERIAL NOTES
1 TEST BOX WITH COVER	00308058	60-08-344 UPSTATE	00308058	4800888 (NM - 4) in Cumb	NON LOCKING COVER. DISCARD FOOT PIECE.
TEST BOX 9" SQUARE HEAVY DUTY	00303157	BOXES COME IN ONE PIECE	00303157	4800885 (Sm - 445) or 4800887 (Lg - 556) in Prov	WEIGHS 95 LBS. STREET USE, WITHOUT COVER
COVER FOR 9" SQUARE BOX	00308014		00308014		NON-LOCKING COVER
2 WIRE, NO. 8, 7 STRAND	00199229	9202887	00199229	9202887	TEST WIRE ONLY, NOT FOR GROUND BEDS, UPSTATE AND RI WIRE HAS 19 STRANDS
3 WIRE, NO. 6, 7 STRAND	00199002	9202901	00199002	9202901	BOND WIRE ONLY, NOT FOR GROUND BEDS
4 WIRE 1/0 - 19 STRAND 600 V - 1/C	00199429	NON STOCK	00199429	NON STOCK	USE IN STRAY CURRENT AREAS
5 TAPE, PVC - 3/2" WIDE	00189008	2005620	00189008	2005620	NOT FOR PIPE COATING. USE WITH NO. 6 CABLE
6 CONNECTOR, SPLIT BOLT, TYPE 6	00124003	20-14-471	00124003	NON STOCK	USE WITH NO. 6 CABLE
CONNECTOR, SPLIT BOLT, TYPE 1/01	00124018		00124018		USE WITH 1/0 CABLE
7 CONNECTOR, TWIST-ON WIRE NUT	00125663	0811102	00125663	0811102	
8 TAG, ADHESIVE NUMBER 1	00339001	9202349	00339001	9202349	LABEL WITH #1 (N) OR (E), CONSECUTIVELY TO (S) OR (W)
NUMBER 2	00339002	9202350	00339002	9202350	SEE DETAILS "B" AND "C"
NUMBER 3	00339003	9202351	00339003	9202351	
NUMBER 4	00339004	9202352	00339004	9202352	
LETTER A	00339007	9202353	00339007	9202353	USE TO LABEL ANODES
9 GROUNDING CELL	NON STOCK	60-10-761	NON STOCK	NON STOCK	AS SPECIFIED BY CORROSION ENGINEERING
10 ANODE, MAGNESIUM 17LBS	00304001	48-00-460	00304001	48-00-460	SATURATE WITH WATER BEFORE BACKFILL. ANODE MAY BE INSTALLED VERTICALLY OR HORIZONTALLY
11 COUPON	00304031	By Corrosion	00304031	By Corrosion	MC MILLER OR EQUAL
12 REFERENCE CELL	00304030	By Corrosion	00304030	By Corrosion	BORIN MFGR INC OR EQUAL

UNCONTROLLED WHEN PRINTED
Effective Date 09/15/2011


5 OF 5

© National Grid Gas plc 2011 - All Rights Reserved
030026-CS

REFERENCE DRAWINGS				REVISIONS			
DRAWING NO.	TITLE	DRAWING NO.	TITLE	NO.	DATE	REMARKS	REV. OKD. COR. APP.
				0	6/14	REVISED FOR FINAL EFSB APPROVAL	KDW SAB KDW JEO

Design/Engineering
CHIA
330 Bear Hill Road, Suite 304
Waltham, MA 02451
Main: (781) 982-7650 • www.chiacompanies.com





Prepared For:
COLONIAL GAS COMPANY
d/b/a
nationalgrid
GAS ENGINEERING DEPARTMENT
40 SHAW ROAD
WALTHAM, MA 02451

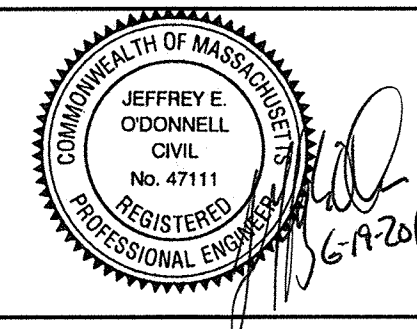

NATIONAL GRID SERVICE COMPANY, USA
MISCELLANEOUS DETAILS
SANDWICH, MA
BARNSTABLE COUNTY, MASSACHUSETTS
File No.: 15-646.01 ALIGN.dwg

APPROVED BY
DATE: SEPTEMBER 7, 2012
MANAGER
NATIONAL GRID SERVICE COMPANY, USA
15-646.01-G-004

TOWN OF SANDWICH
BARNSTABLE COUNTY, MASSACHUSETTS

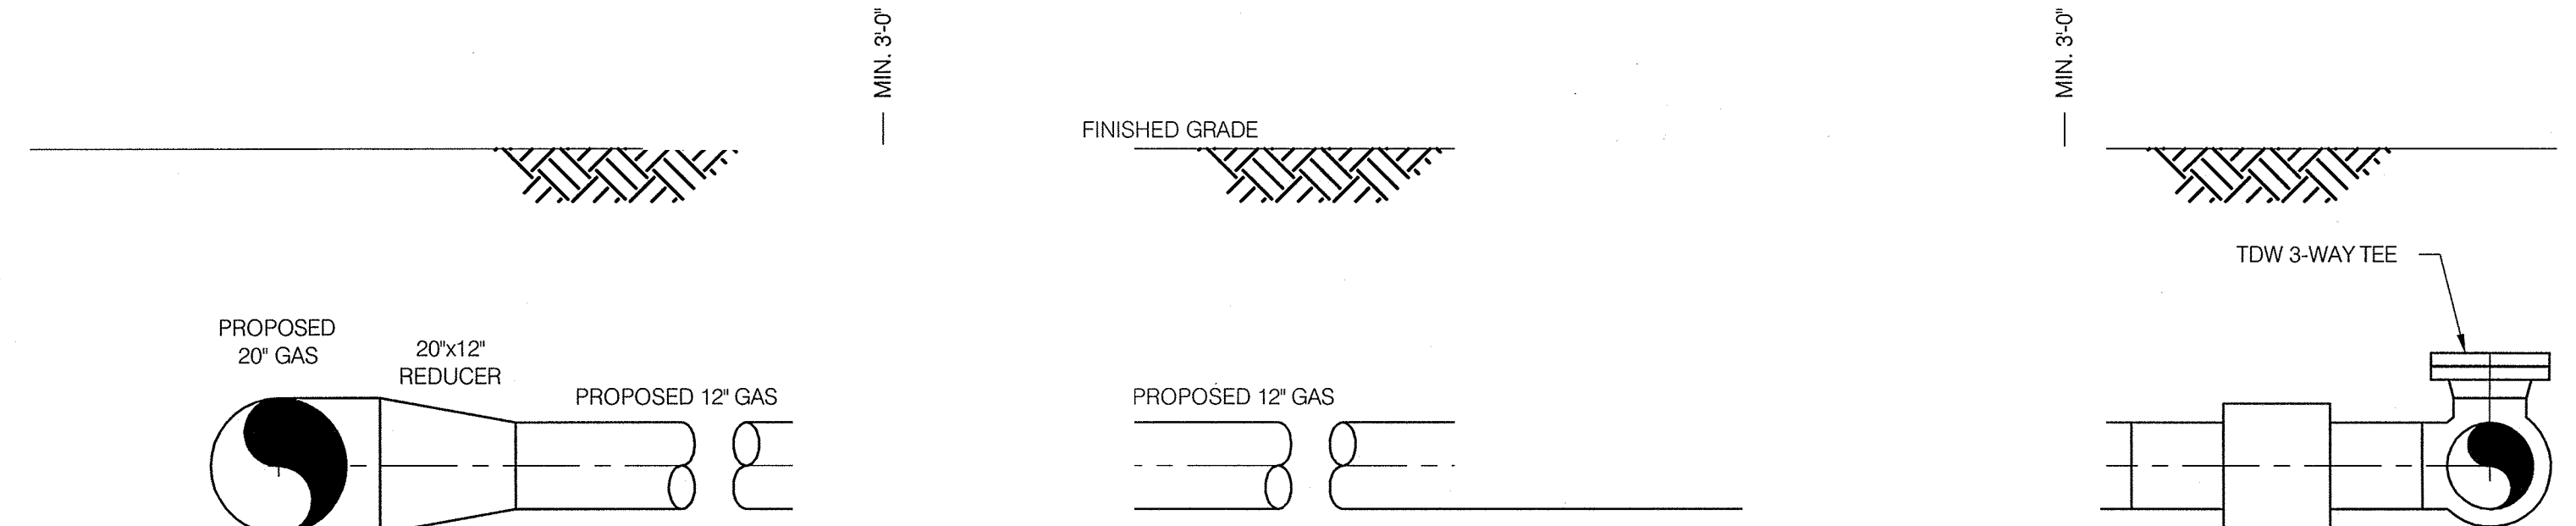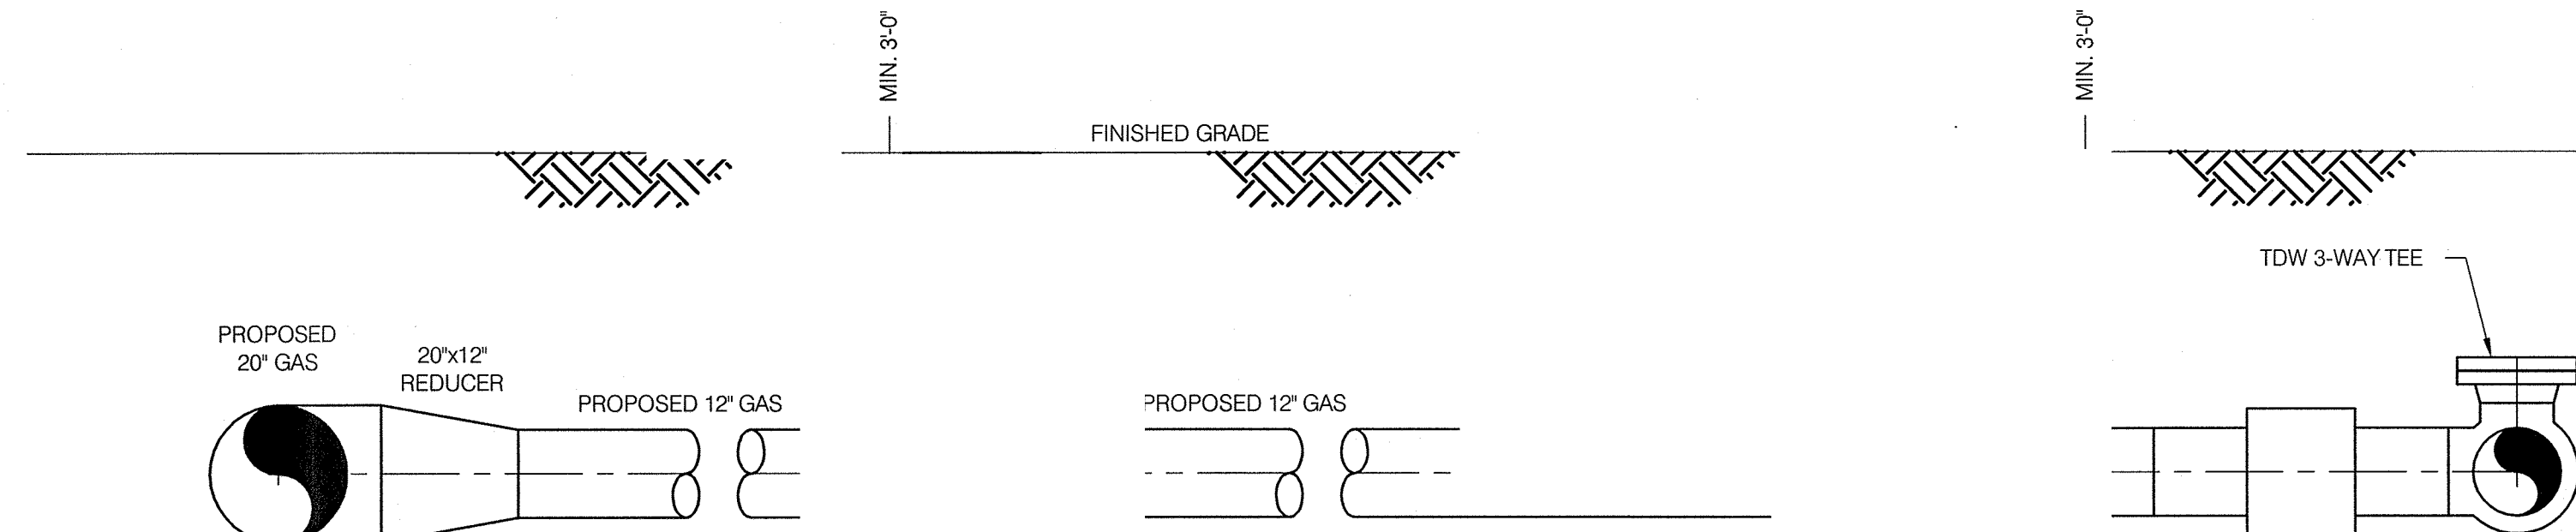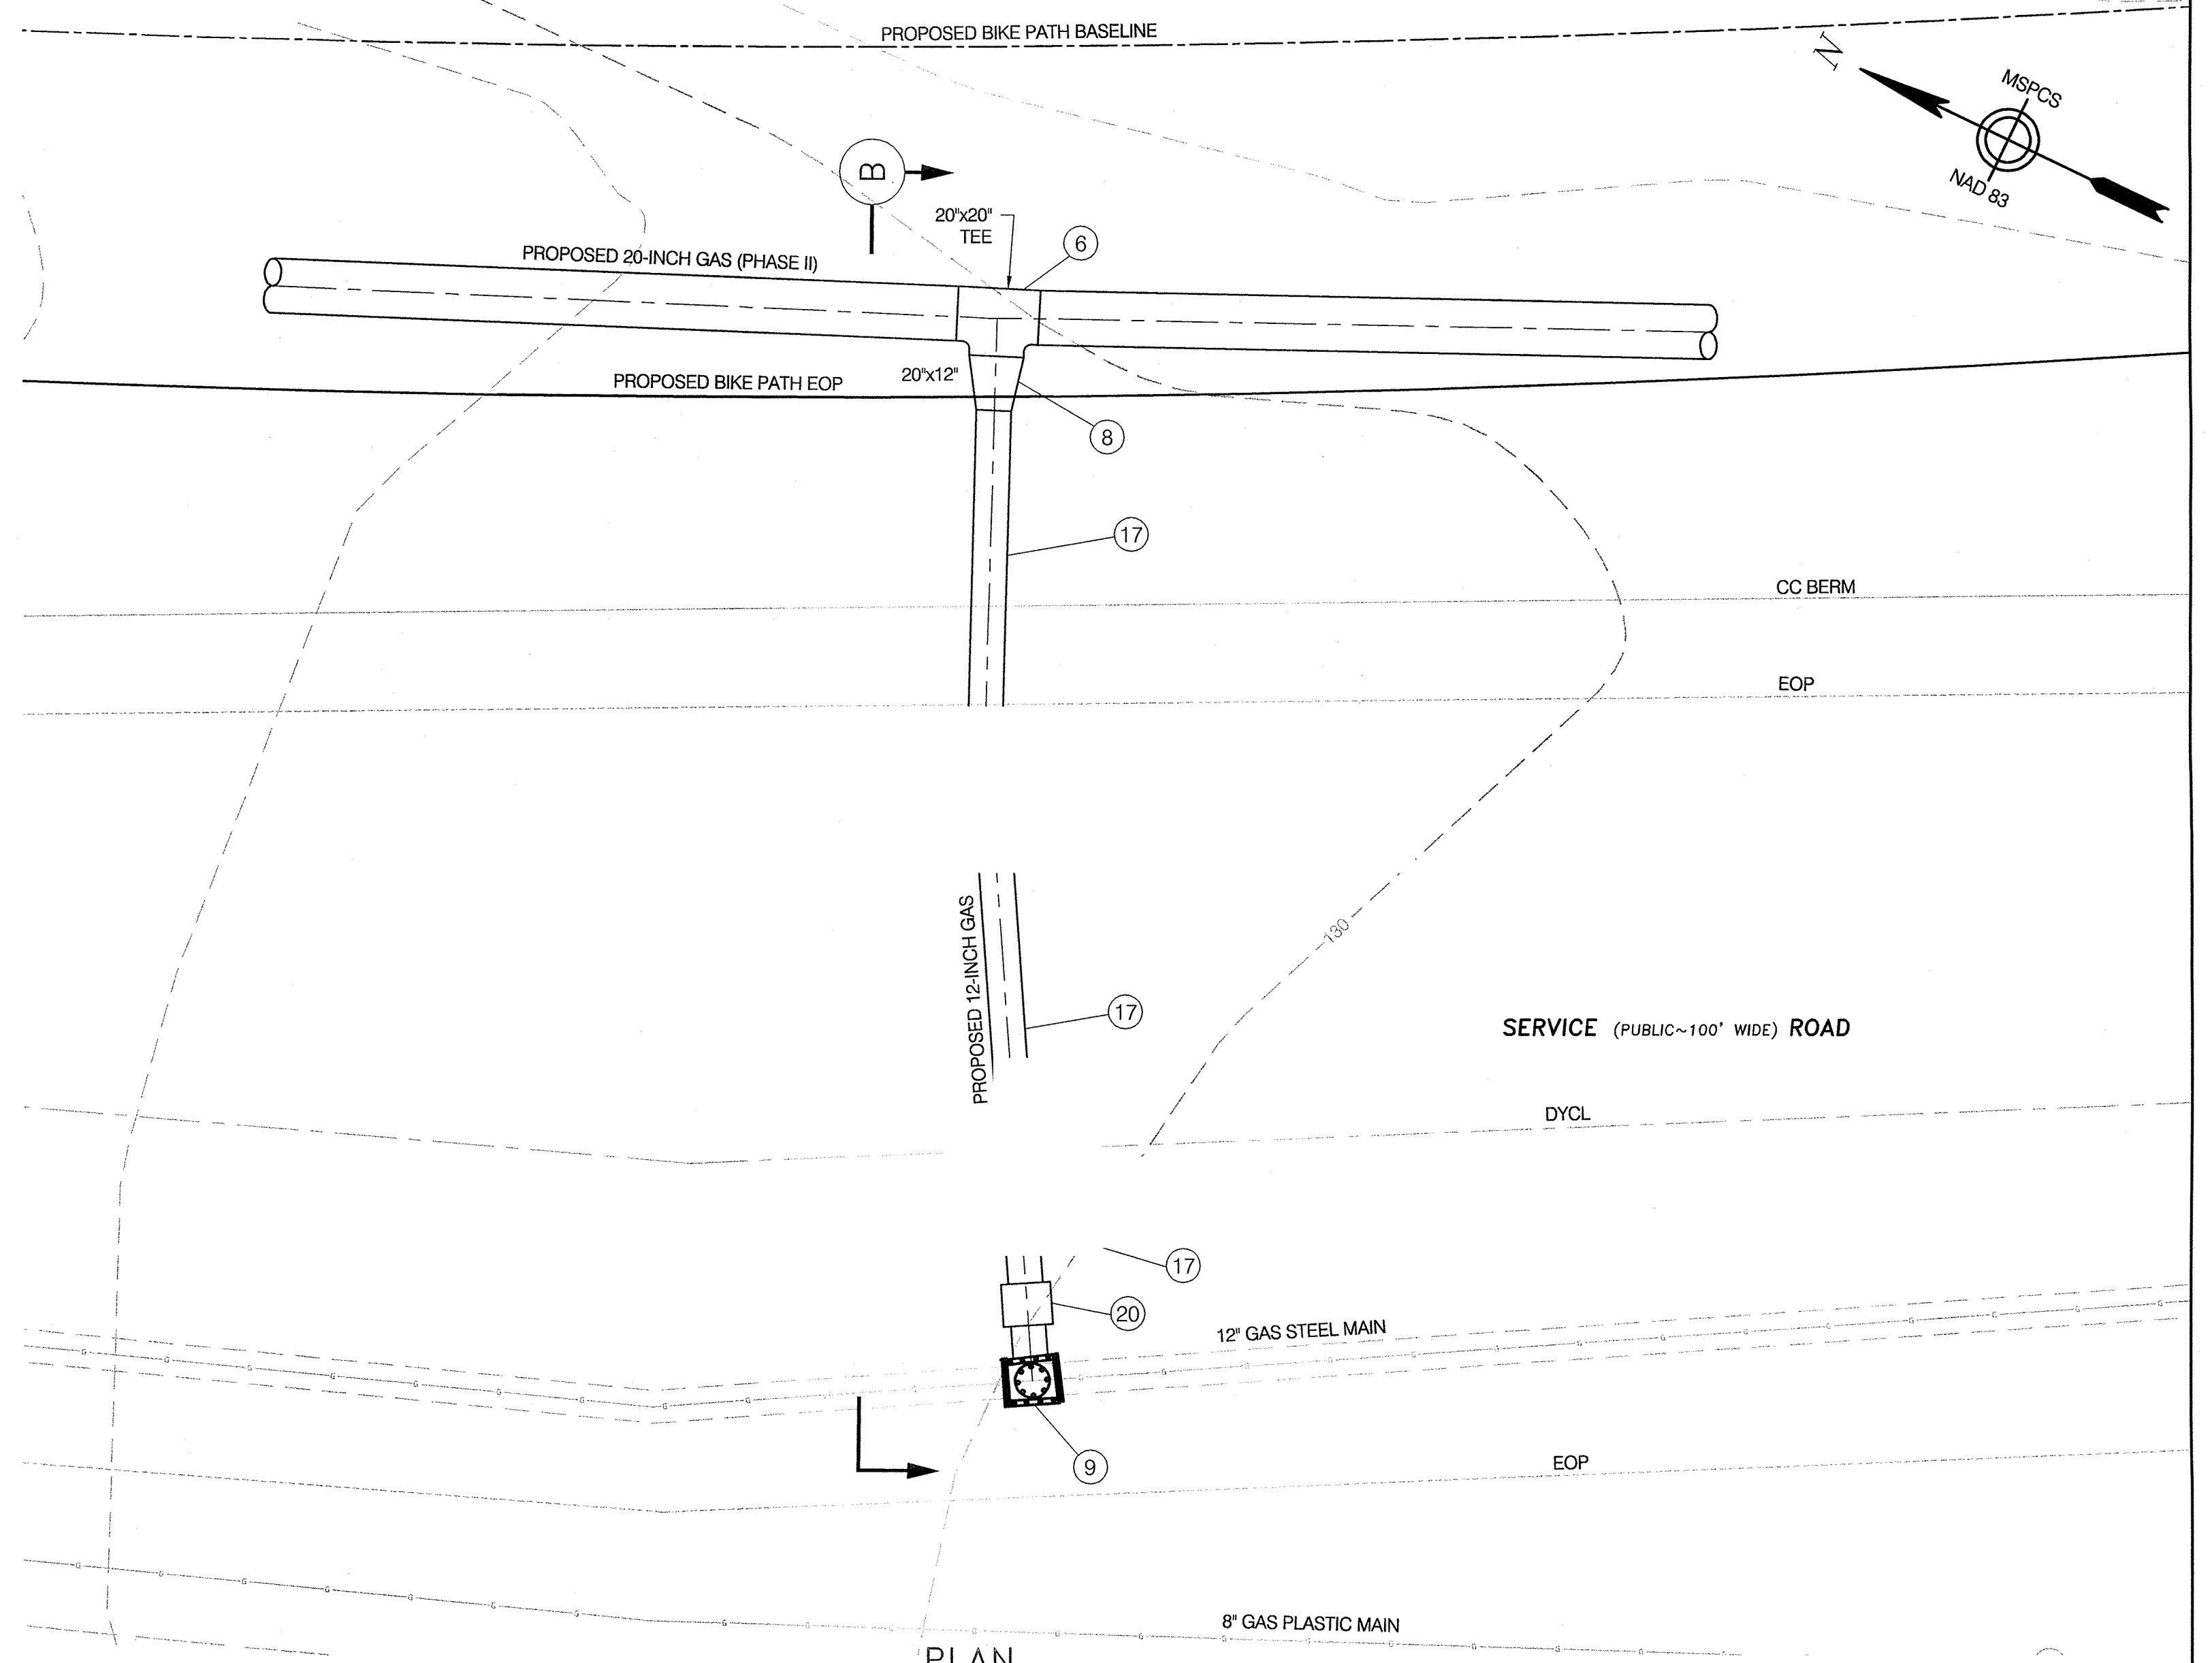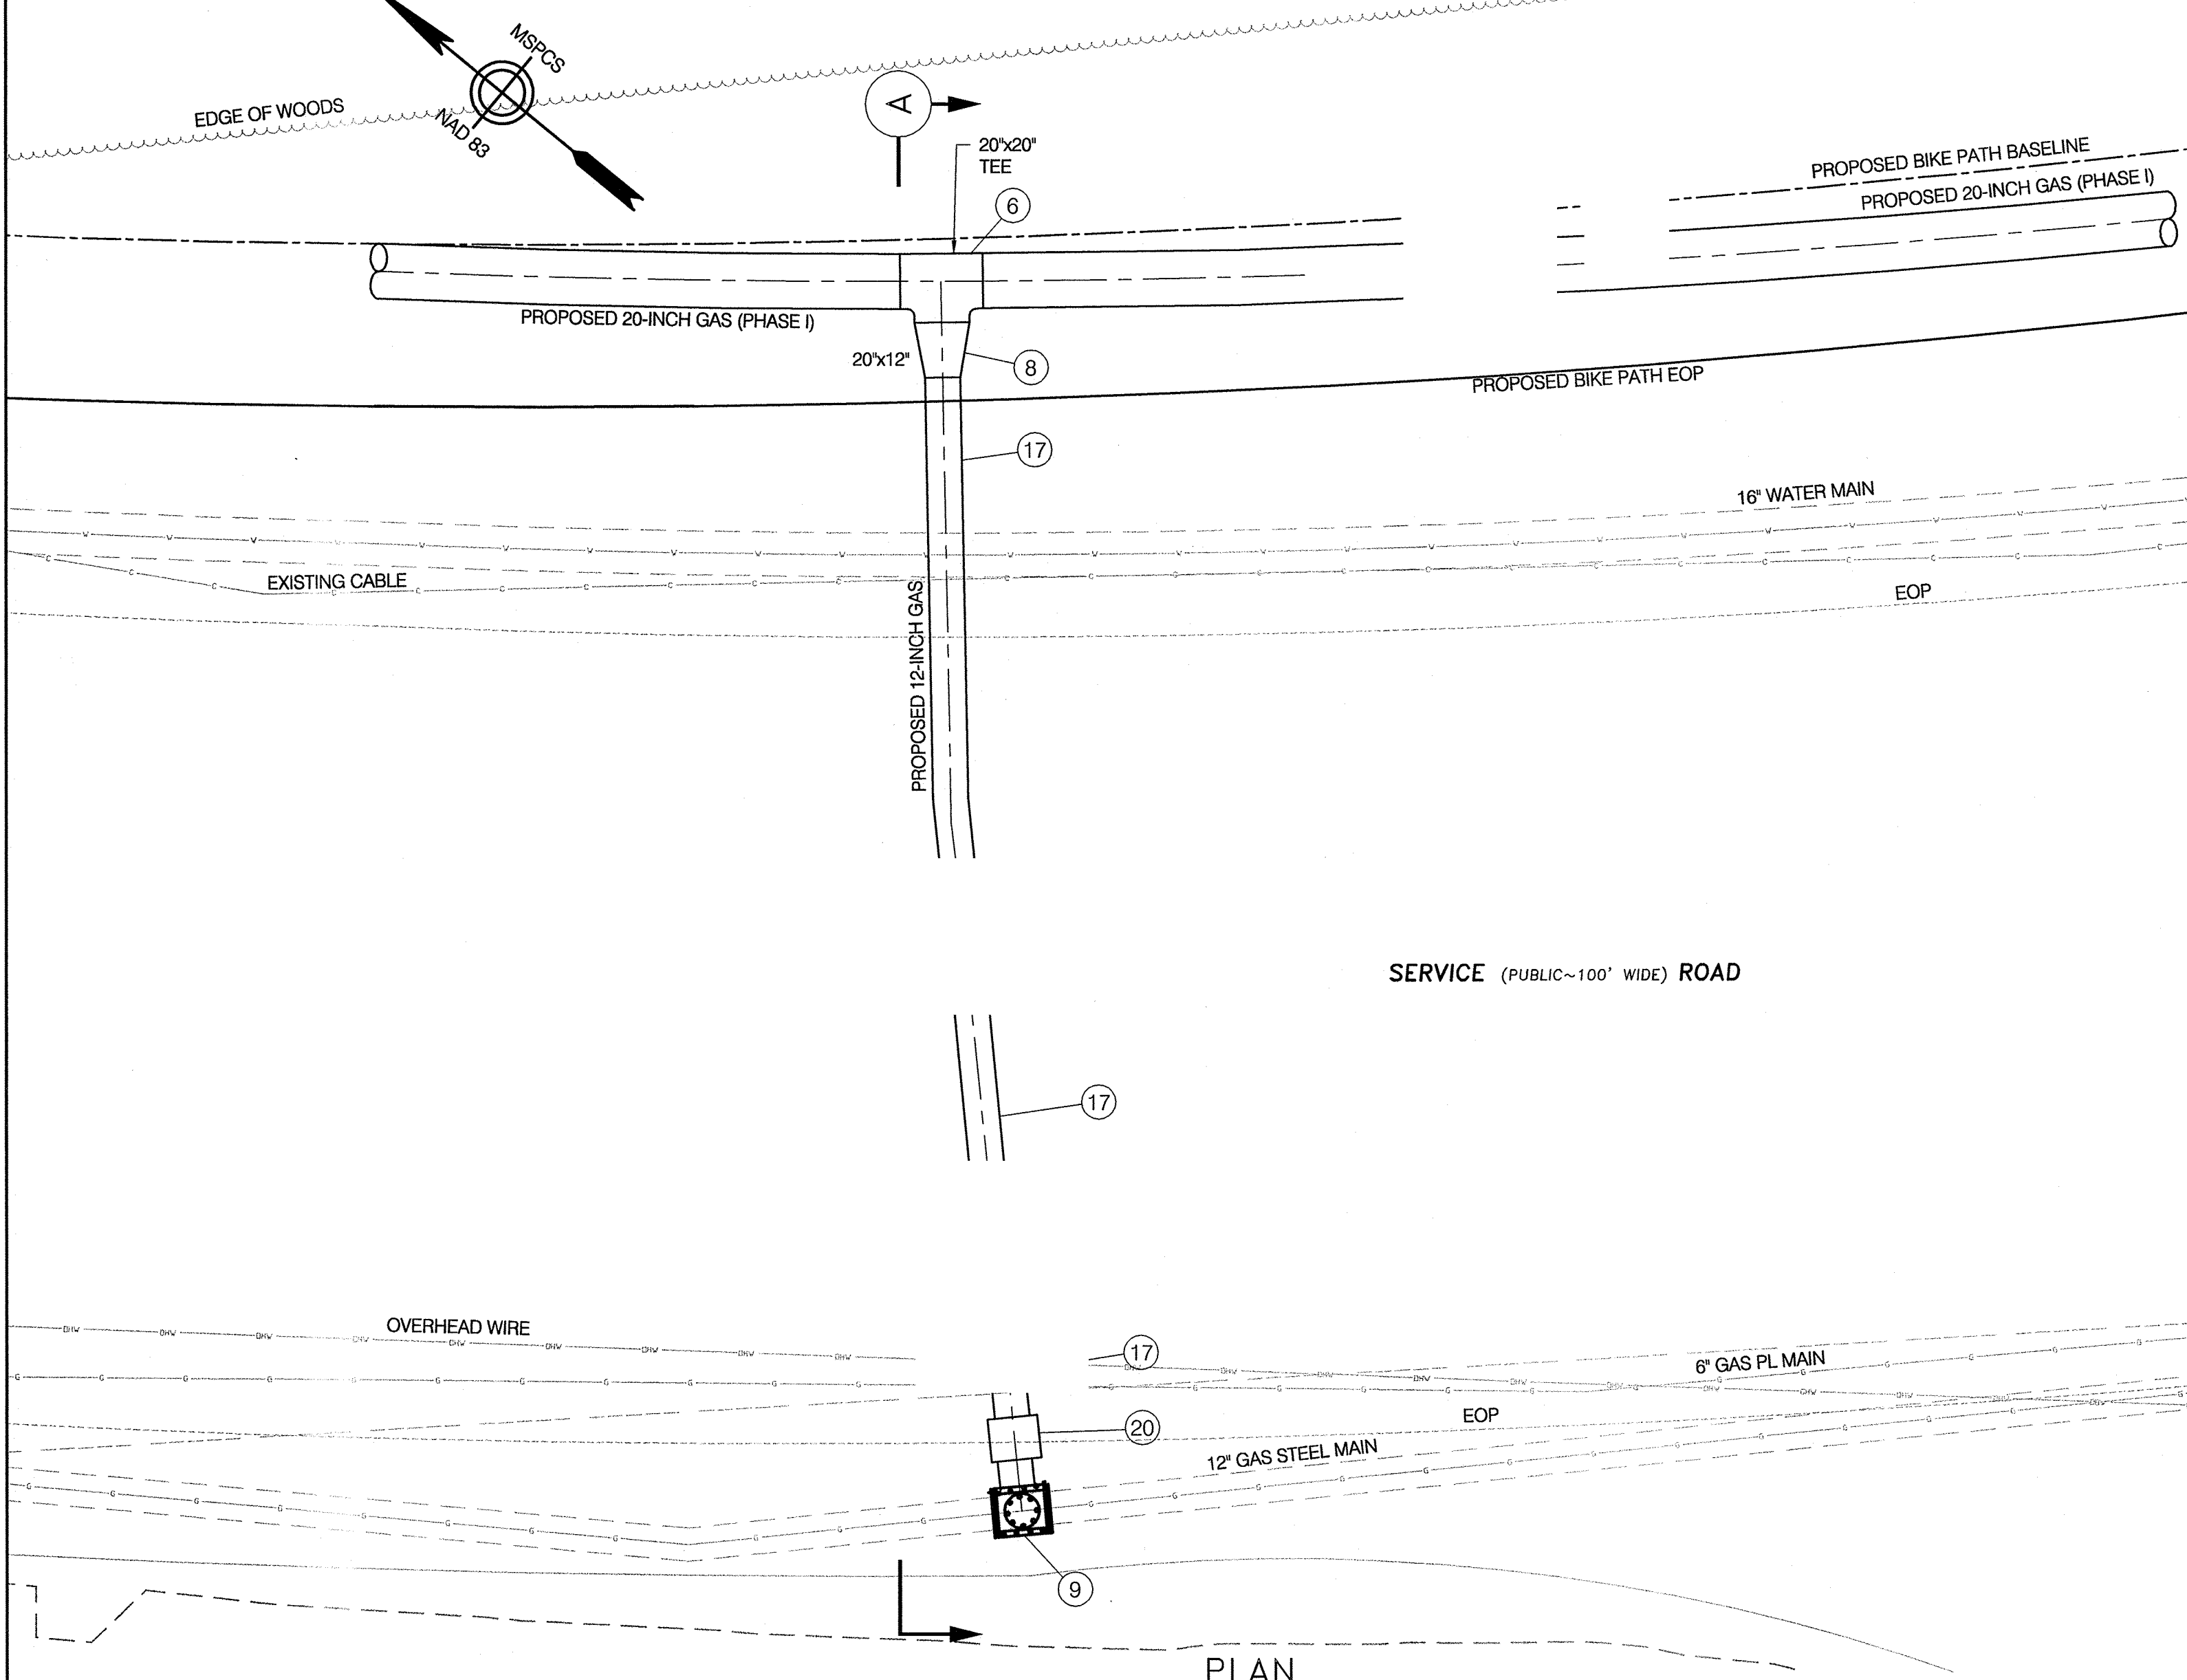

SECTION A
SCALE 1/2"=1'-0"

TIE-IN DETAIL AT STATION 107+23
REF. DRAWING 15-646.01-C-019

SECTION
SCALE 1/2"=1'-0" (B)
TIE-IN DETAIL AT STATION 223+09
REF. DRAWING 15-646.01-C-037

[illegible]

Design/Engineering


CHA

330 Bear Hill Road , Suite 304
Waltham, MA 02451

Main: (781) 982-7650 • www.chacompanies.com


Prepared For:

COLONIAL GAS COMPANY
d/b/a
nationalgrid
GAS ENGINEERING DEPARTMENT
40 SYLVAN RD.
WALTHAM, MA 02451

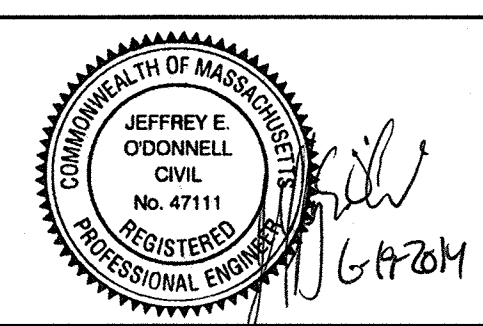

NATIONAL GRID SERVICE COMPANY, USA
TIE-IN DETAILS
SANDWICH, MA
BARNSTABLE COUNTY, MASSACHUSETTS
File No.: 15-646.01 Tie In Details.dwg



APPROVED BY	
DATE: SEPTEMBER 7, 2012	MANAGER
NATIONAL GRID SERVICE COMPANY, USA	
15-646.01-G-005	

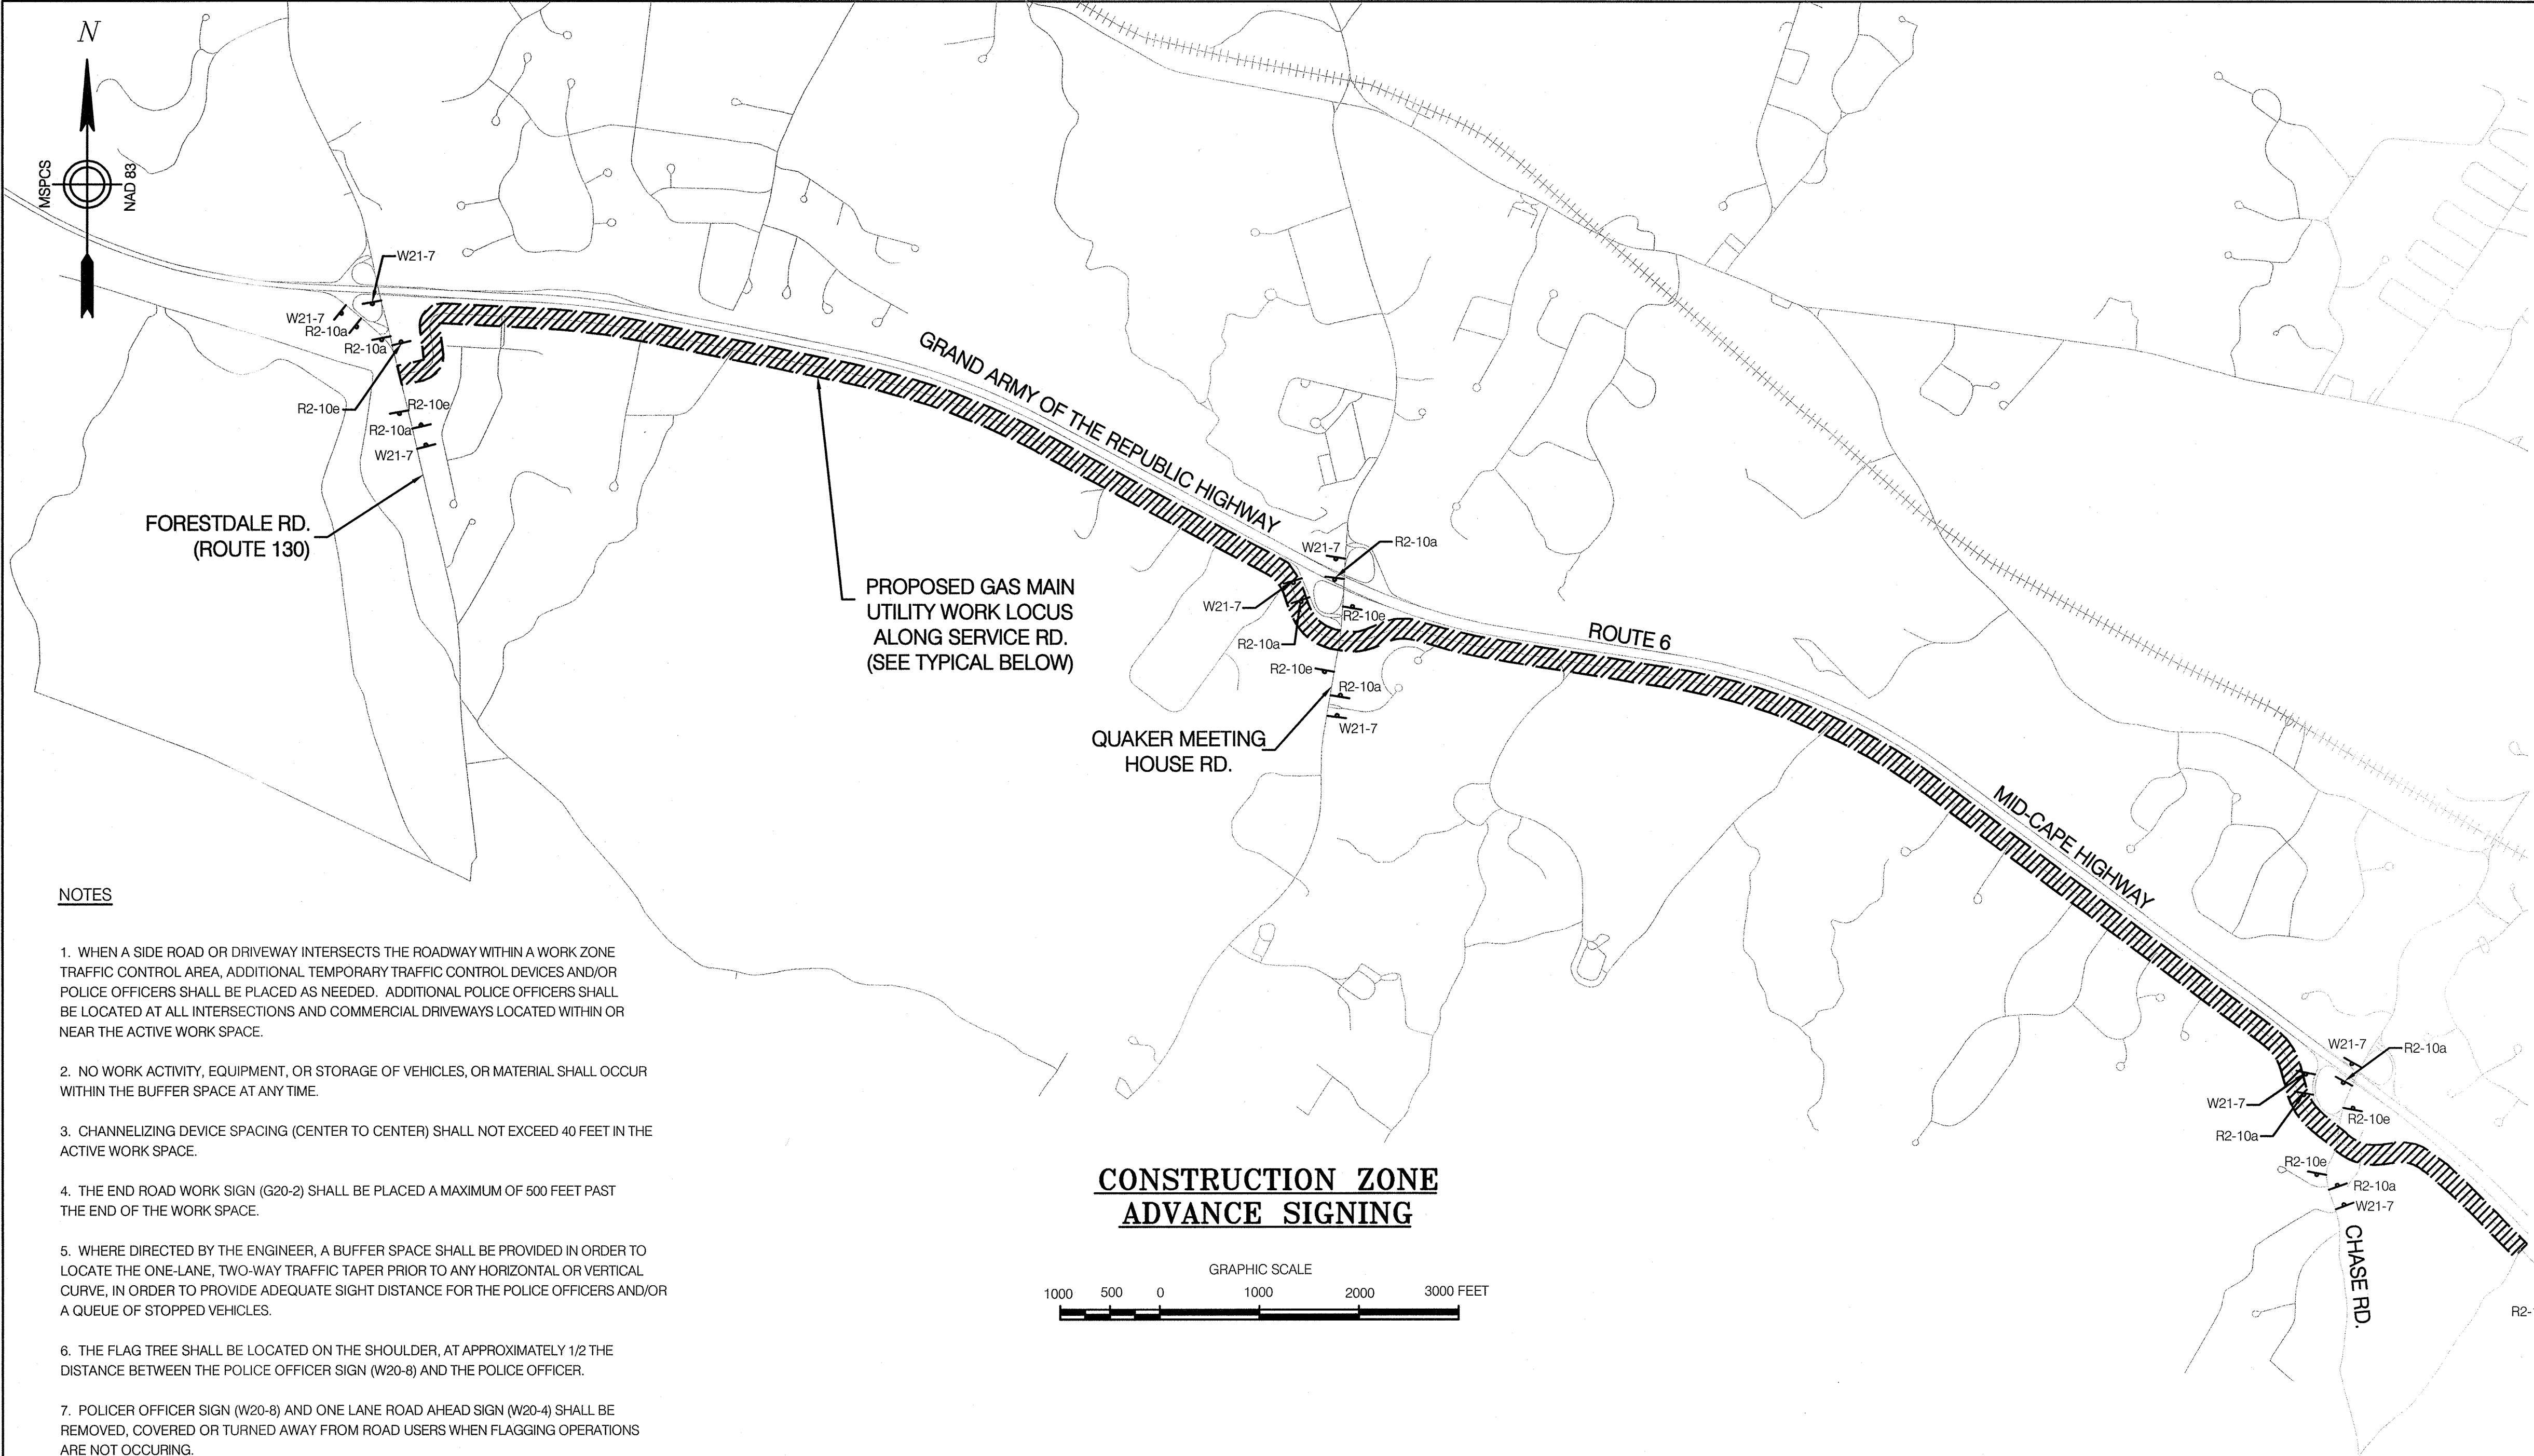

NOTES

1. WHEN A SIDE ROAD OR DRIVEWAY INTERSECTS THE ROADWAY WITHIN A WORK ZONE TRAFFIC CONTROL AREA, ADDITIONAL TEMPORARY TRAFFIC CONTROL DEVICES AND/OR POLICE OFFICERS SHALL BE PLACED AS NEEDED. ADDITIONAL POLICE OFFICERS SHALL BE LOCATED AT ALL INTERSECTIONS AND COMMERCIAL DRIVEWAYS LOCATED WITHIN OR NEAR THE ACTIVE WORK SPACE.
2. NO WORK ACTIVITY, EQUIPMENT, OR STORAGE OF VEHICLES, OR MATERIAL SHALL OCCUR WITHIN THE BUFFER SPACE AT ANY TIME.
3. CHANNELIZING DEVICE SPACING (CENTER TO CENTER) SHALL NOT EXCEED 40 FEET IN THE ACTIVE WORK SPACE.
4. THE END ROAD WORK SIGN (G20-2) SHALL BE PLACED A MAXIMUM OF 500 FEET PAST THE END OF THE WORK SPACE.
5. WHERE DIRECTED BY THE ENGINEER, A BUFFER SPACE SHALL BE PROVIDED IN ORDER TO LOCATE THE ONE-LANE, TWO-WAY TRAFFIC TAPER PRIOR TO ANY HORIZONTAL OR VERTICAL CURVE, IN ORDER TO PROVIDE ADEQUATE SIGHT DISTANCE FOR THE POLICE OFFICERS AND/OR A QUEUE OF STOPPED VEHICLES.
6. THE FLAG TREE SHALL BE LOCATED ON THE SHOULDER, AT APPROXIMATELY 1/2 THE DISTANCE BETWEEN THE POLICE OFFICER SIGN (W20-8) AND THE POLICE OFFICER.
7. POLICER OFFICER SIGN (W20-8) AND ONE LANE ROAD AHEAD SIGN (W20-4) SHALL BE REMOVED, COVERED OR TURNED AWAY FROM ROAD USERS WHEN FLAGGING OPERATIONS ARE NOT OCCURRING.
8. FLAGGER AND FLAG TREE SHALL BE ILLUMINATED TO LEVEL II ILLUMINATION DURING NIGHT TIME OPERATIONS.
9. CENTERLINE CHANNELIZING DEVICES ARE OPTIONAL AND MAY BE ELIMINATED WHERE SPACE CONSTRAINTS EXIST.

CONSTRUCTION ZONE
ADVANCE SIGNING

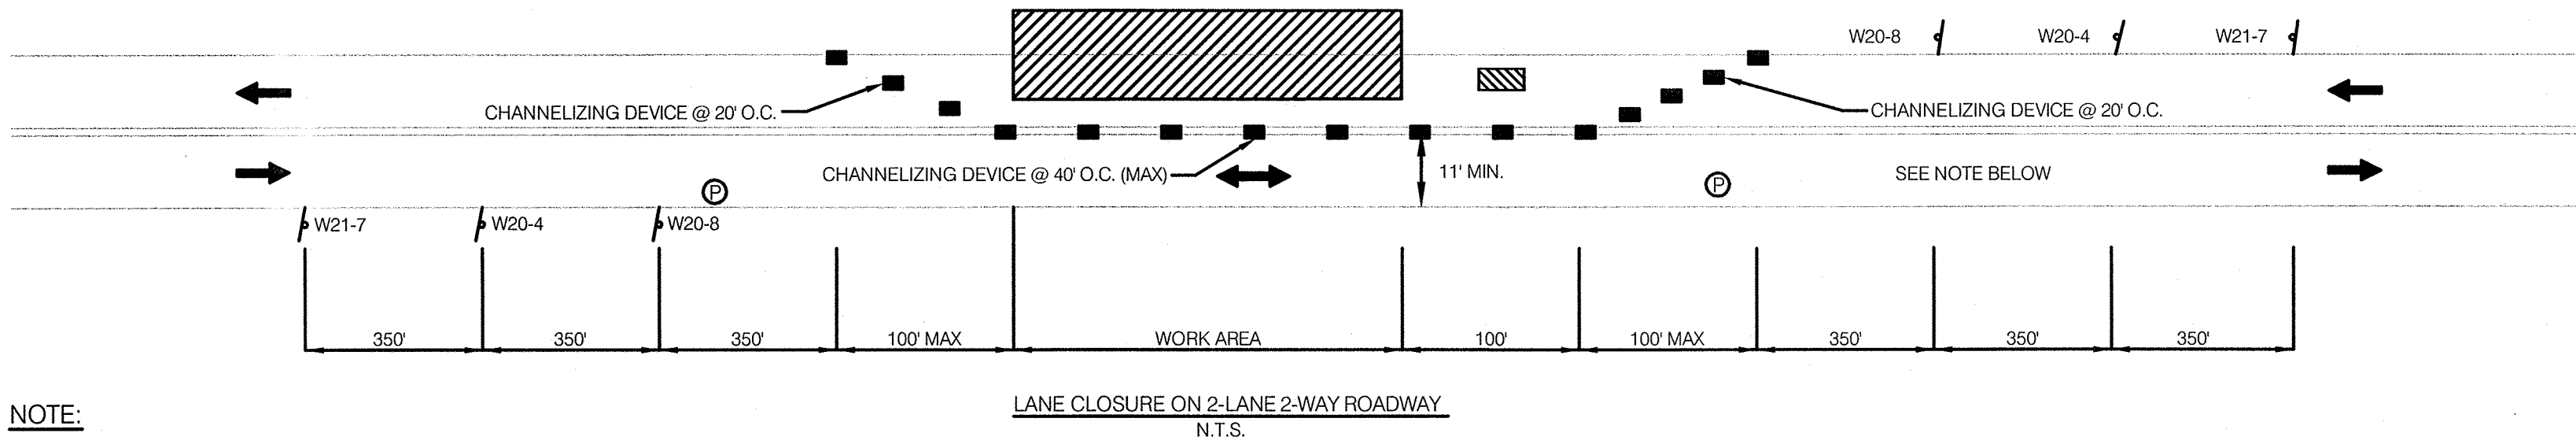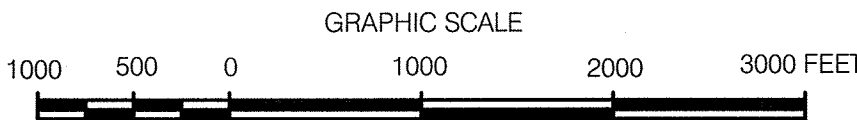

NOTE:

1. NUMBERS AND LOCATIONS OF POLICE FOR WORK ZONE AND/OR DETOUR MANAGEMENT SHALL BE DETERMINED BY THE FIELD ENGINEER ON A CASE BY CASE BASIS, AS WORK PROGRESSES.

TEMPORARY SIGNS

SIGN DESIGNATION	LEGEND	HEIGHT	WIDTH
R2-10e	END ROAD WORK DOUBLE FINES END	24"	30"
R2-10a	WORK ZONE SPEEDING FINES DOUBLED	24"	30"
W20-4	ONE LANE ROAD AHEAD	36"	36"
W20-8	POLICE OFFICER AHEAD	36"	36"
W21-7	UTILITY WORK AHEAD	36"	36"

GENERAL NOTES

1. ALL CONSTRUCTION SIGNING, CHANNELIZING DEVICES, BARRICADES AND OTHER DEVICES SHALL CONFORM WITH THE LATEST EDITION OF THE MANUAL ON UNIFORM TRAFFIC CONTROL DEVICES (M.U.T.C.D.) AND ALL REVISIONS.
2. ALL SIGN LEGENDS, BORDERS AND MOUNTING SHALL BE IN ACCORDANCE WITH THE M.U.T.C.D.
3. TEMPORARY CONSTRUCTION SIGNING AND ALL OTHER TRAFFIC CONTROL DEVICES SHALL BE IN PLACE PRIOR TO THE START OF ANY WORK.
4. ALL DRUMS OR OTHER TRAFFIC CONTROL DEVICES SHALL BE SET @ 20' O.C. MAX IN TAPER ZONES AND 40' O.C. MAX IN WORK ZONES UNLESS OTHERWISE NOTED OR ADJUSTED BY THE FIELD ENGINEER.
5. ALL TRAFFIC CONTROL DEVICES SHALL BE APPROPRIATELY PLACED AND MOVED AS NECESSARY TO MAINTAIN ADEQUATE ABUTTER ACCESS AT ALL TIMES. WORK MAY REQUIRE ADDITIONAL SIGNS, DRUMS AND OTHER TRAFFIC CONTROL DEVICES. GRADING AND TEMPORARY PAVEMENT FOR PASSAGE OF PEDESTRIAN, VEHICULAR AND EMERGENCY TRAFFIC THROUGH THE WORK AREAS, BOTH DURING AND AFTER WORK HOURS, TO MAINTAIN SUCH ACCESS. TEMPORARY PEDESTRIAN ACCESS SHALL BE IN COMPLIANCE WITH ADA/AAB REGULATIONS.
6. TEMPORARY CONSTRUCTION SIGNING, BARRICADES AND ALL OTHER NECESSARY WORK ZONE TRAFFIC CONTROL DEVICES SHALL BE REMOVED FROM THIS ROADWAY OR COVERED WHEN THEY ARE NOT REQUIRED FOR CONTROL OF TRAFFIC.
7. THE CONTRACTOR SHALL NOTIFY EACH ABUTTER AT LEAST 48 HOURS IN ADVANCE OF THE START OF ANY WORK THAT WILL REQUIRE THE TEMPORARY CLOSURE OF ACCESS, SUCH AS EXISTING PAVEMENT EXCAVATION, TEMPORARY DRIVEWAY PAVEMENT PLACEMENT AND SIMILAR OPERATIONS.
8. THE CONTRACTOR SHALL NOTIFY THE TOWN OF SANDWICH POLICE, FIRE, AND DPW AT LEAST 48 HOURS IN ADVANCE OF LANE AND ROADWAY CLOSURES. THE CONTRACTOR SHALL NOTIFY MASSDOT AT LEAST 48 HOURS IN ADVANCE OF WORK THAT IMPACTS STATE HIGHWAY.
9. THE WORK AREA SHALL BE BACKFILLED OR PLATED AT THE END OF EACH WORK PERIOD AND ALL LANES RE-OPENED TO TRAFFIC DURING NON-WORKING HOURS.
10. DETOURS FOR ROAD CLOSURES TO THROUGH TRAFFIC MAY BE NECESSARY. ALL DETOURS SHALL BE APPROVED BY THE TOWN PRIOR TO IMPLEMENTATION.
11. GRADE SEPARATIONS IN EXCESS OF 2 INCHES DURING NON-WORKING HOURS WILL REQUIRE DELINEATION BY USE OF DRUMS.
12. EXCAVATION EDGES IN EXCESS OF 4 INCHES DEEP SHALL BE PROTECTED DURING NON-WORKING HOURS BY BACKFILLING WITH A WEDGE OF GRAVEL OR SOIL COMPACTED TO A 4:1 SLOPE.
13. THE FIRST THREE PLASTIC DRUMS OF A TAPER MAY BE MOUNTED WITH TYPE A LIGHTS.
14. DISTANCES ARE A GUIDE AND MAY BE ADJUSTED IN THE FIELD BY THE ENGINEER.
15. ACCESS TO SIDE STREETS SHALL BE MAINTAINED AT ALL TIMES, UNLESS OTHERWISE NOTED OR APPROVED.
16. MINIMUM LANE WIDTH IS TO BE 11 FEET UNLESS OTHERWISE SHOWN. MINIMUM LANE WIDTH TO BE MEASURED FROM THE OUTSIDE EDGE OF THE DRUMS OR OTHER TRAFFIC CONTROL DEVICES.
17. ALL SIGNS SHALL BE MOUNTED ON THEIR OWN STANDARD SIGN SUPPORTS.
18. THE WORK ZONE SHALL BE SWEEPED CLEAN AT THE END OF EACH WORK DAY. WATER SHALL BE APPLIED TO THE TRENCH AS NEEDED TO CONTROL DUST.

LEGEND

	BARRIER VEHICLE
	CHANNELIZING DEVICE
	CONSTRUCTION SIGN
	DIRECTION OF TRAFFIC
	POLICE OFFICER
	WORK ZONE

File: W:\NATIONAL GRID\2011 REF 01\01 SANDWICH\DRAWINGS\15-646.01 TMP.DWG
Saved: 6/19/2014 9:41:00 AM Plotted: 6/19/2014 9:45:12 AM User: Wentworth, Kevin LastSavedBy: 4340

REFERENCE DRAWINGS				REVISIONS						
DRAWING NO.	TITLE	DRAWING NO.	TITLE	NO.	DATE	REMARKS	REV.	CKD.	COR.	APP.
				0	6/14	REVISED FOR FINAL EFSB APPROVAL	KDW	SAB	KDW	JEO

Design/Engineering

CHA

330 Bear Hill Road, Suite 304
Waltham, MA 02451
Main: (781) 862-7650 • www.chacompanies.com

Prepared For:

COLONIAL GAS COMPANY
d/b/a
nationalgrid
GAS ENGINEERING DEPARTMENT
40 SYLVAN RD.
WALTHAM, MA 02451

COMMONWEALTH OF MASSACHUSETTS

JEFFREY E. O'DONNELL
CIVIL
No. 47111
REGISTERED
PROFESSIONAL ENGINEER

6-19-2014

NATIONAL GRID
TRAFFIC MANAGEMENT PLANS
ADVANCE WARNING & TYPICALS PLAN
SANDWICH, MASSACHUSETTS

File No.: 15-646.01 TMP.dwg


APPROVED BY

DATE: SEPTEMBER 7, 2012

MANAGER

NATIONAL GRID SERVICE COMPANY, USA

15-646.01-TMP-001

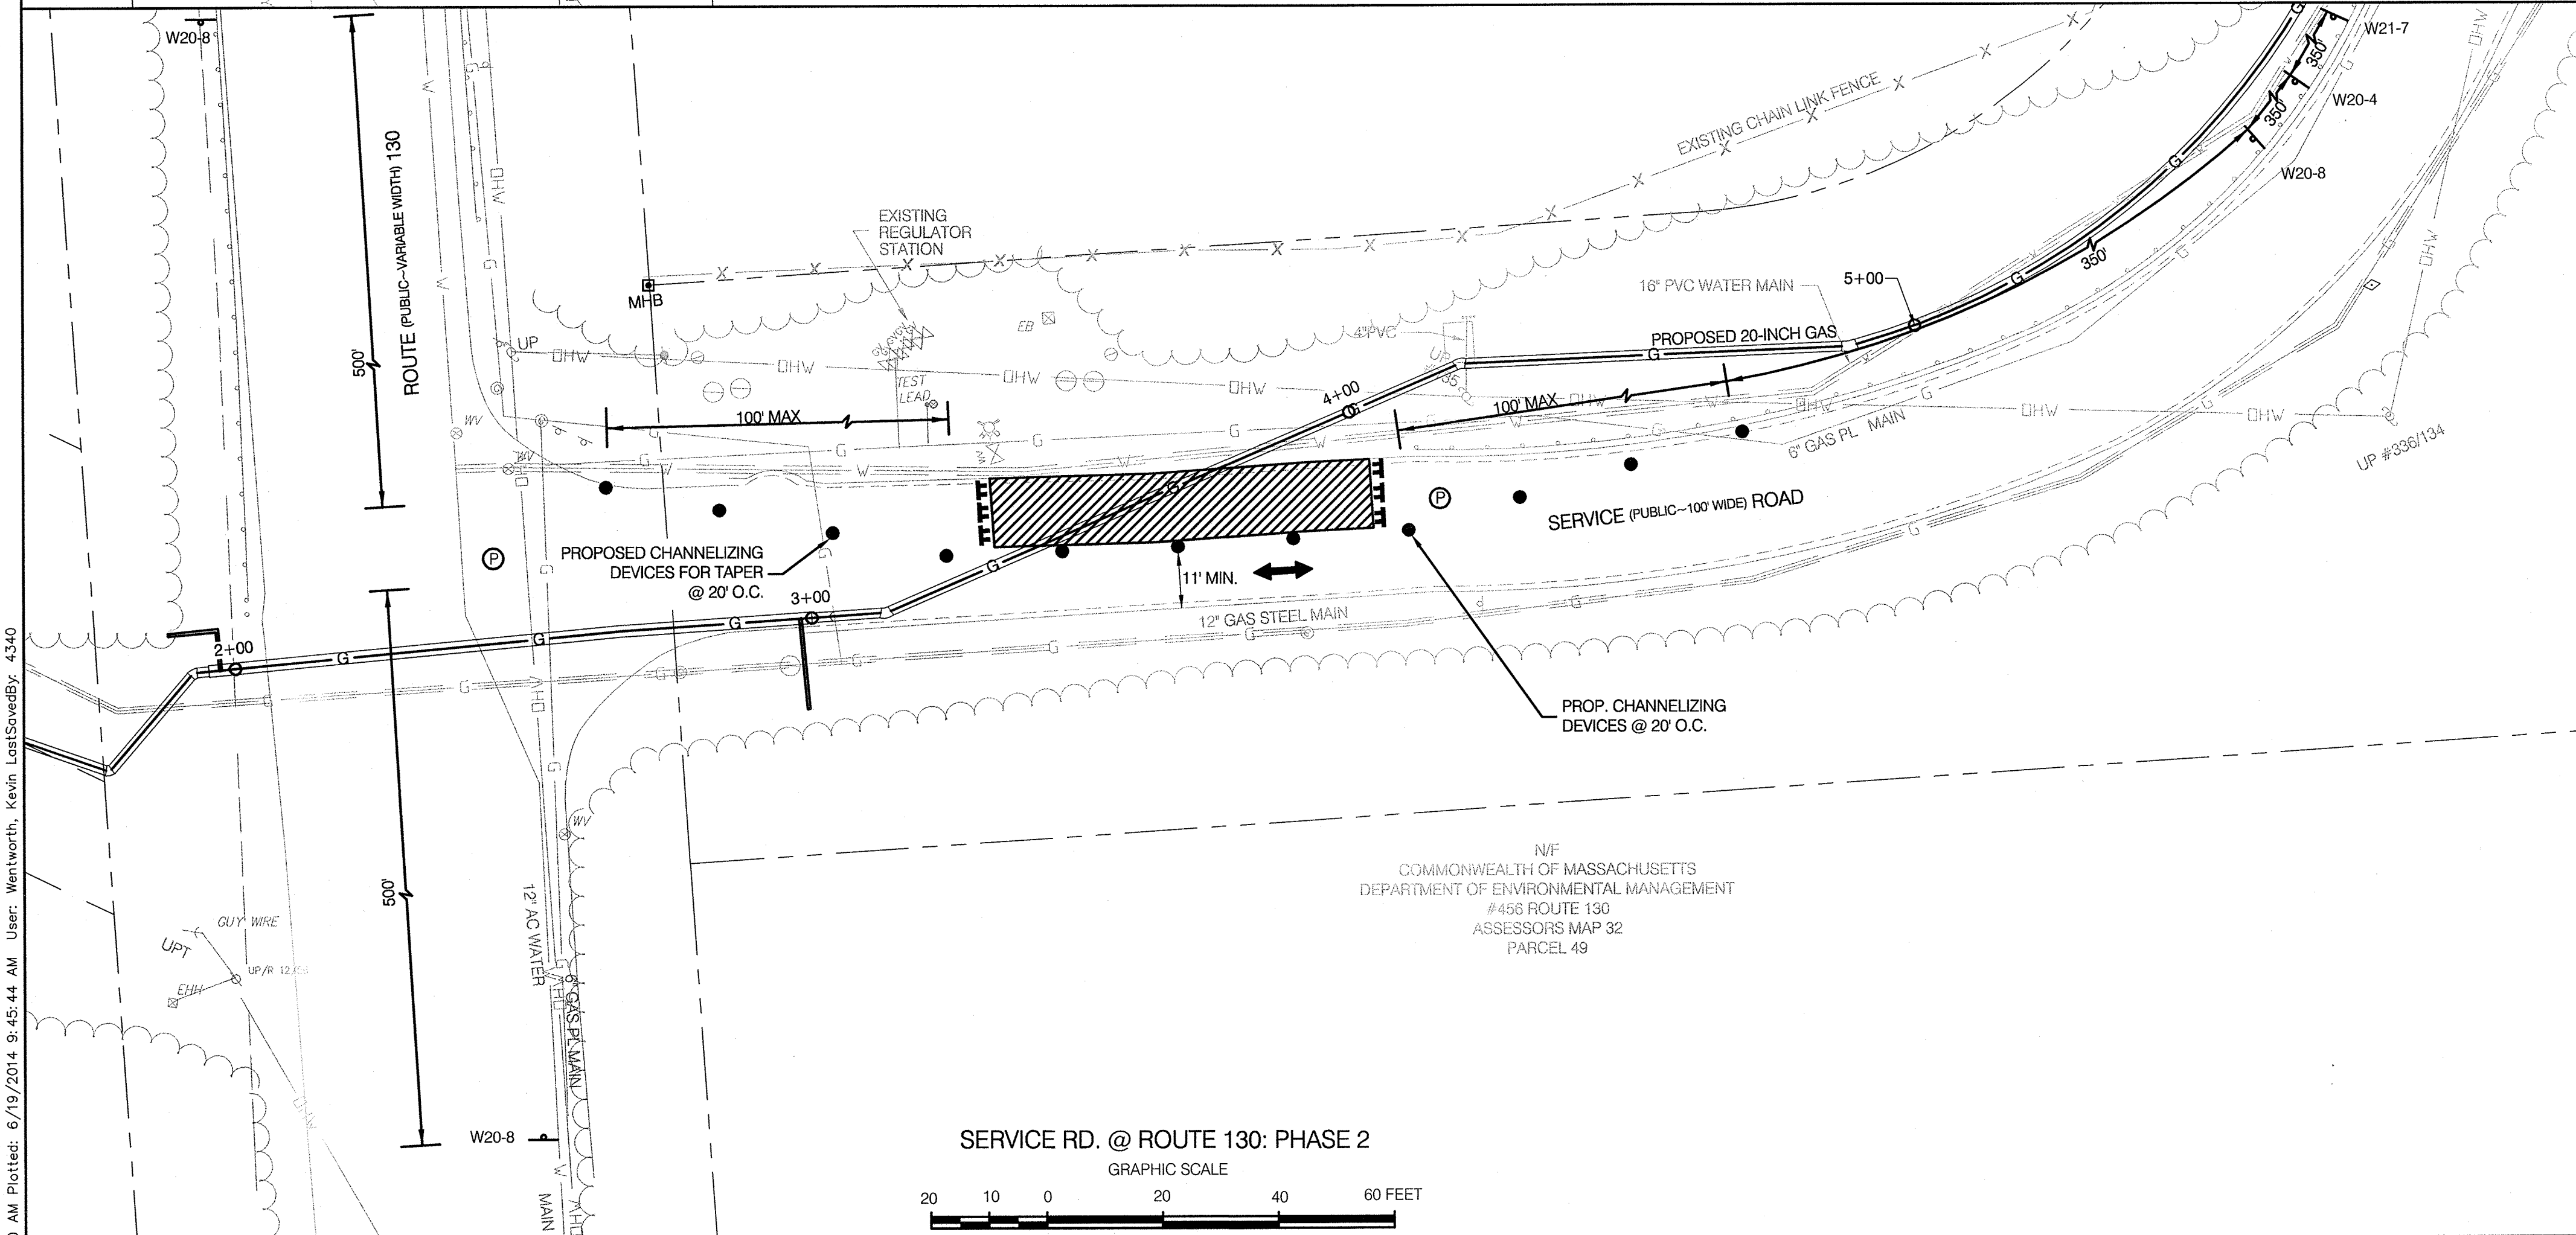

	CHANNELIZING DEVICE
	PROPOSED TRAFFIC FLOW
	TYPE III BARRICADE
	POLICE DETAIL
	CONSTRUCTION SIGN
	WORK ZONE

[illegible]

APPROVED BY	
DATE: SEPTEMBER 7, 2012	MANAGER
NATIONAL GRID SERVICE COMPANY, USA	
15-646.01-TMP-002	

NOTES:

1. WORK ZONES MAY BE REDUCED TO THE LENGTH OF WORK THAT THE CONTRACTOR IS ABLE TO COMPLETE DURING ONE WORK PERIOD.
2. TRAFFIC CONTROL DEVICE SPACING IS BASED ON A 30 MPH SPEED LIMIT.




<u>SIGN DESIGNATION</u>	<u>LEGEND</u>	<u>HEIGHT</u>	<u>WIDTH</u>
W20-4		36"	36"
W20-8		36"	36"



<u>SIGN DESIGNATION</u>	<u>LEGEND</u>	<u>HEIGHT</u>	<u>WIDTH</u>
W21-5a		36"	36"
W21-7		36"	36"

APPROVED BY	
DATE: SEPTEMBER 7, 2012	MANAGER
NATIONAL GRID SERVICE COMPANY, USA	
15-646.01-TMP-003	

TEMPORARY SIGNS

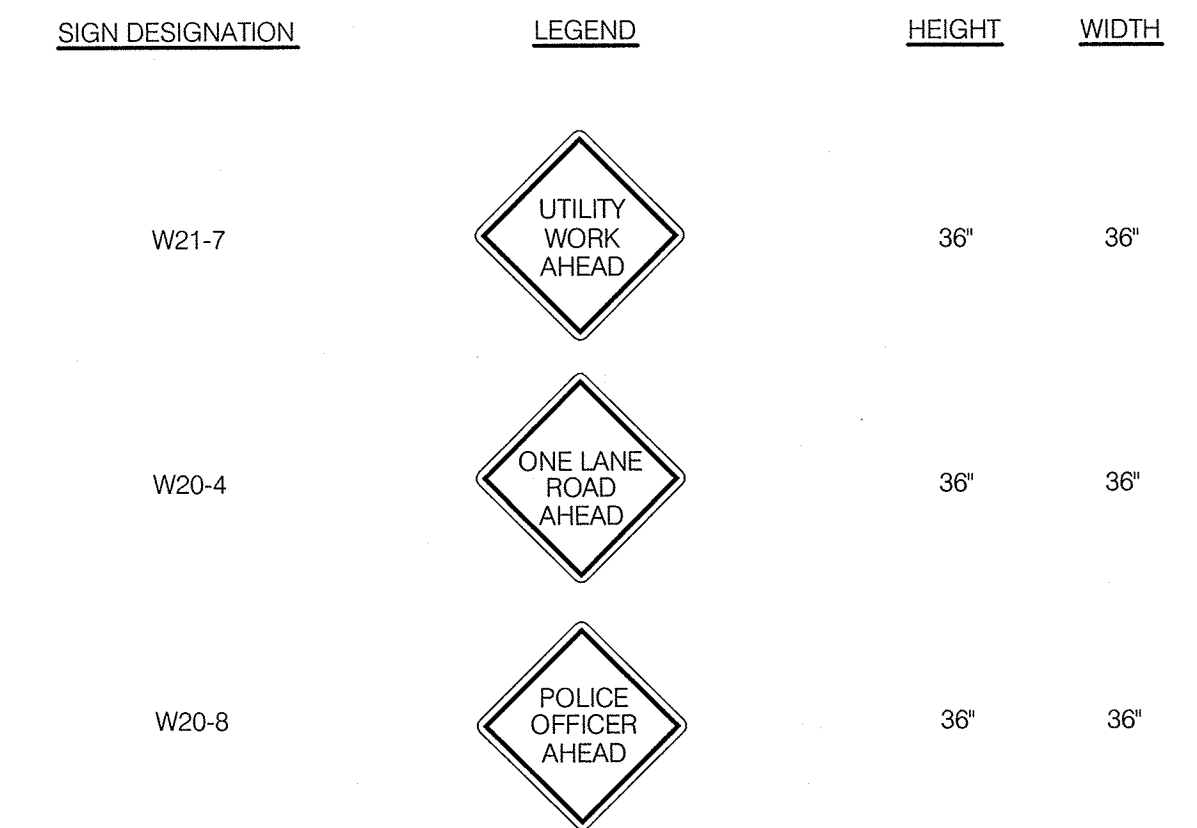

	CHANNELIZING DEVICE
	PROPOSED TRAFFIC FLOW
	TYPE III BARRICADE
	POLICE DETAIL
	CONSTRUCTION SIGN
	WORK ZONE

NOTES:

1. WORK ZONES MAY BE REDUCED TO THE LENGTH OF WORK THAT THE CONTRACTOR IS ABLE TO COMPLETE DURING ONE WORK PERIOD.
2. TRAFFIC CONTROL DEVICE SPACING IS BASED ON A 30 MPH SPEED LIMIT.




Design/Engineering

CHIA

330 Bear Hill Road , Suite 304
Waltham, MA 02451
Main: (781) 982-7650 • www.chacompanies.com



COLONIAL GAS COMPANY
d/b/a
nationalgrid
GAS ENGINEERING DEPARTMENT
40 SYLVAN RD.
WALTHAM, MA 02451

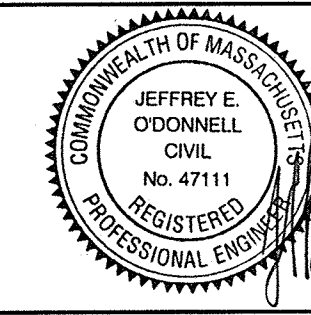

NATIONAL GRID TRAFFIC MANAGEMENT PLANS STREET CROSSINGS SANDWICH, MASSACHUSETTS

APPROVED BY	
DATE: SEPTEMBER 7, 2012	MANAGER
NATIONAL GRID SERVICE COMPANY, USA	
15-646.01-TMP-004	

TOWN OF SANDWICH
BARNSTABLE COUNTY, MASSACHUSETTS

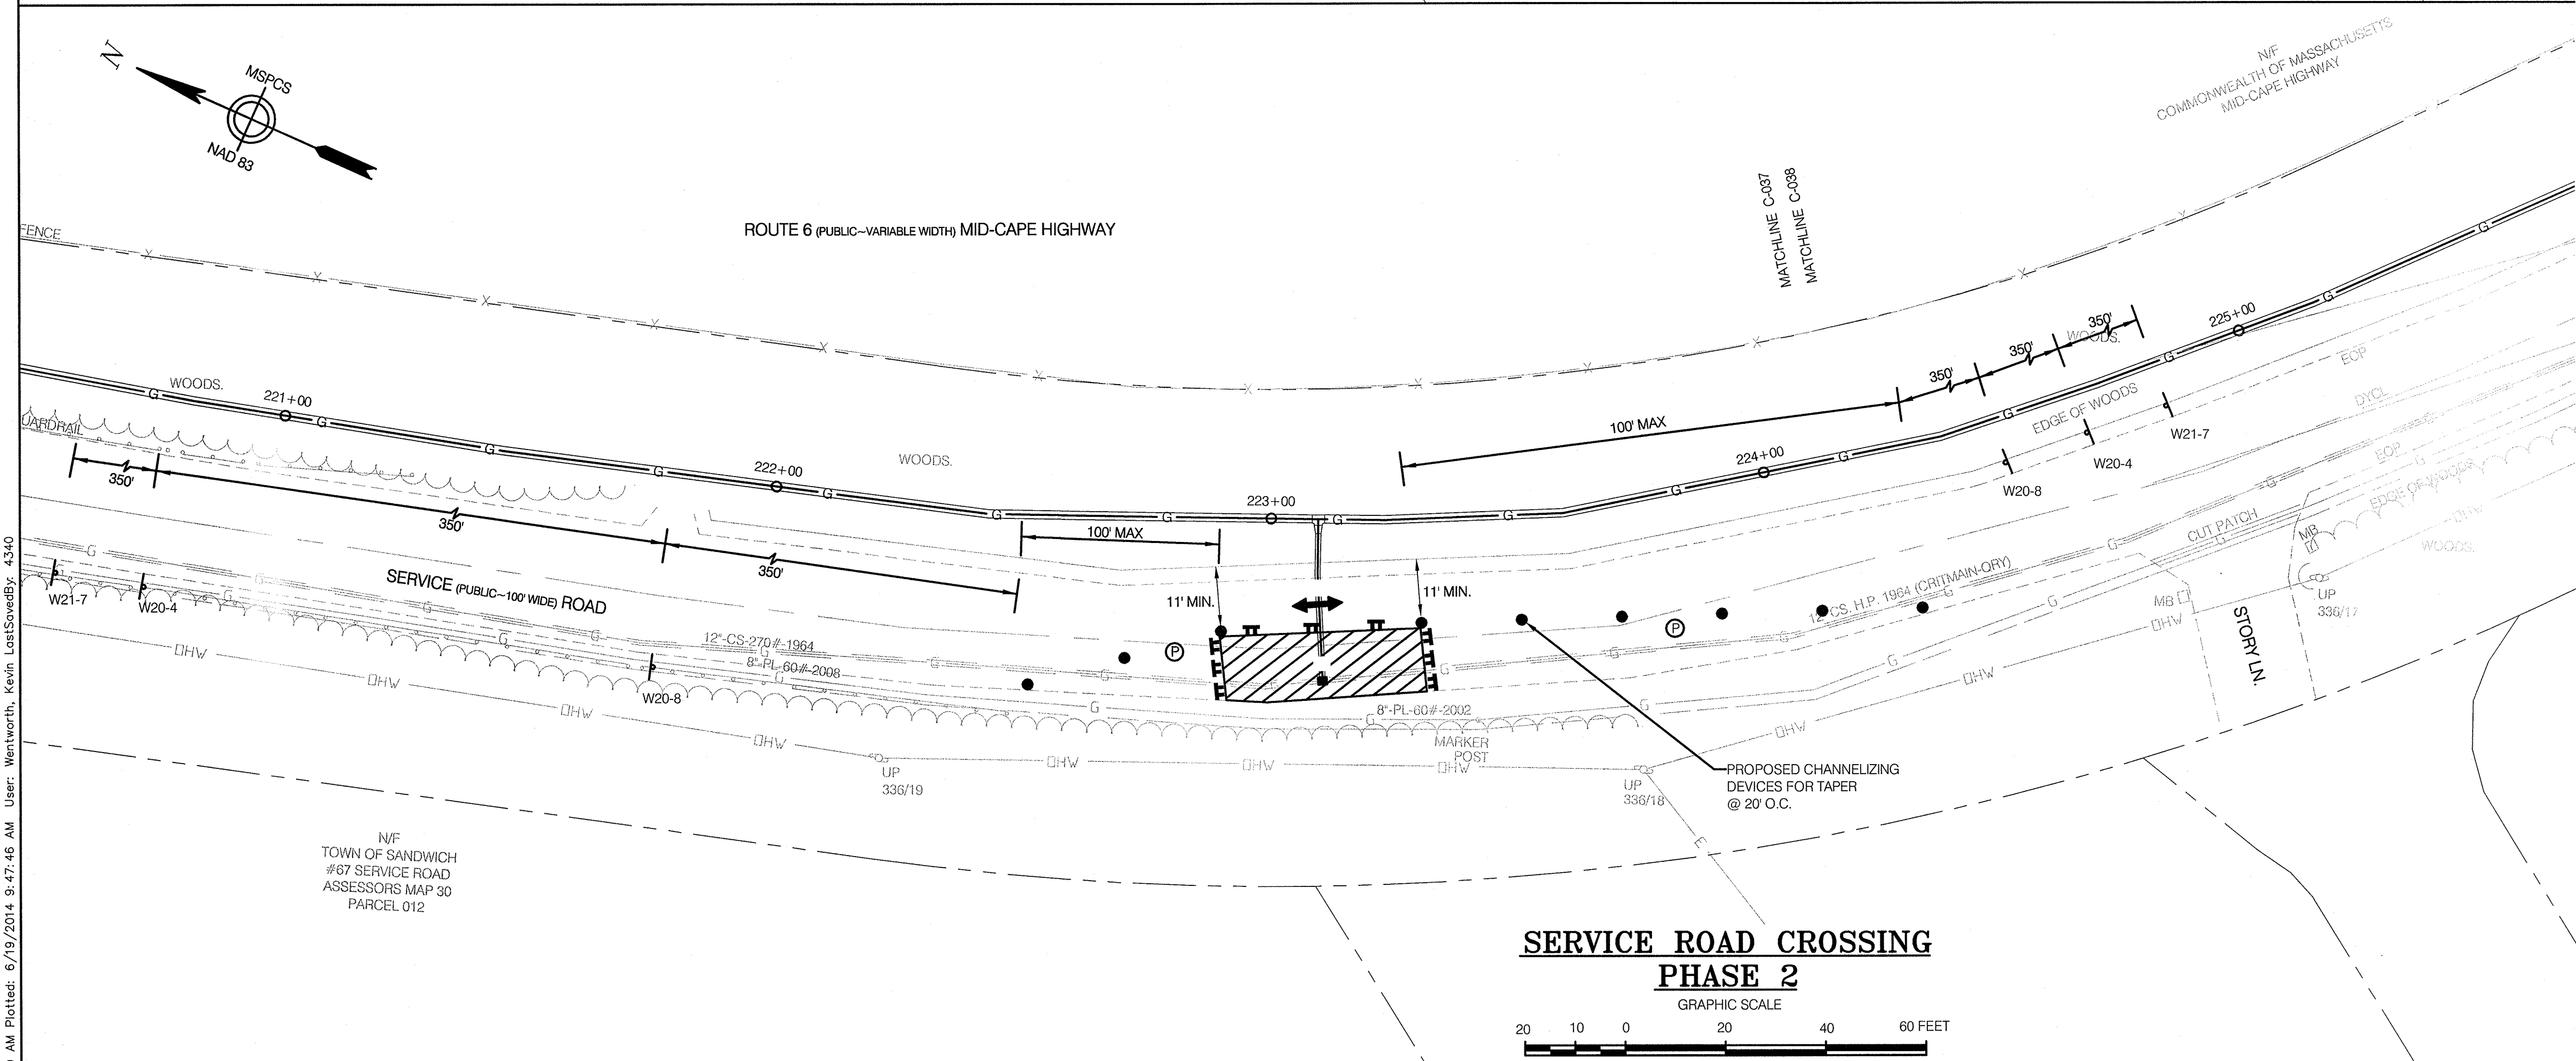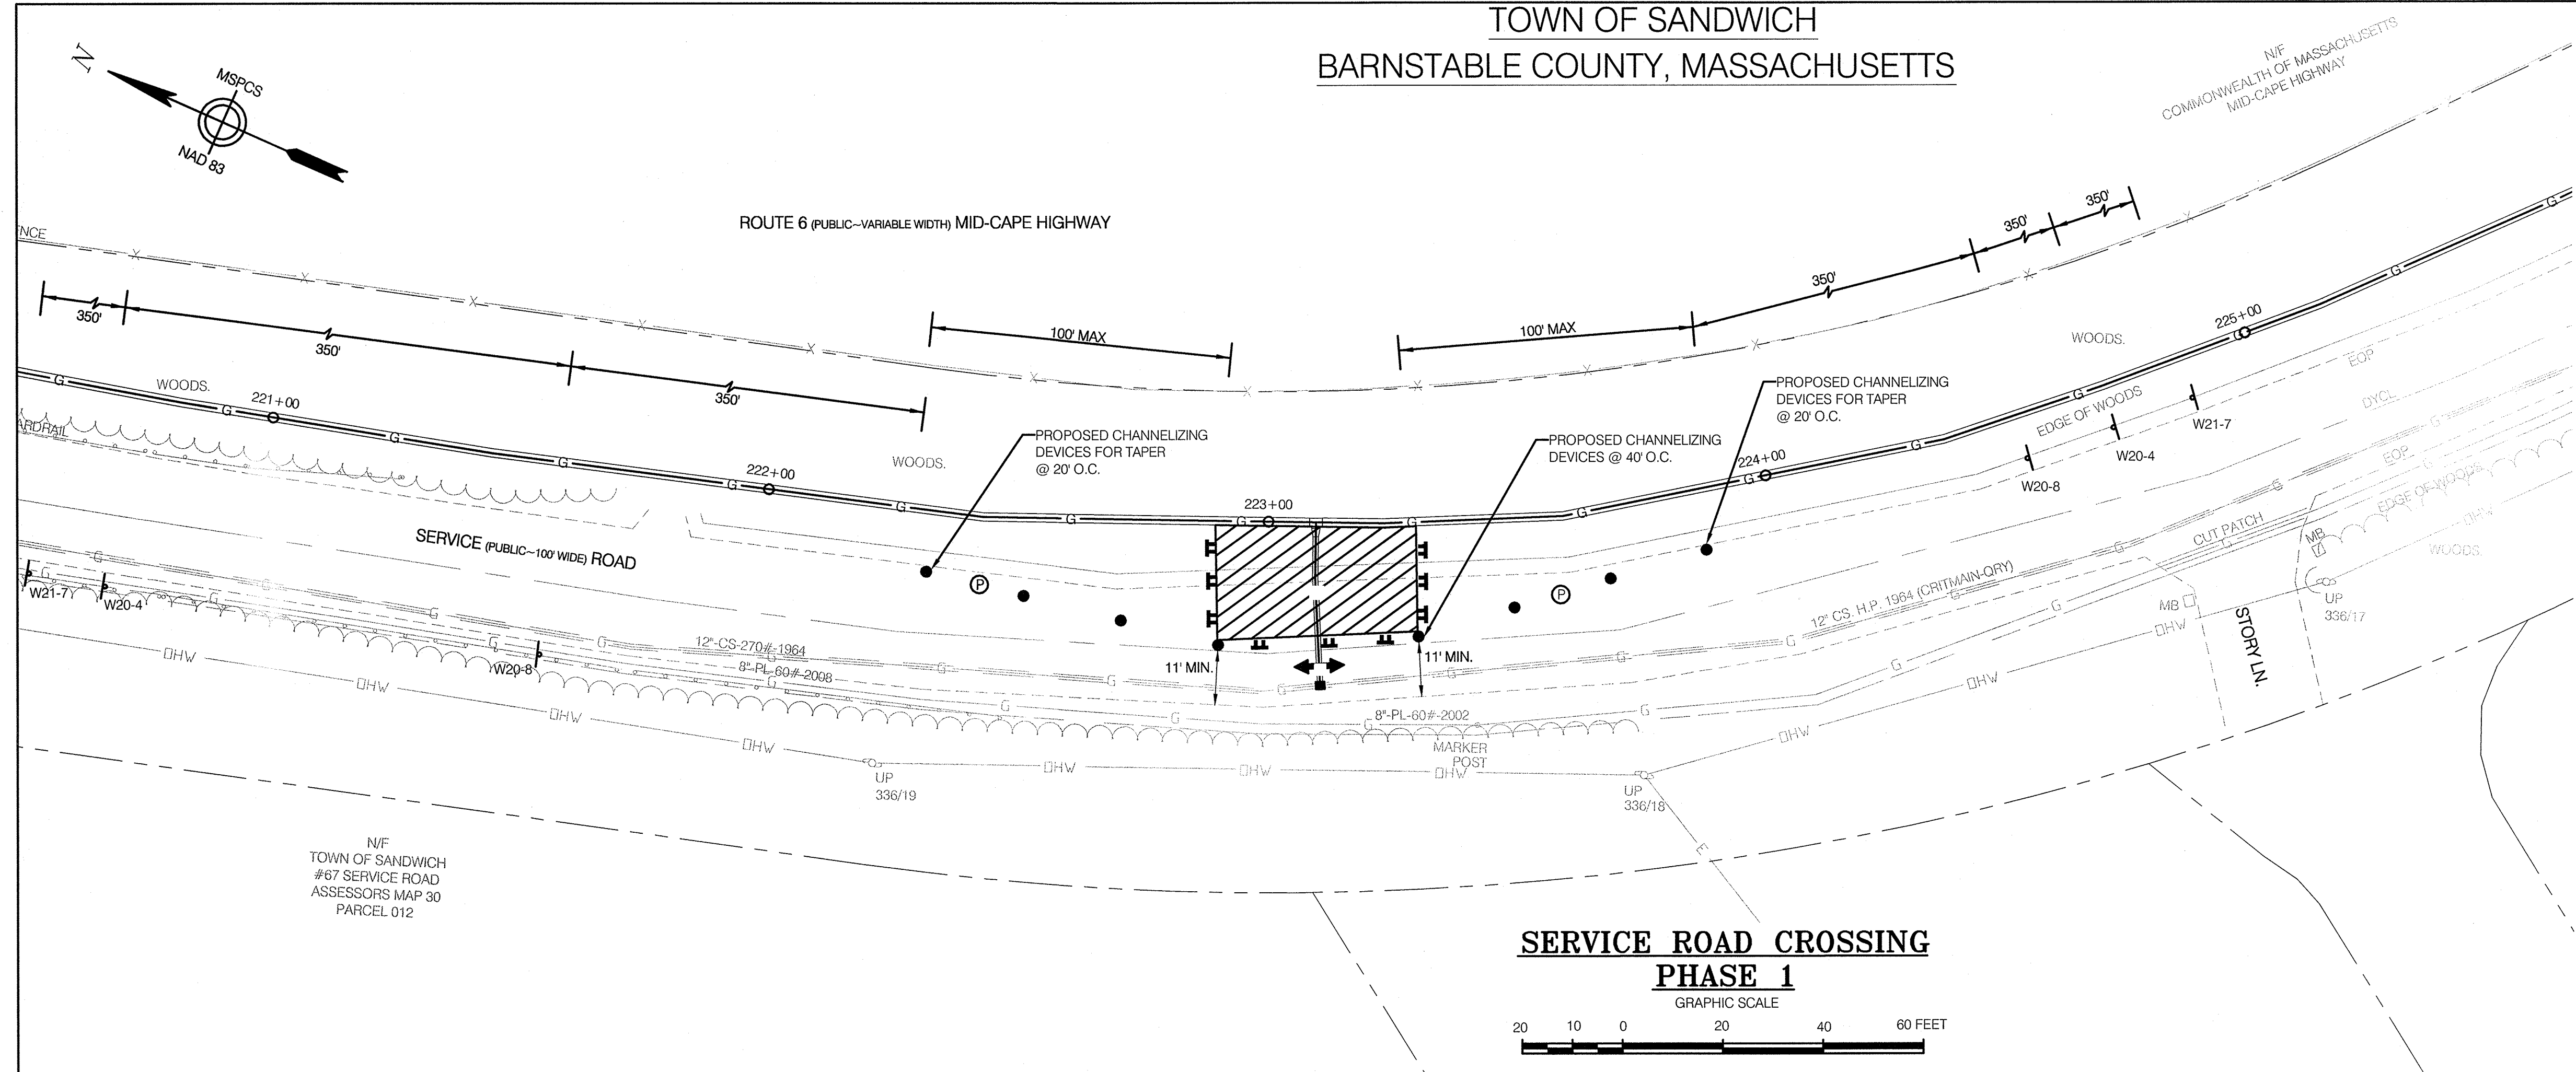

TEMPORARY SIGNS

SIGN DESIGNATION	LEGEND	HEIGHT	WIDTH
W21-7	UTILITY WORK AHEAD	36"	36"
W20-4	ONE LANE ROAD AHEAD	36"	36"
W20-8	POLICE OFFICER AHEAD	36"	36"

LEGEND

- CHANNELIZING DEVICE
- PROPOSED TRAFFIC FLOW
- TYPE III BARRICADE
- POLICE DETAIL
- CONSTRUCTION SIGN
- WORK ZONE

- NOTES:
1. WORK ZONES MAY BE REDUCED TO THE LENGTH OF WORK THAT THE CONTRACTOR IS ABLE TO COMPLETE DURING ONE WORK PERIOD.
 2. TRAFFIC CONTROL DEVICE SPACING IS BASED ON A 30 MPH SPEED LIMIT.

REFERENCE DRAWINGS

DRAWING NO.	TITLE	DRAWING NO.	TITLE

REVISIONS

NO.	DATE	REMARKS	REV.	CKD.	COR.	APP.
0	6/14	REVISED FOR FINAL EFSB APPROVAL	KDW	SAB	KDW	JEO

Design/Engineering

Prepared For:

CHA

330 Bear Hill Road, Suite 304
Waltham, MA 02451
Main: (781) 952-7850 • www.chacompanies.com

COLONIAL GAS COMPANY

d/b/a

nationalgrid

GAS ENGINEERING DEPARTMENT
46 SYLVAN RD.
WALTHAM, MA 02451

COMMONWEALTH OF MASSACHUSETTS

JEFFREY E. O'DONNELL
CIVIL
No. 47111
REGISTERED
PROFESSIONAL ENGINEER

6-14-2014

NATIONAL GRID

TRAFFIC MANAGEMENT PLANS

STREET CROSSINGS

SANDWICH, MASSACHUSETTS

File No.: 15-646.01 TMP.dwg

APPROVED BY



DATE: SEPTEMBER 7, 2012

MANAGER

NATIONAL GRID SERVICE COMPANY, USA

15-646.01-TMP-005

File: W:\NATIONAL GRID\2011 RFP 01\01 SANDWICH\DRAWINGS\15-646.01 TMP.DWG
Saved: 6/19/2014 9:41:00 AM Plotted: 6/19/2014 9:47:46 AM User: Wentworth, Kevin LastSavedBy: 4340

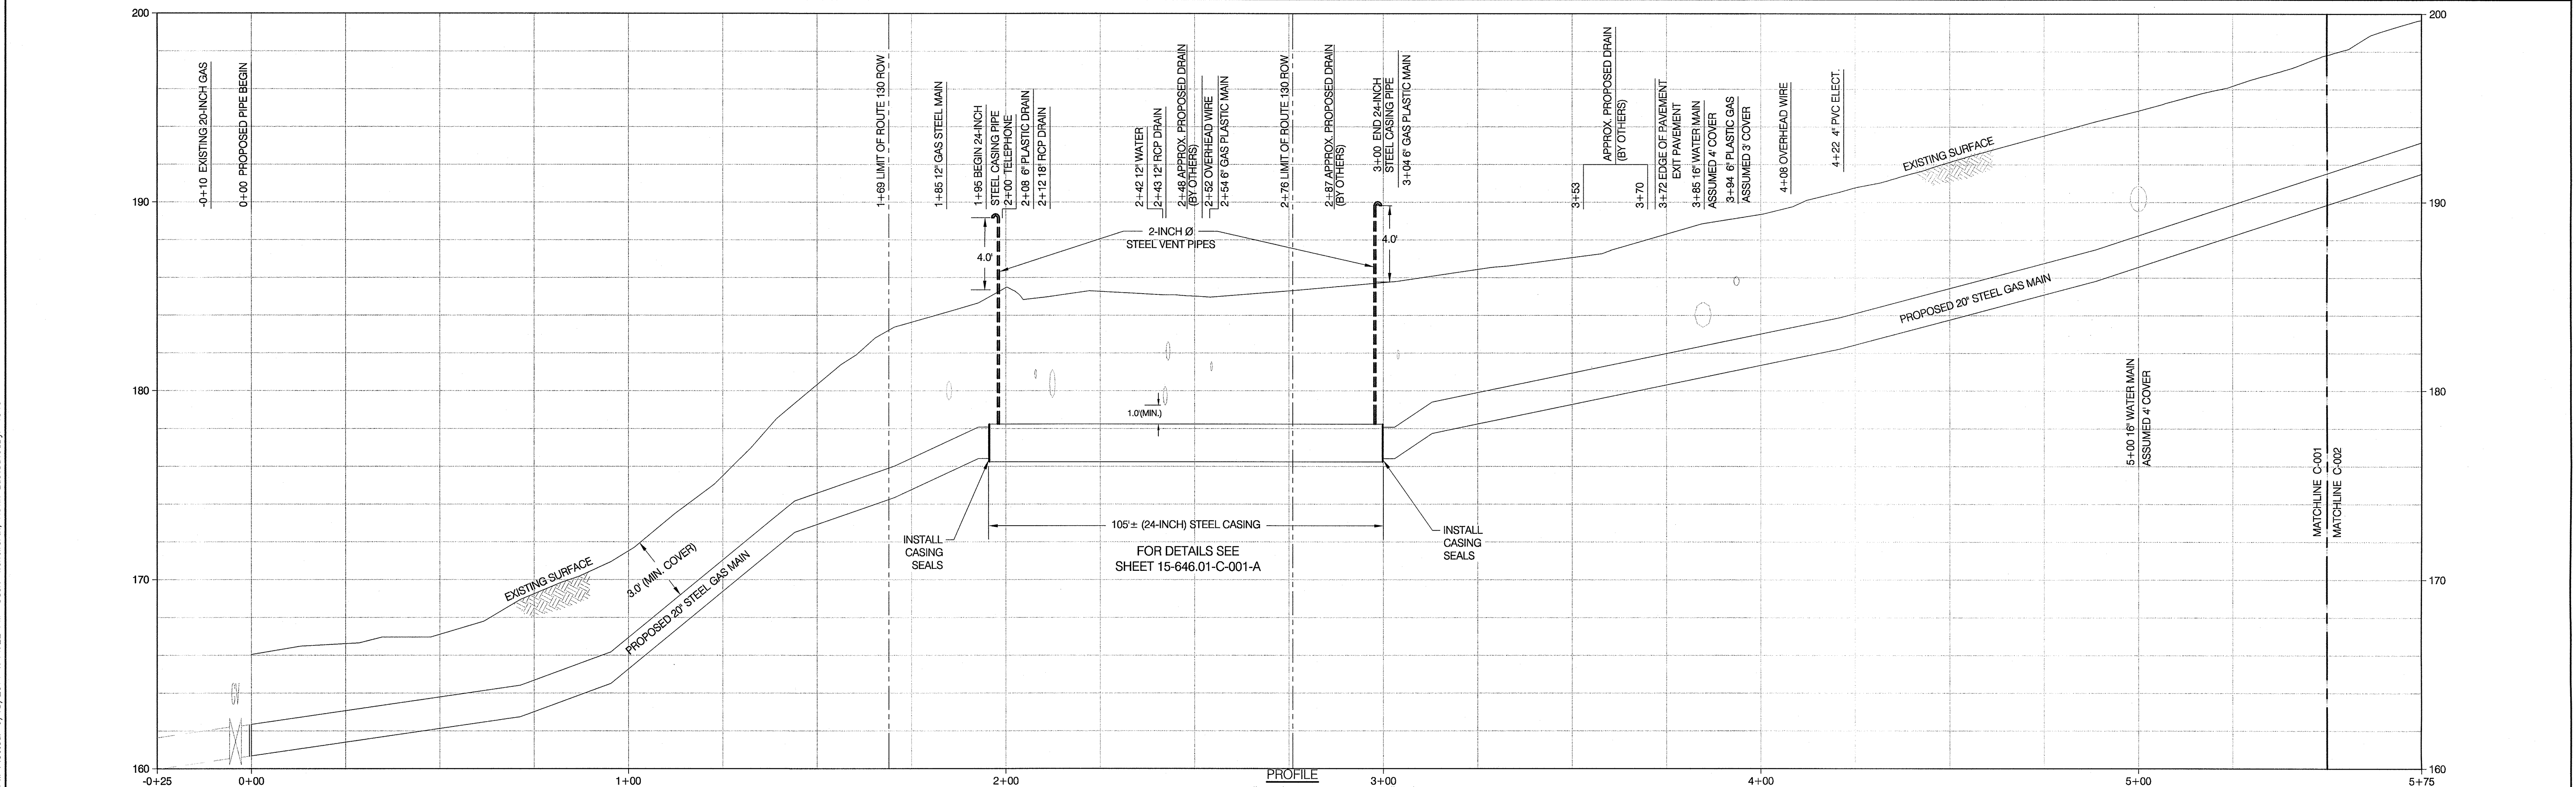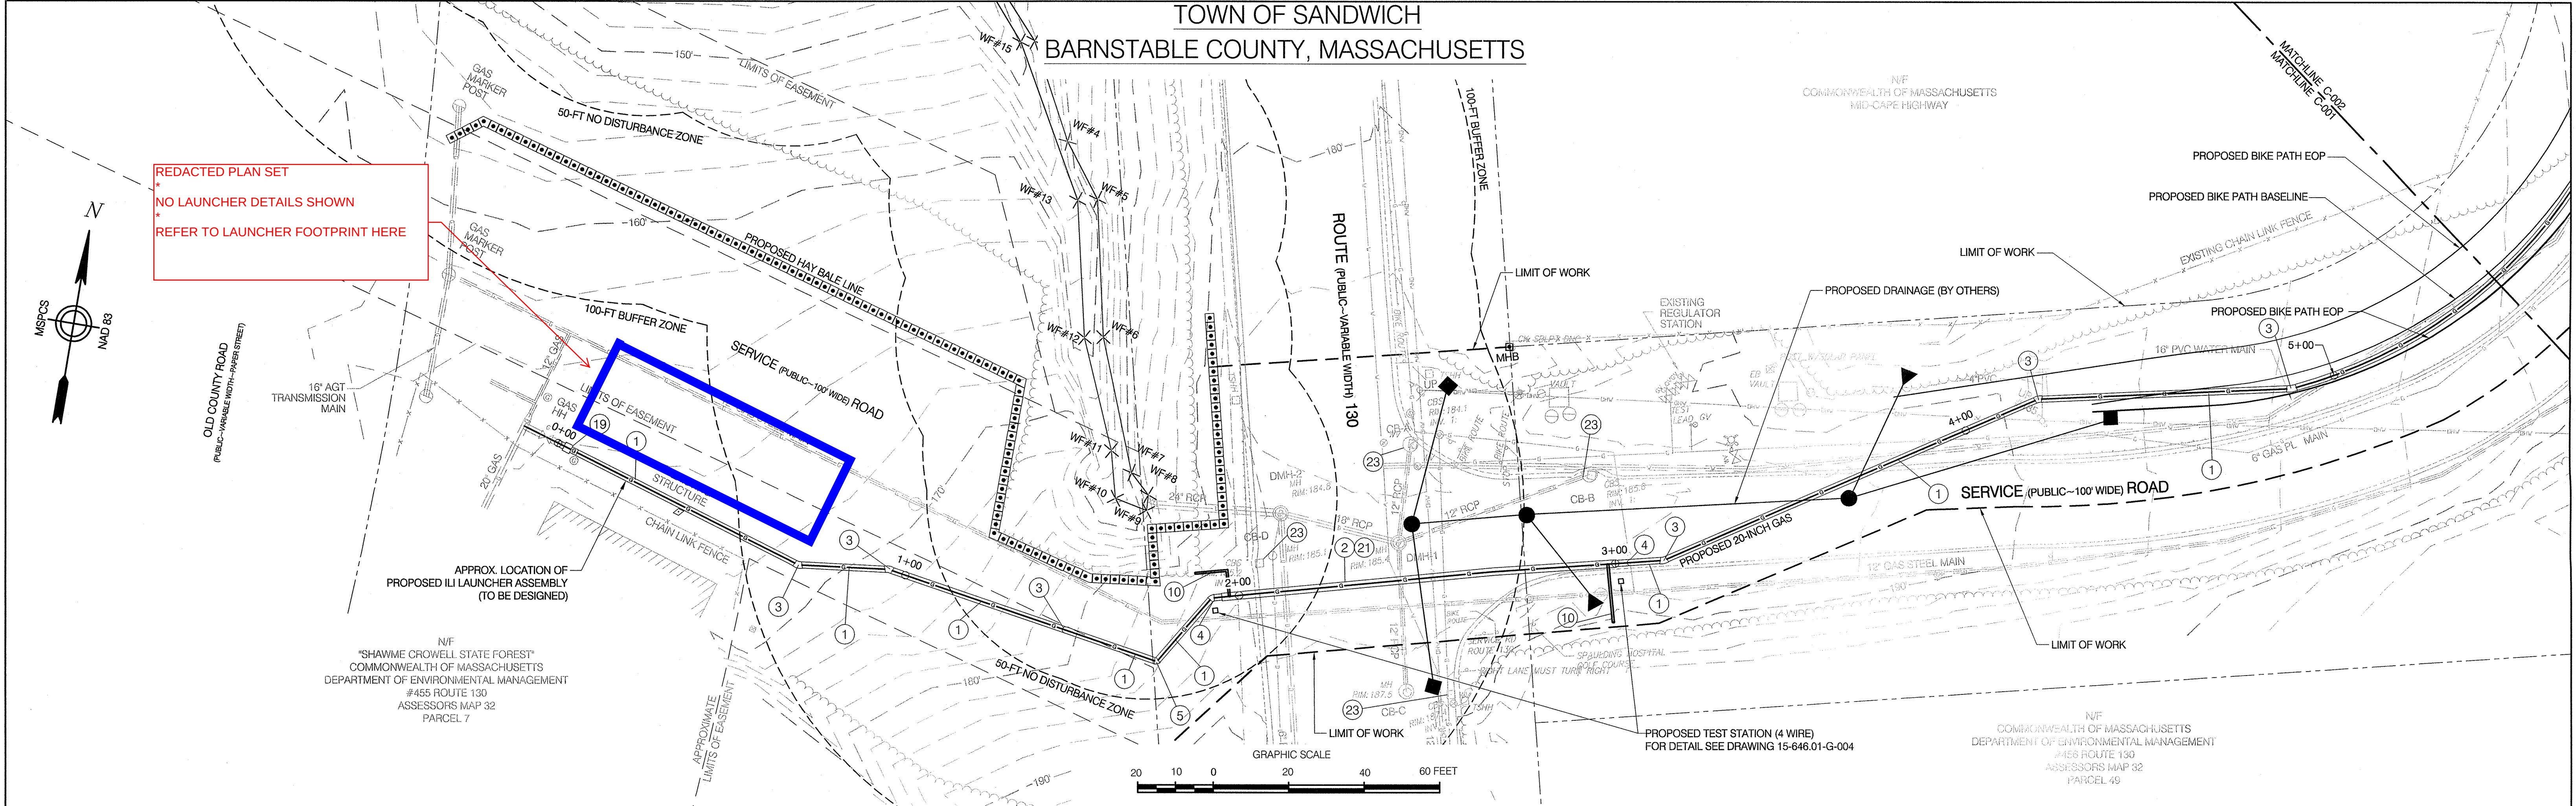

REFERENCE DRAWINGS				REVISIONS							
DRAWING NO.	TITLE	DRAWING NO.	TITLE	NO.	DATE	REMARKS	REV.	OKD.	COR.	APP.	
				0	6/14	REVISED FOR FINAL EFSB APPROVAL	KDW	SAB	KDW	JEO	

330 Bear Hill Road, Suite 304
Waltham, MA 02451
Main: (781) 962-7650 • www.chacompanies.com

DESIGN/ENGINEERING

Prepared For:
COLONIAL GAS COMPANY
d/b/a
nationalgrid
GAS ENGINEERING DEPARTMENT
4920 WILLOW RD.
WALTHAM, MA 02451

JEFFREY E. O'DONNELL
CIVIL
No. 47111
REGISTERED ENGINEER
PROFESSIONAL EXPIRATION
6/19/2014

NATIONAL GRID SERVICE COMPANY, USA
SERVICE ROAD ALIGNMENT
SANDWICH, MA
BARNSTABLE COUNTY, MASSACHUSETTS
File No.: 15-646.01 ALIGN.dwg

APPROVED BY
DATE: SEPTEMBER 7, 2012
MANAGER
NATIONAL GRID SERVICE COMPANY, USA
15-646.01-C-001

1. SITE DETAIL SHOWN HEREON IS BASED UPON TOPOGRAPHIC DETAIL SURVEY CONDUCTED BY COLER & COLANTONIO, INC. IN JULY 2011, BY CHA INC. IN MARCH 2014 AND DETAIL SURVEY PROVIDED BY BSC.

2. PROPERTY LINES SHOWN HEREON ARE BASED ON TAX MAP LOCATION AND DO NOT REPRESENT A PROPERTY LINE RETRACEMENT SURVEY EFFORT.

3. LOCATION OF ANY IDENTIFIED UNDERGROUND UTILITIES IS APPROXIMATE ONLY, AND IS NOT WARRANTED TO BE CORRECT. ADDITIONAL UTILITIES MAY EXIST WHICH ARE NOT INDICATED ON THESE PLANS. ALL EXISTING UTILITIES SHALL BE VERIFIED BY THE CONTRACTOR FOR SERVICE, SIZE, INVERT ELEVATIONS, LOCATION, ETC. CONTRACTOR MUST NOTIFY DIG-SAFE AT 1-888-344-7233 AT LEAST 72 HOURS PRIOR TO ANY CONSTRUCTION.

4. SURVEY WAS CONDUCTED IN MASSACHUSETTS MAINLAND ZONE 2001, NAD83 HORIZONTAL COORDINATE SYSTEM. ELEVATIONS ARE BASED ON NAVD 1988, US SURVEY FEET. ELEVATIONS WERE TRANSFERRED TO THIS SITE VIA STATIC GPS SURVEY METHODS AND REFERENCED TO TEMPORARY BENCHMARKS AS SHOWN ON THE PLAN.

5. THE PURPOSE OF THIS PLAN IS TO IDENTIFY TO THE APPROPRIATE PERMITTING AGENCY THE PROPOSED LOCATION FOR A GAS PIPELINE AND ITS LOCATION RELATIVE TO EXISTING UTILITIES WITHIN THE LIMITS OF A ROAD RIGHT-OF-WAY, INCLUDING ELEVATION INFORMATION WHERE OBTAINABLE.

6. THE PROPOSED 20-INCH STEEL PIPE ROAD CROSSING WILL BE CONSTRUCTED VIA PIPE JACKING CONSTRUCTION METHODS.



7. ALL CONSTRUCTION SIGNING, DRUMS, BARRICADES AND OTHER DEVICES SHALL CONFORM WITH PART VI OF THE 2003 MANUAL ON UNIFORM TRAFFIC CONTROL DEVICES (M.U.T.C.D.) REVISION 3 AND AS AMENDED.

8. ALL VEHICLES ARE TO BE HIGHLY VISIBLE USING ROTATING BEACONS AND BE MARKED BY USE OF TRAFFIC CONES.

9. NATIONAL GRID SHALL NOTIFY EACH ABUTTER AT LEAST 48 HOURS IN ADVANCE OF THE START OF ANY WORK THAT WILL REQUIRE THE TEMPORARY OBSTRUCTION OF ACCESS.

10. BACKFILL MATERIAL WILL CONSIST OF SUITABLE EXCAVATED MATERIAL COMPACTED.

11. BLASTING NOT PERMITTED.

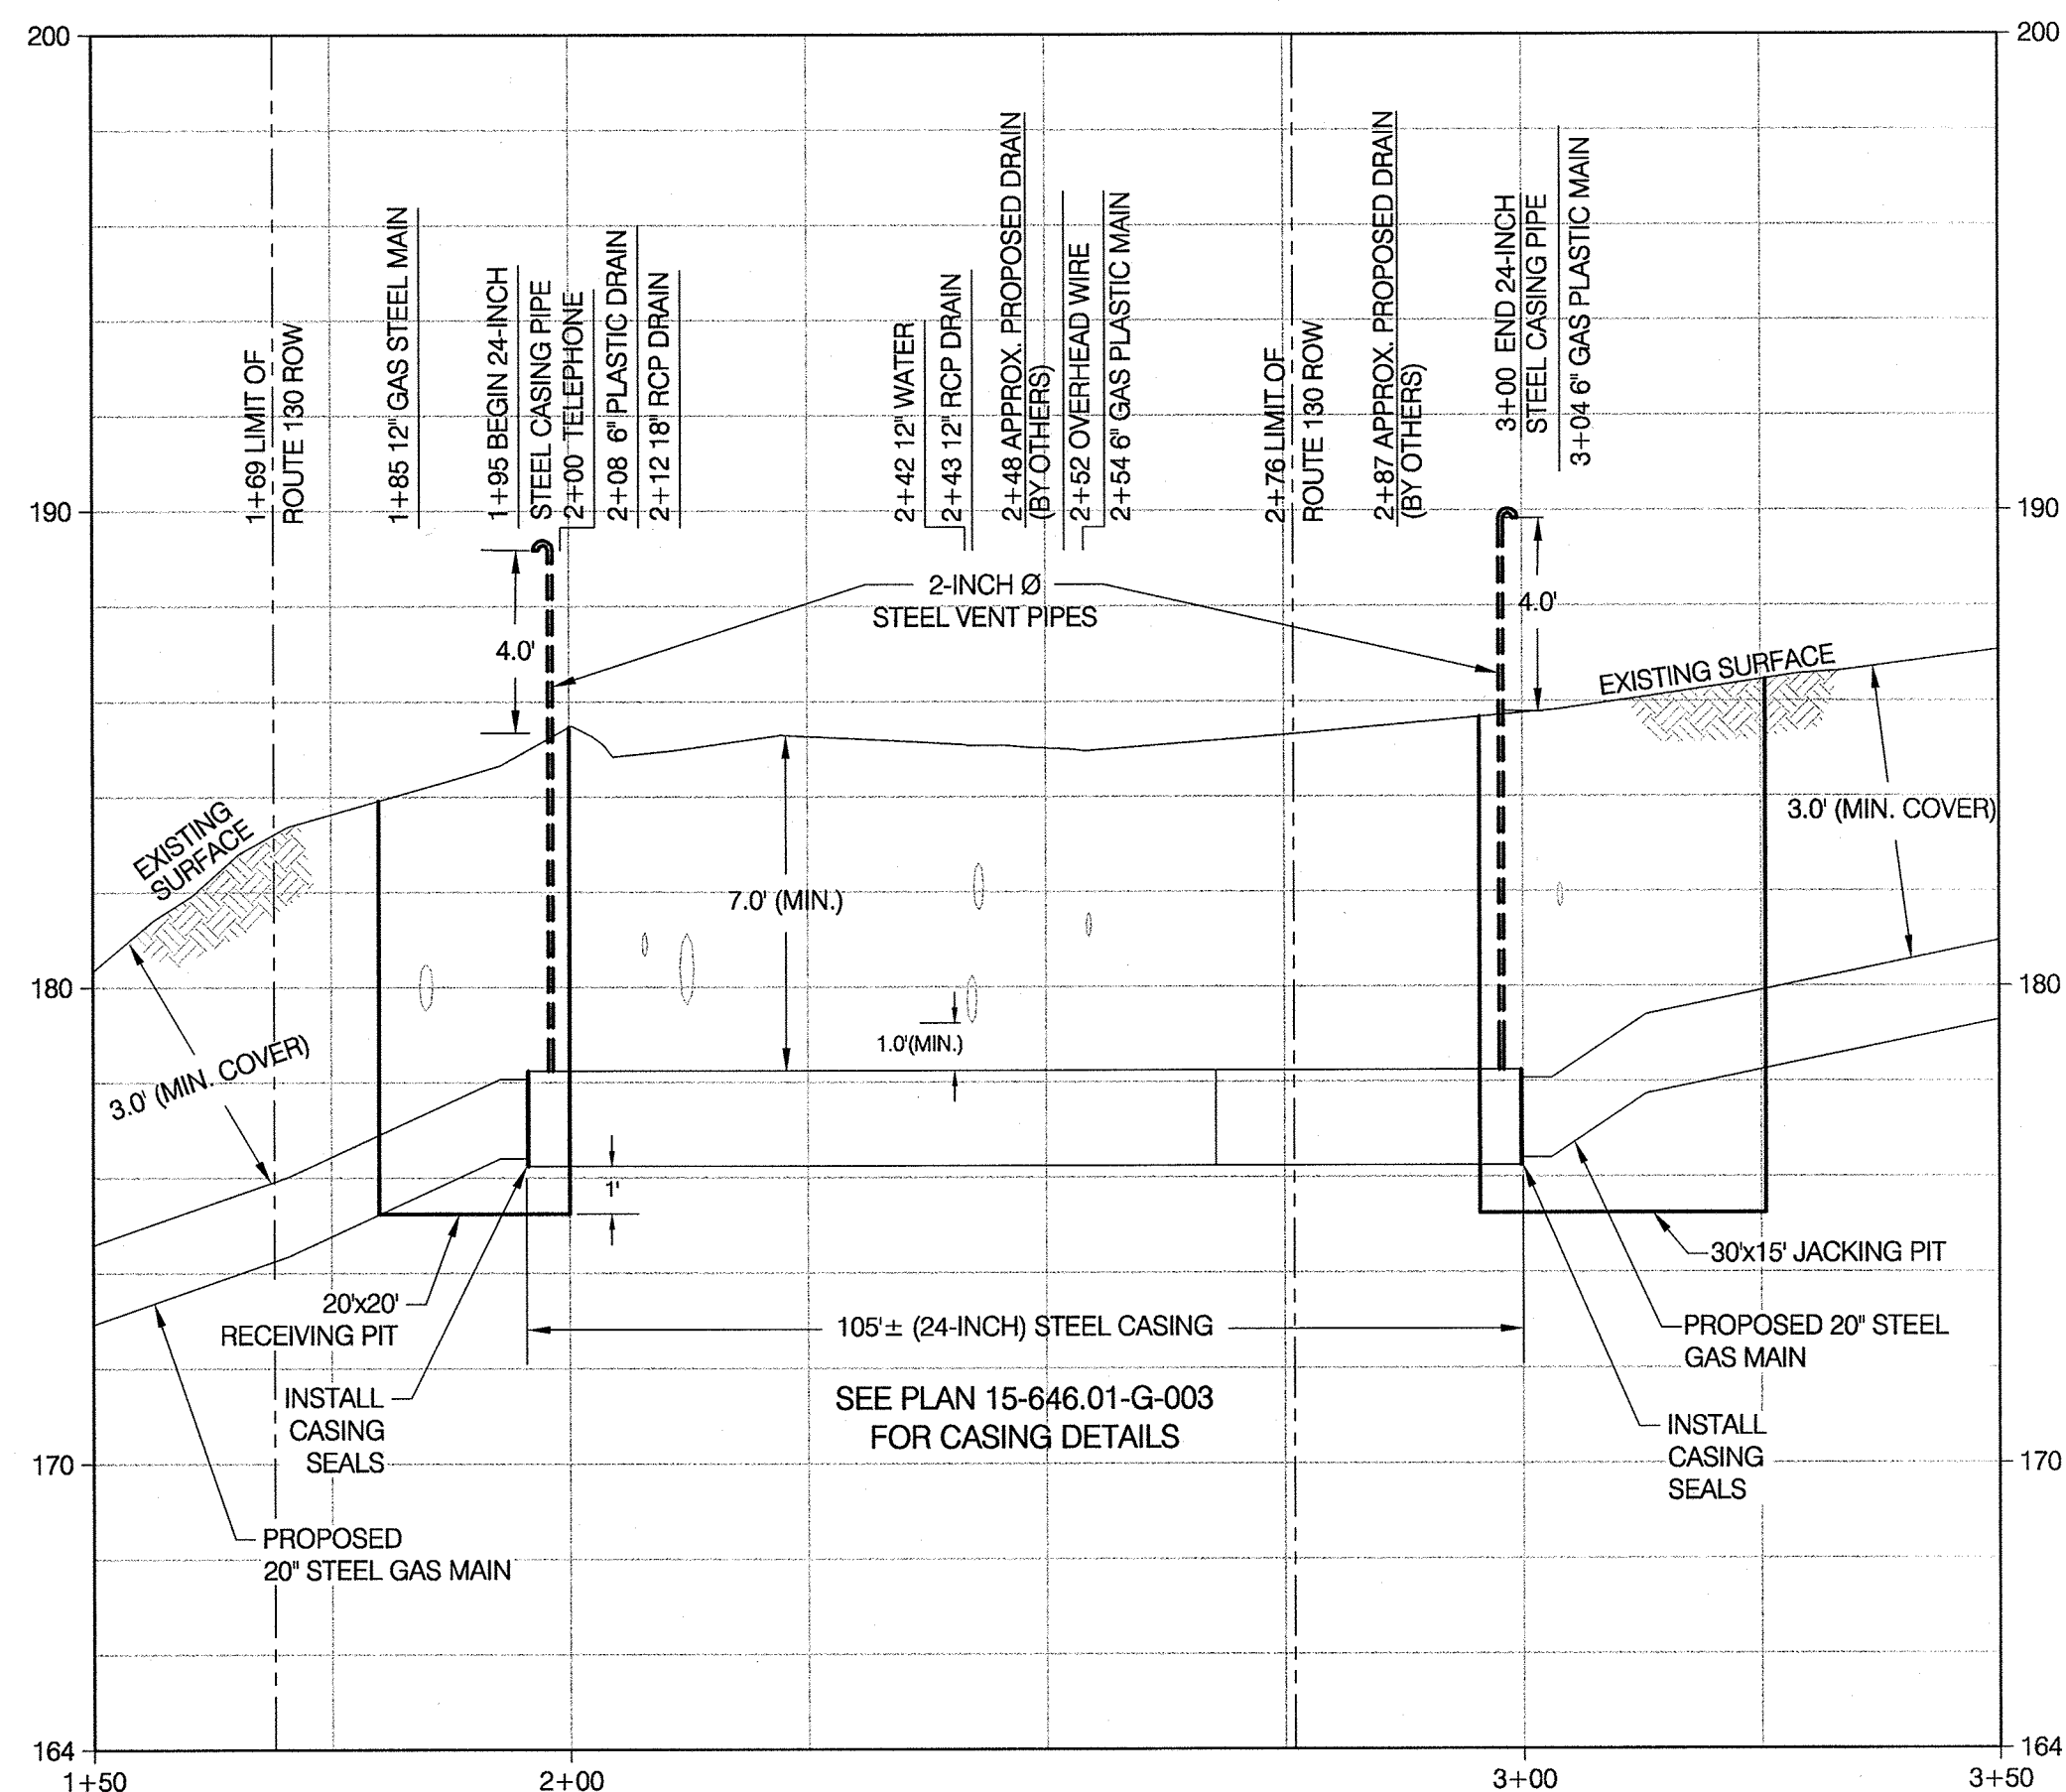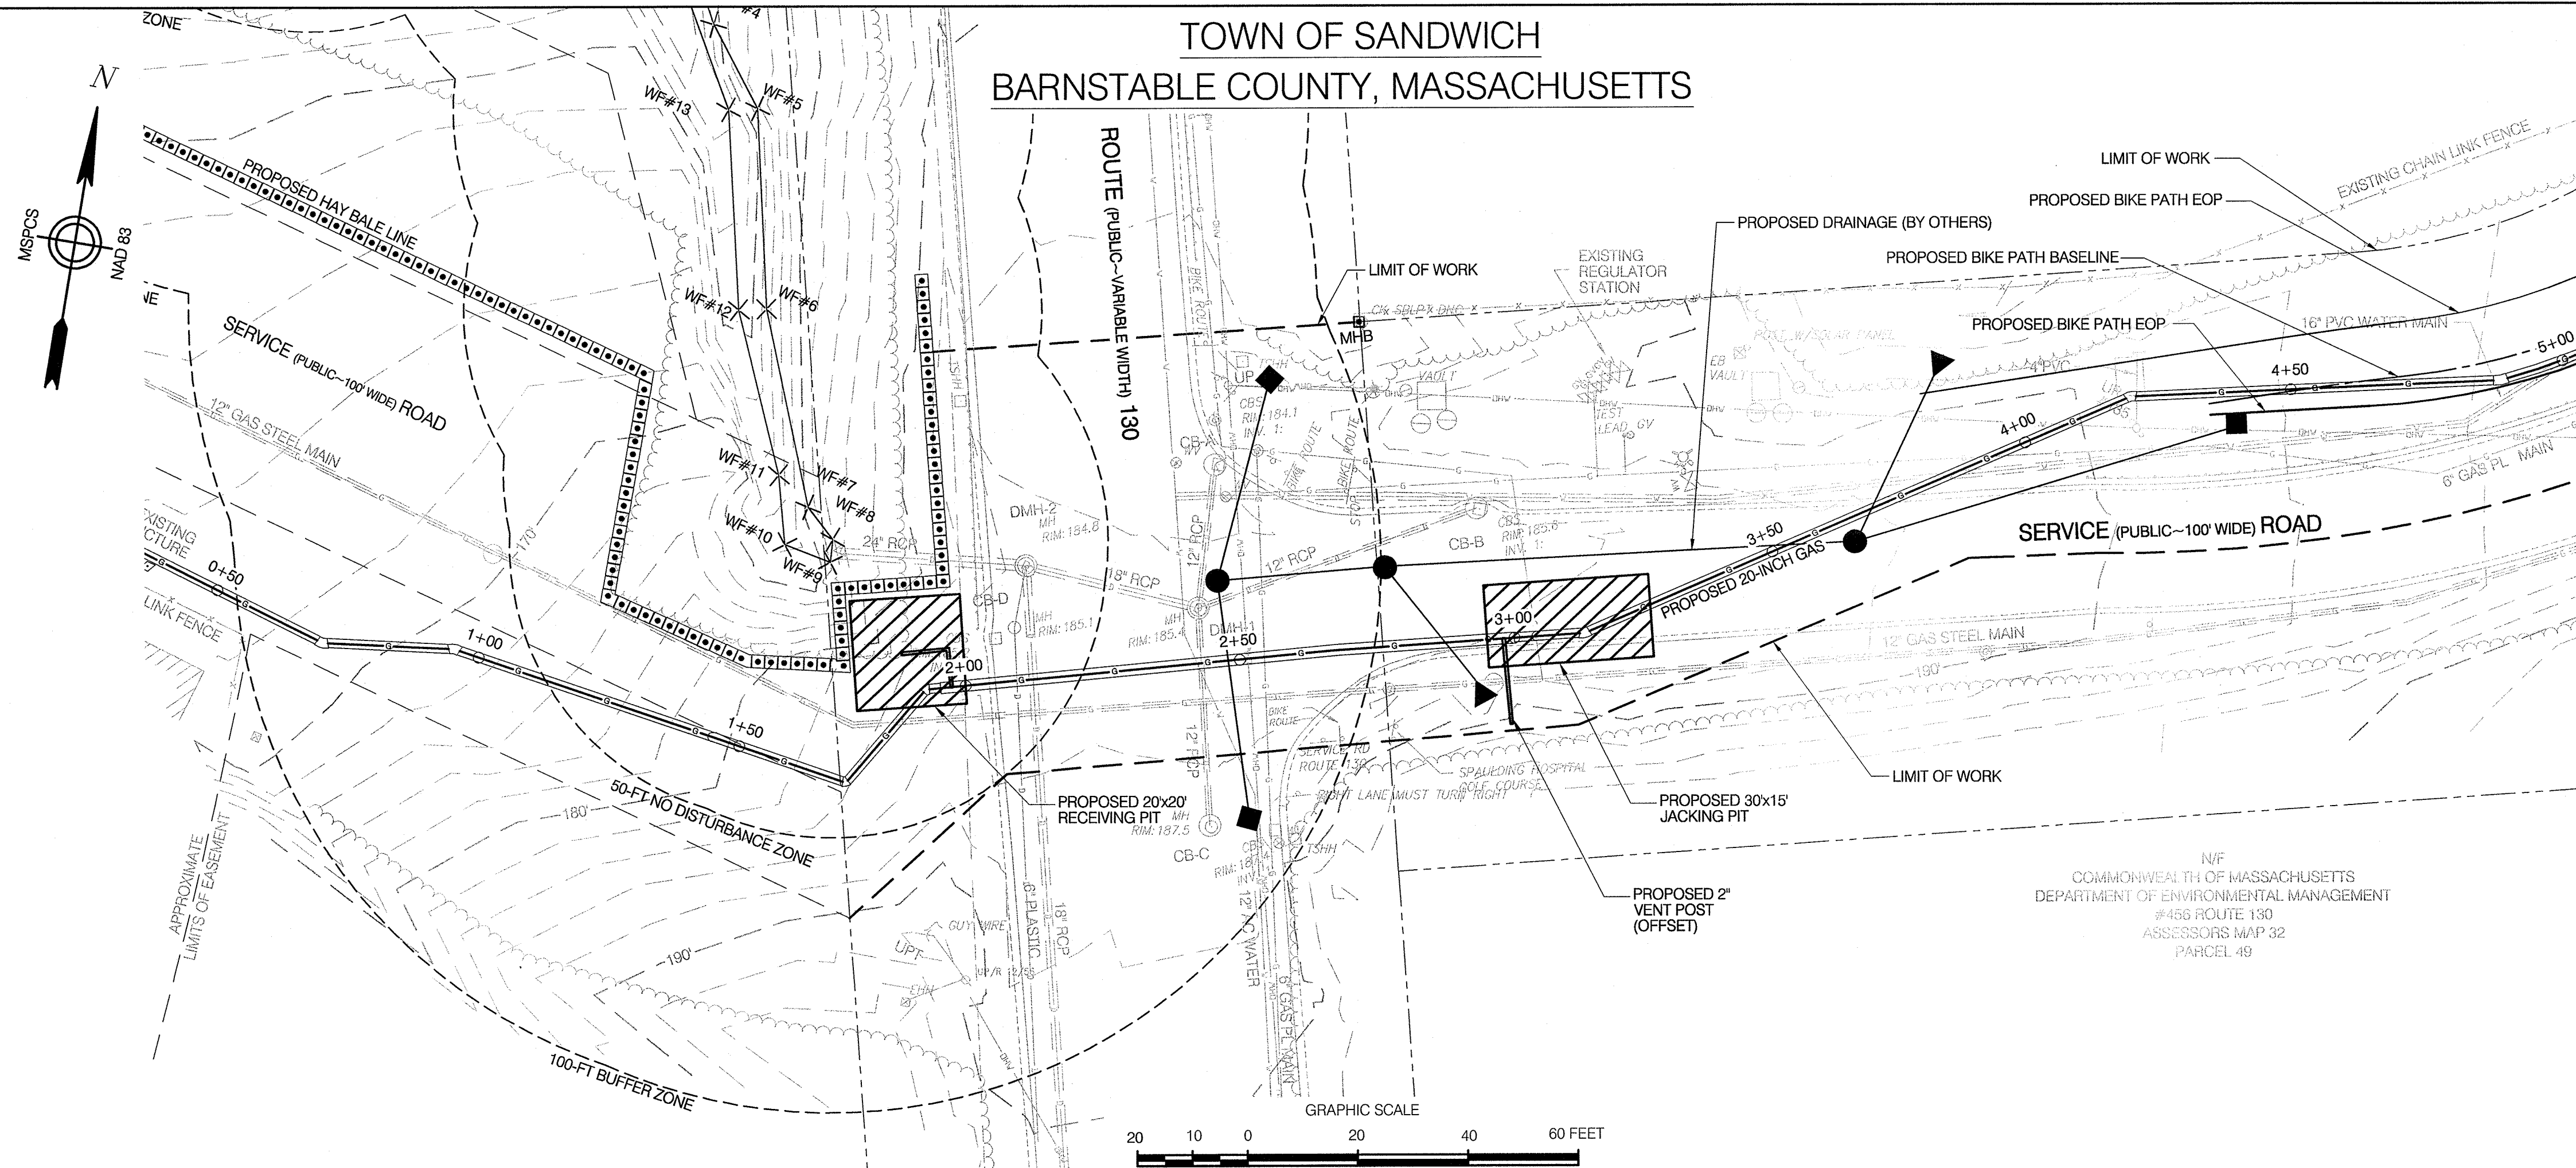

PROFILE
HOR. SCALE: 1"=20'
VER. SCALE: 1"=5'

1. THE CONTRACTOR SHALL SUBMIT DETAILS OF THE METHOD OF INSTALLATION AND THE SHEETING AND BRACING SYSTEM TO NATIONAL GRID AND ALL APPROPRIATE JURISDICTIONAL AUTHORITIES FOR APPROVAL.
2. UNLESS OTHERWISE ORDERED BY NATIONAL GRID, JACKING OPERATIONS SHALL BE CONTINUOUS AND WITHOUT INTERRUPTION.
3. SHEETING TO EXTEND 4' ABOVE ORIGINAL GROUND ON ALL SIDES FACING TRAFFIC AND MINIMUM 10' RETURN ON SIDES UNLESS OTHERWISE NOTED ON THE DRAWINGS.
4. THE CONTRACTOR SHALL PROVIDE A 4' HIGH SAFETY FENCE AROUND ALL PITS.
5. THE JACKING AND RECEIVING PITS SHALL BE GRANULAR FILL AND COMPACTED WITH SUITABLE BACKFILL MATERIAL 6" OVER THE TOP OF THE PIPE. THE REMAINDER OF THE BACKFILL SHALL BE SUITABLE EXCAVATED MATERIAL.
6. DO NOT INTERRUPT FLOW OF TRAFFIC DURING WORK.

[illegible]

Design/Engineering


Prepared For:



330 Bear Hill Road, Suite 304
Waltham, MA 02451
Main: (781) 982-7650 • www.chacompanies.com

COLONIAL GAS COMPANY
d/b/a
nationalgrid

GAS ENGINEERING DEPARTMENT
40 SYLVAN RD.
WALTHAM, MA 02451

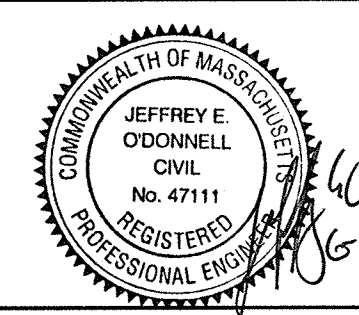

NATIONAL GRID
PROPOSED 20-INCH GAS MAIN
ROUTE 130 CROSSING DETAIL
SANDWICH, MASSACHUSETTS

File No.: 15-646.01 JACK & BORE DETAILS.dwg

APPROVED BY _____


DATE: SEPTEMBER 24, 2012

MANAGER

NATIONAL GRID SERVICE COMPANY, USA

15-646.01-C-001A

N/F
COMMONWEALTH OF MASSACHUSETTS
MID-CAPE HIGHWAY

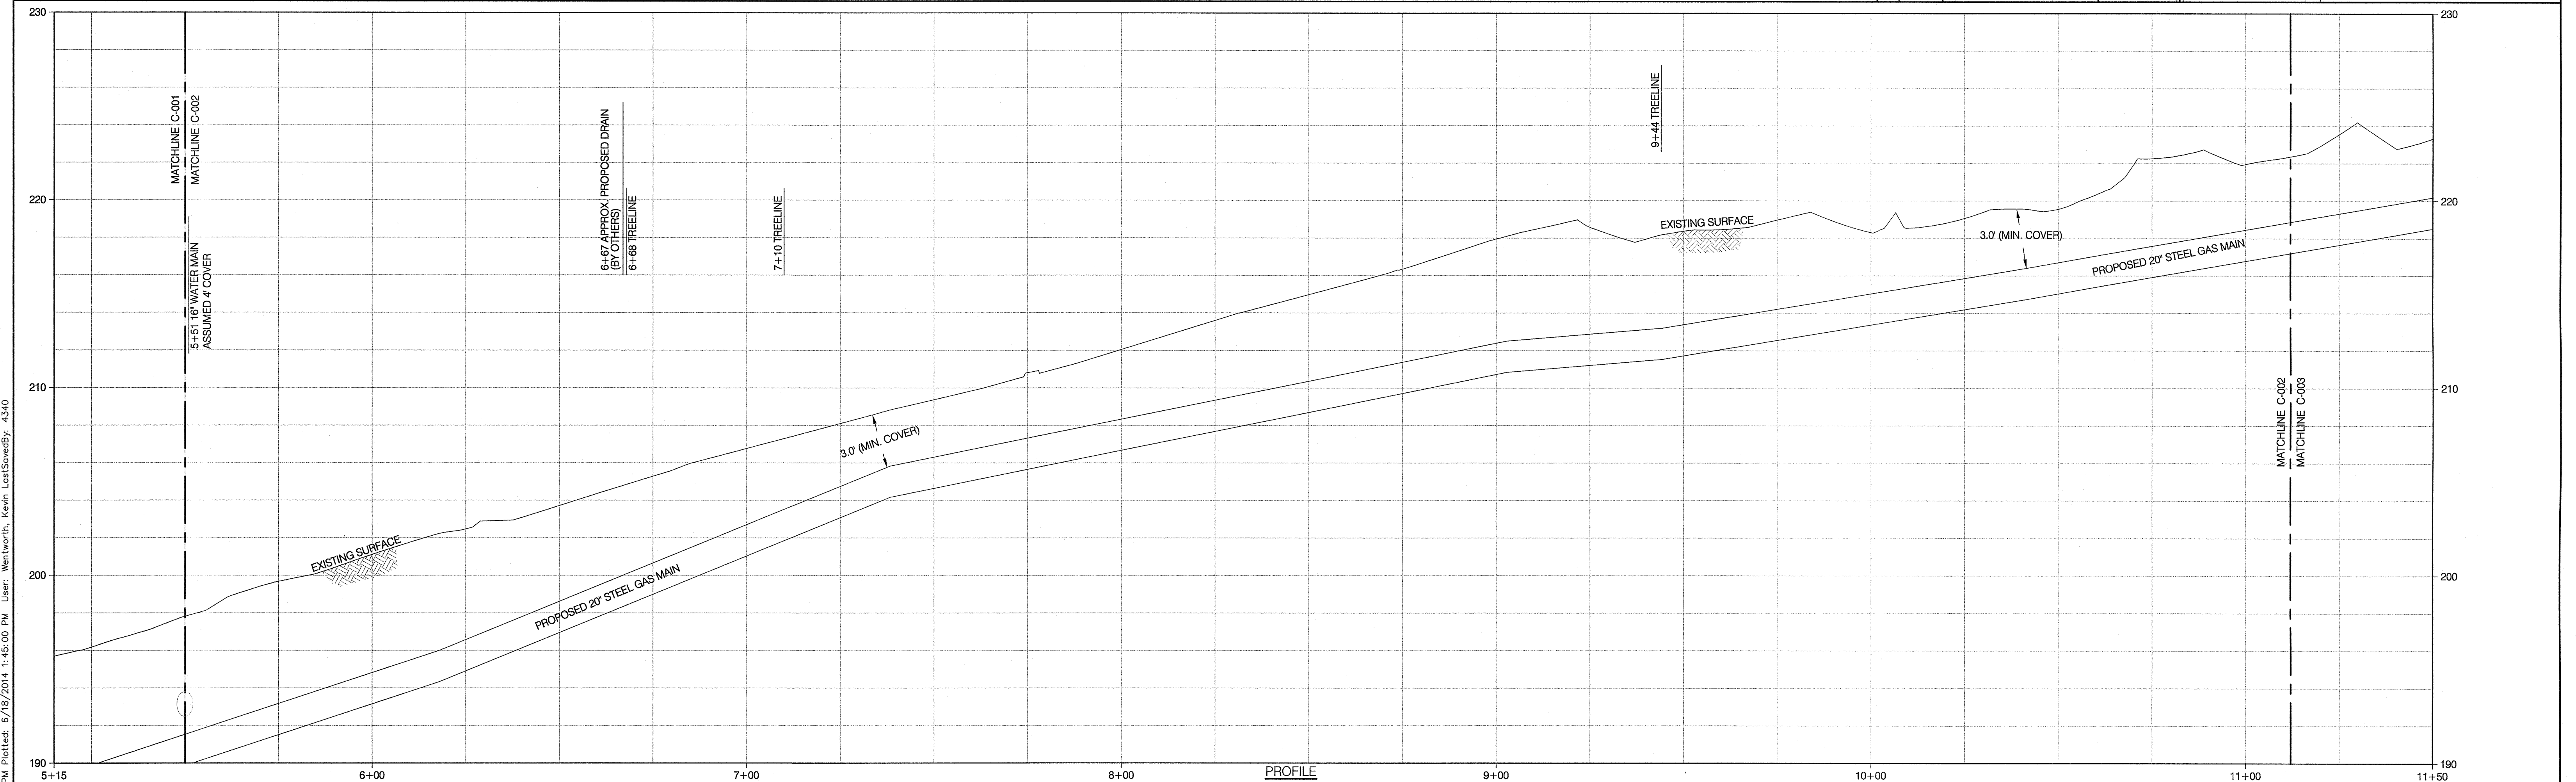[illegible]

HOR. SCALE: 1"=20' VER. SCALE: 1"=4'


Design/Engineering Prepared For:

CH2A

COLONIAL GAS COMPANY
d/b/a
nationalgrid
GAS ENGINEERING DEPARTMENT
40 SYLVAN RD.
WALTHAM, MA 02451

330 Bear Hill Road, Suite 304
Waltham, MA 02451



Main: (781) 982-7650 • www.ch2acompanies.com

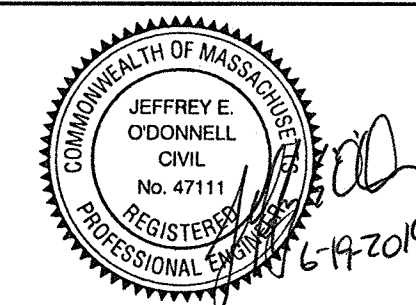



NATIONAL GRID SERVICE COMPANY, USA
SERVICE ROAD ALIGNMENT
SANDWICH, MA
BARNSTABLE COUNTY, MASSACHUSETTS

APPROVED BY	
DATE: SEPTEMBER 7, 2012	MANAGER
NATIONAL GRID SERVICE COMPANY, USA	
15-646.01-C-002	

TOWN OF SANDWICH
BARNSTABLE COUNTY, MASSACHUSETTS

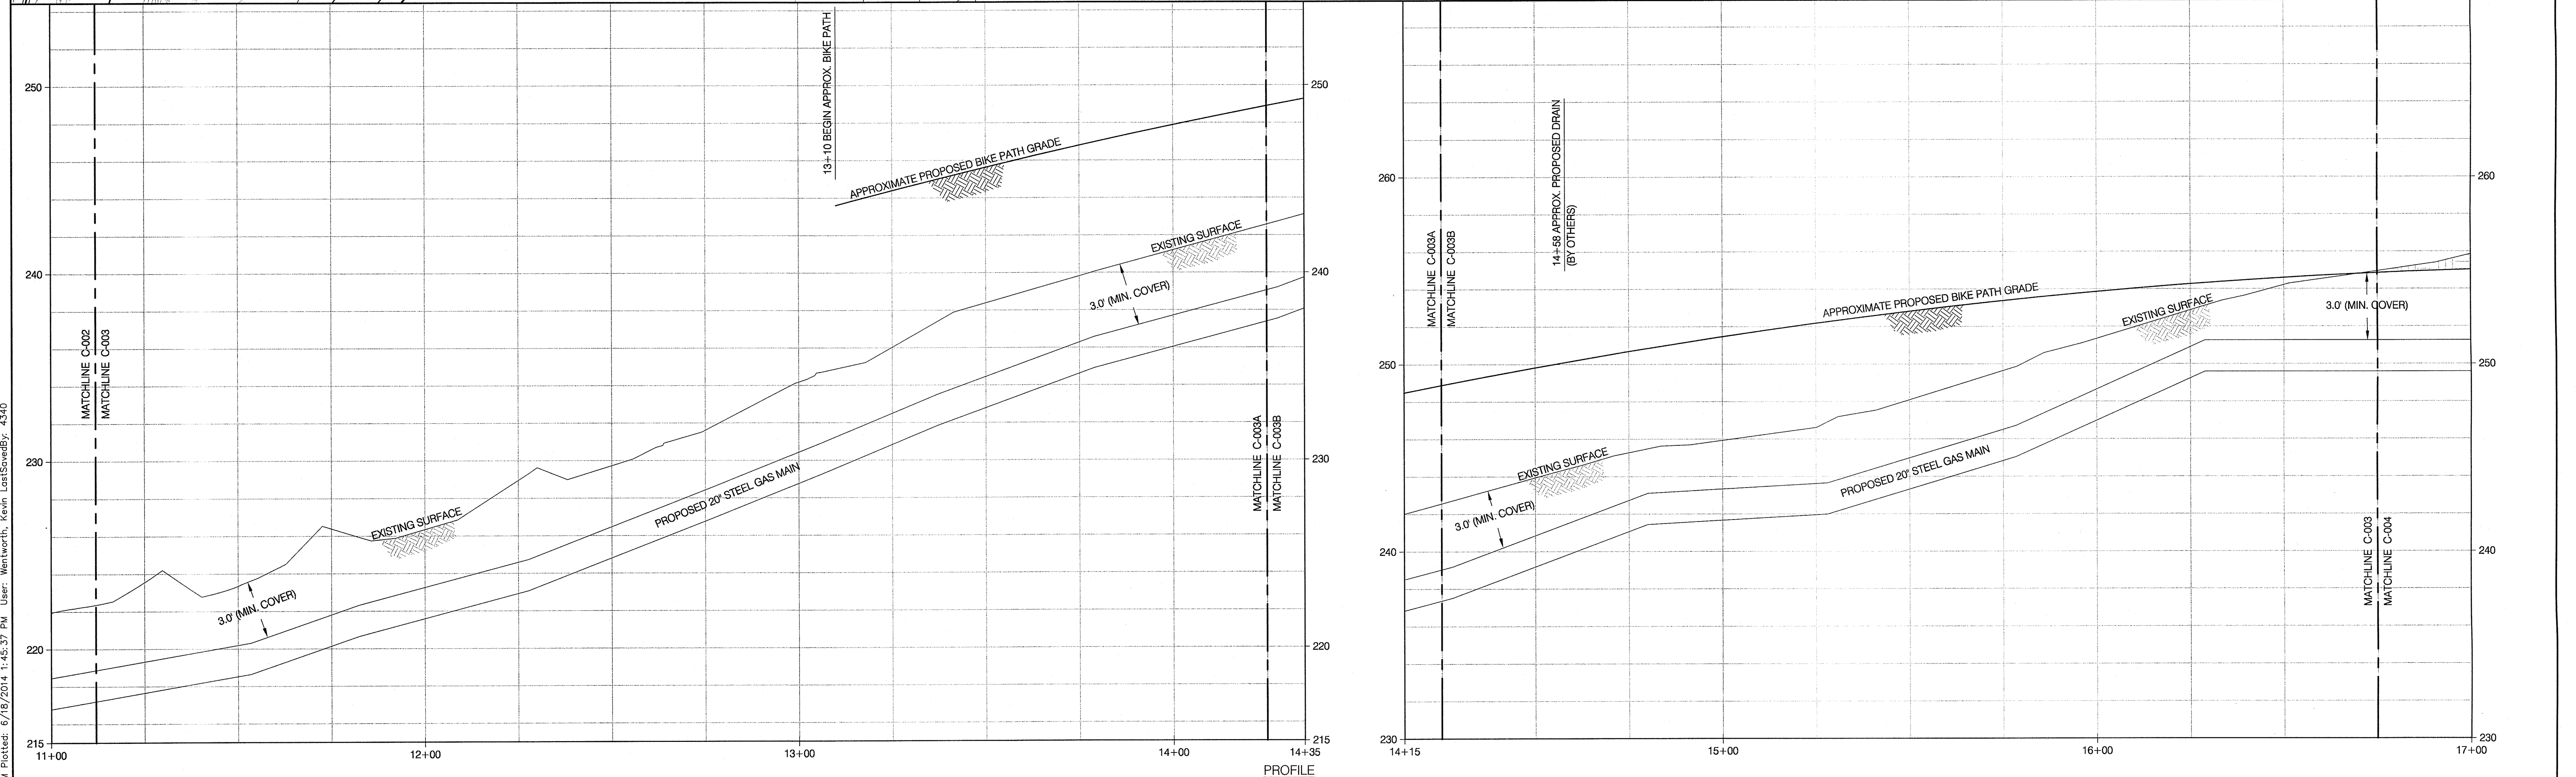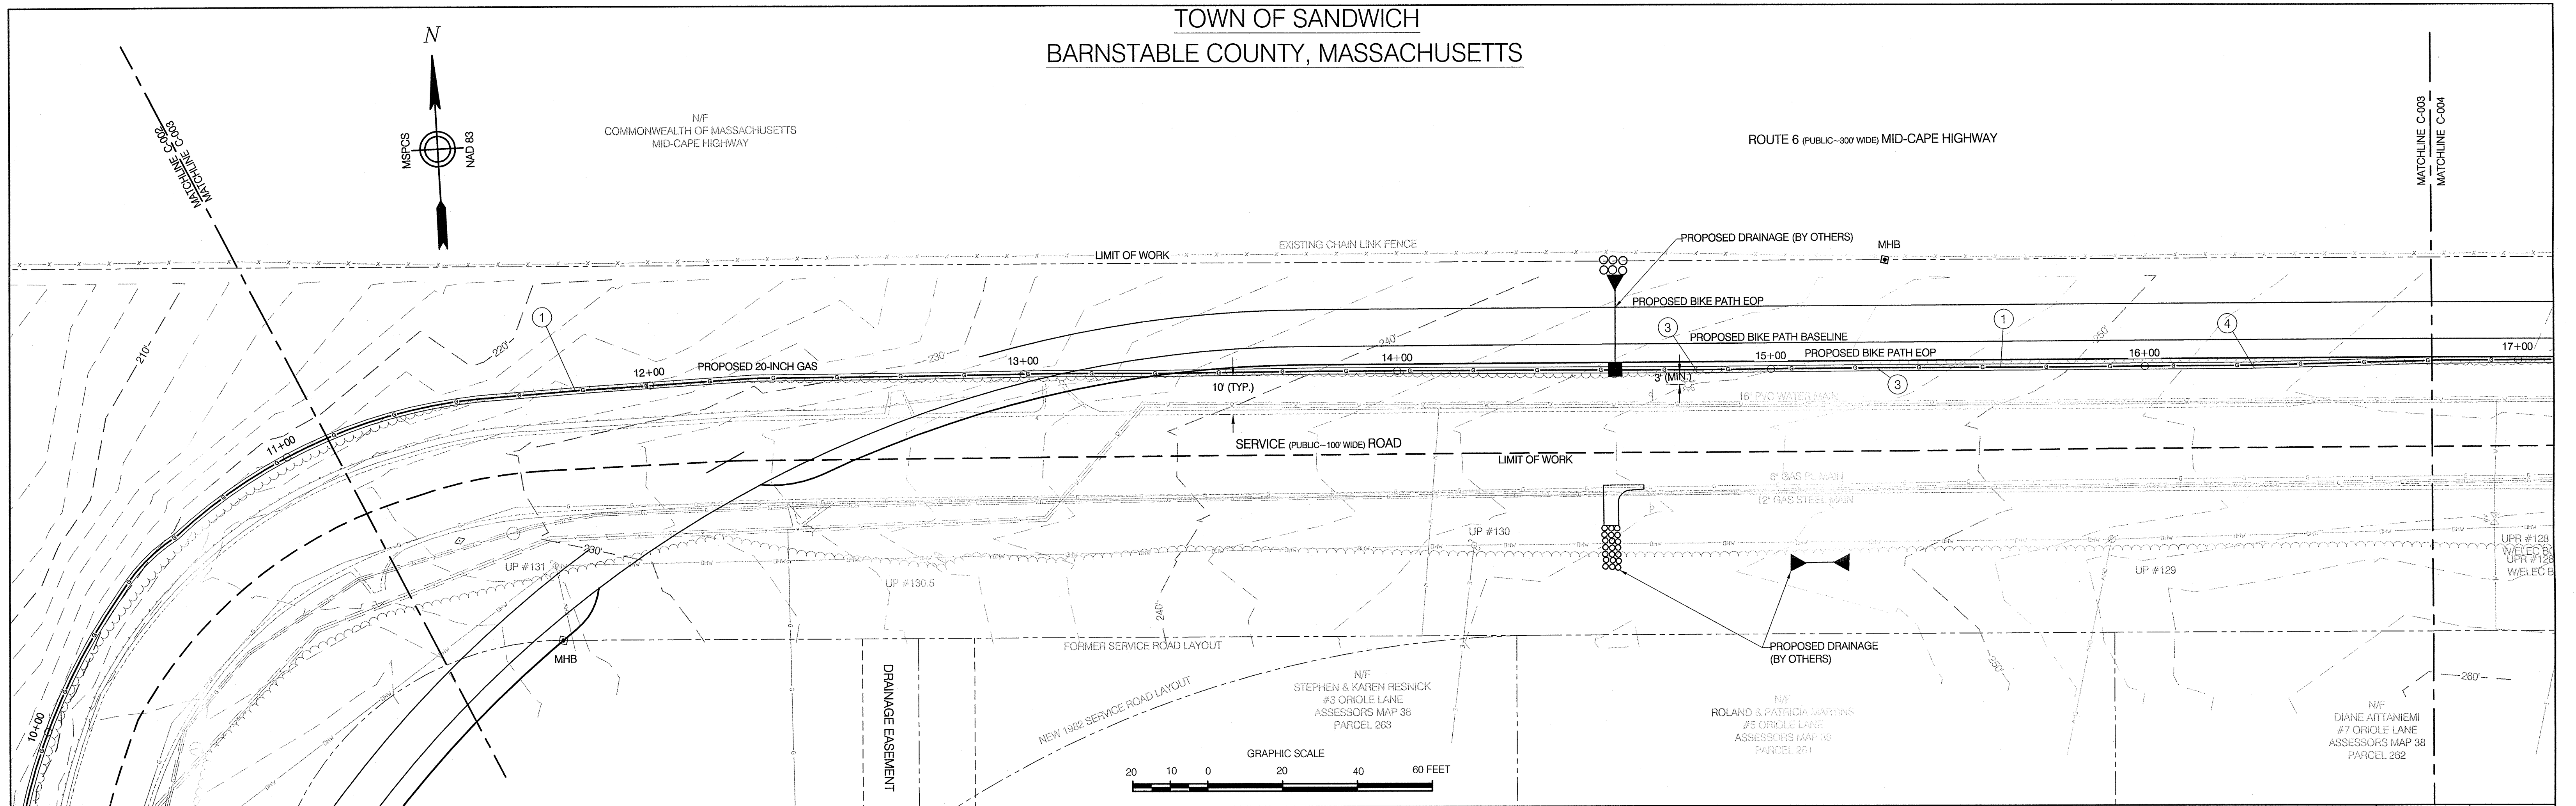[illegible]

TOWN OF SANDWICH
BARNSTABLE COUNTY, MASSACHUSETTS

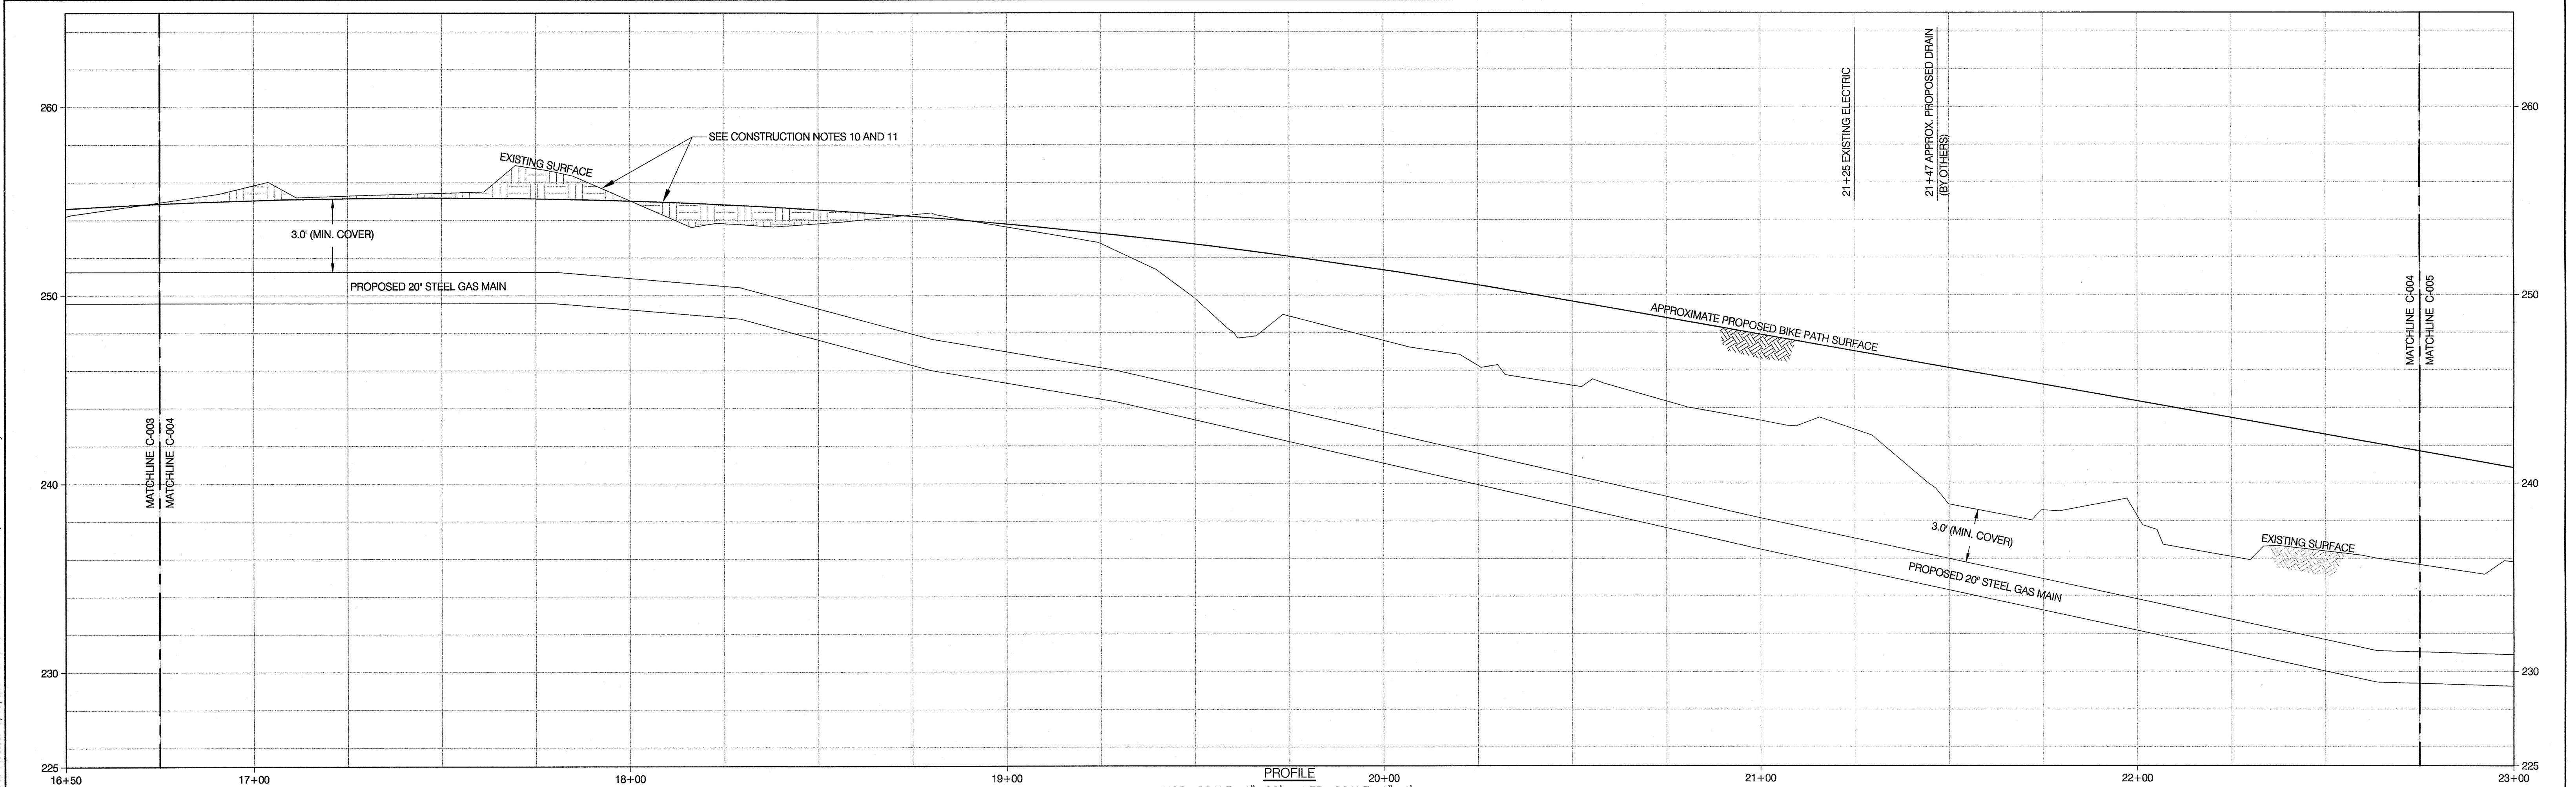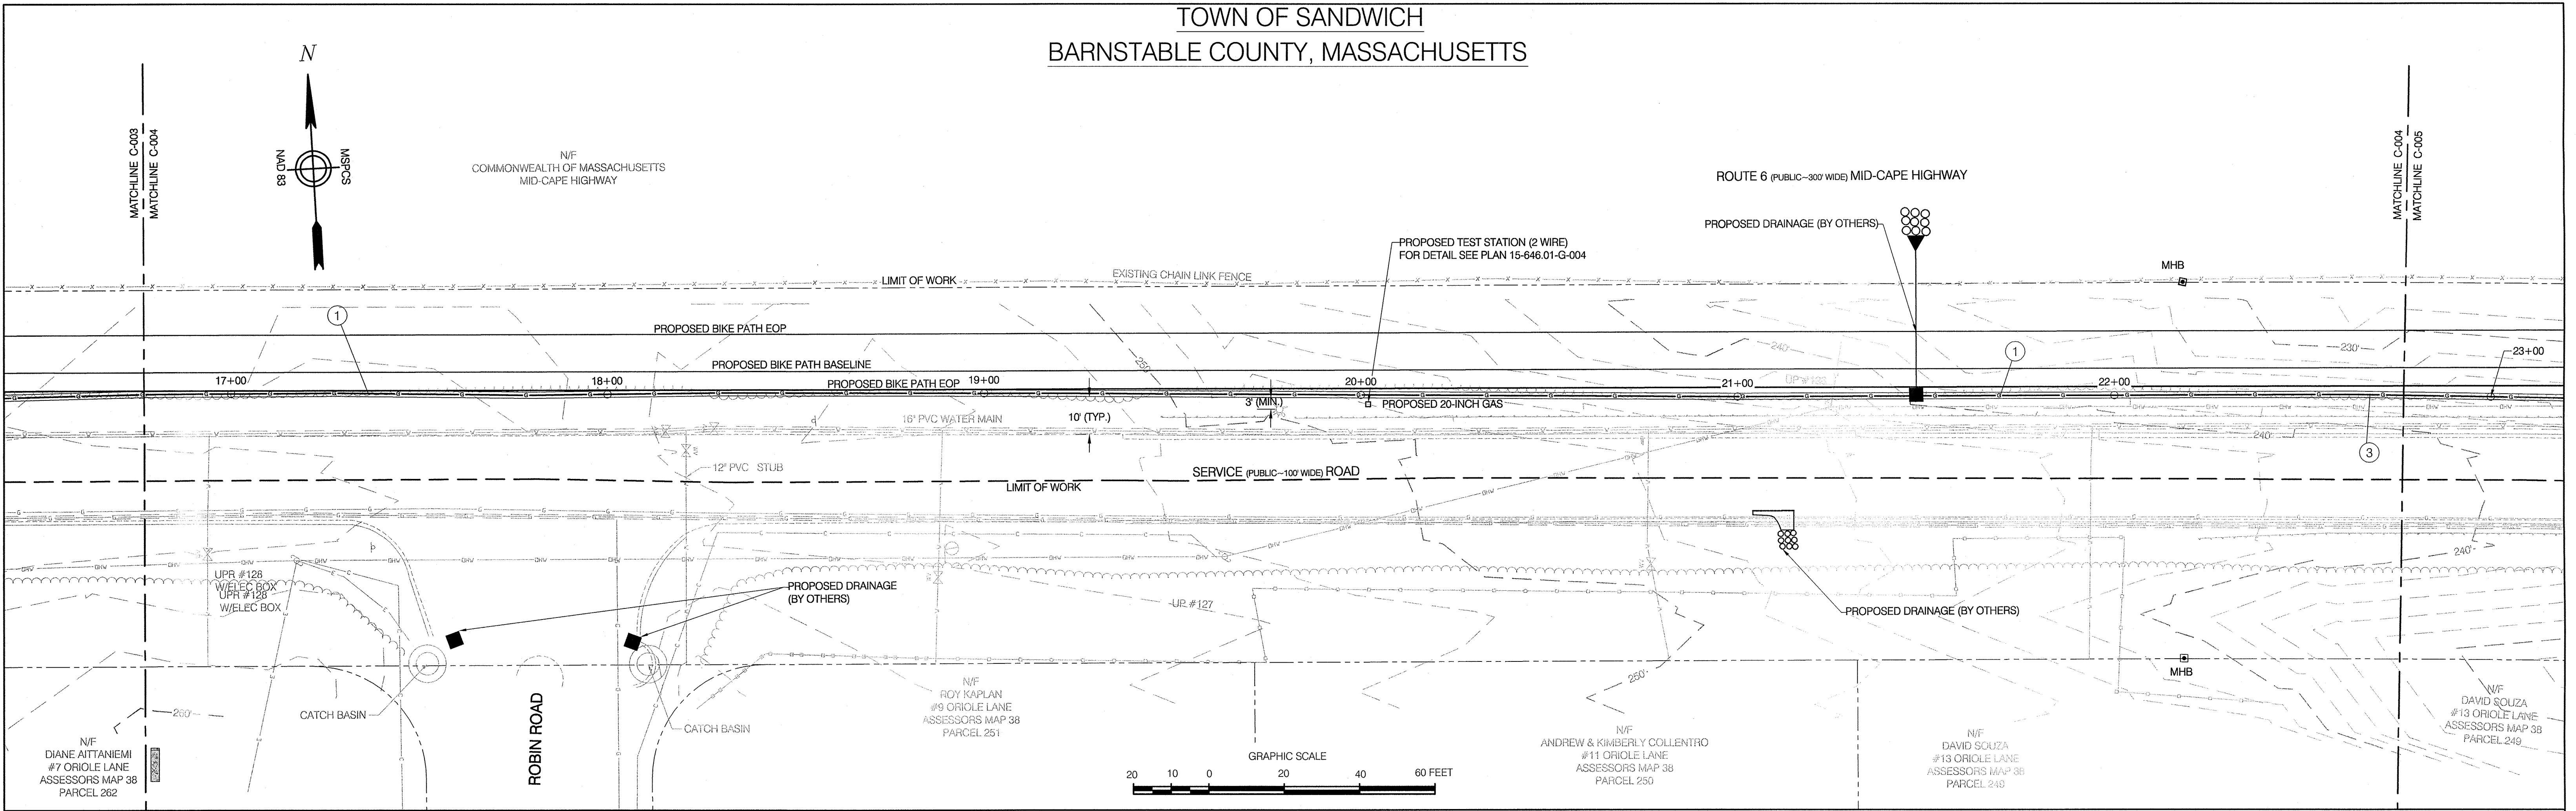

REFERENCE DRAWINGS				REVISIONS							
DRAWING NO.	TITLE	DRAWING NO.	TITLE	NO.	DATE	REMARKS	REV.	CKD.	COR.	APP.	
				0	6/14	REVISED FOR FINAL EFSB APPROVAL	KDW	SAB	KDW	JE0	

Design/Engineering

Prepared For:

COLONIAL GAS COMPANY
d/b/a
nationalgrid
GAS ENGINEERING DEPARTMENT
45 SILVER RD
WALTHAM, MA 02451

JEFFREY E. O'DONNELL
CIVIL
No. 47111
REGISTERED PROFESSIONAL ENGINEER
COMMONWEALTH OF MASSACHUSETTS

NATIONAL GRID SERVICE COMPANY, USA
SERVICE ROAD ALIGNMENT
SANDWICH, MA
BARNSTABLE COUNTY, MASSACHUSETTS
File No.: 15-646.01 ALIGN.dwg

APPROVED BY

DATE: SEPTEMBER 7, 2012



MANAGER

NATIONAL GRID SERVICE COMPANY, USA

15-646.01-C-004

File: W:\NATIONAL GRID\2011 RFP 01\01 SANDWICH\DRAWINGS\15-646.01 ALIGN 1-23_REV 0 (ISSUED FOR FINAL EFSB APPROVAL).DWG
Saved: 6/18/2014 1:41:05 PM Plotted: 6/18/2014 1:46:15 PM User: Wentworth, Kevin LastSavedBy: 4340

TOWN OF SANDWICH
BARNSTABLE COUNTY, MASSACHUSETTS

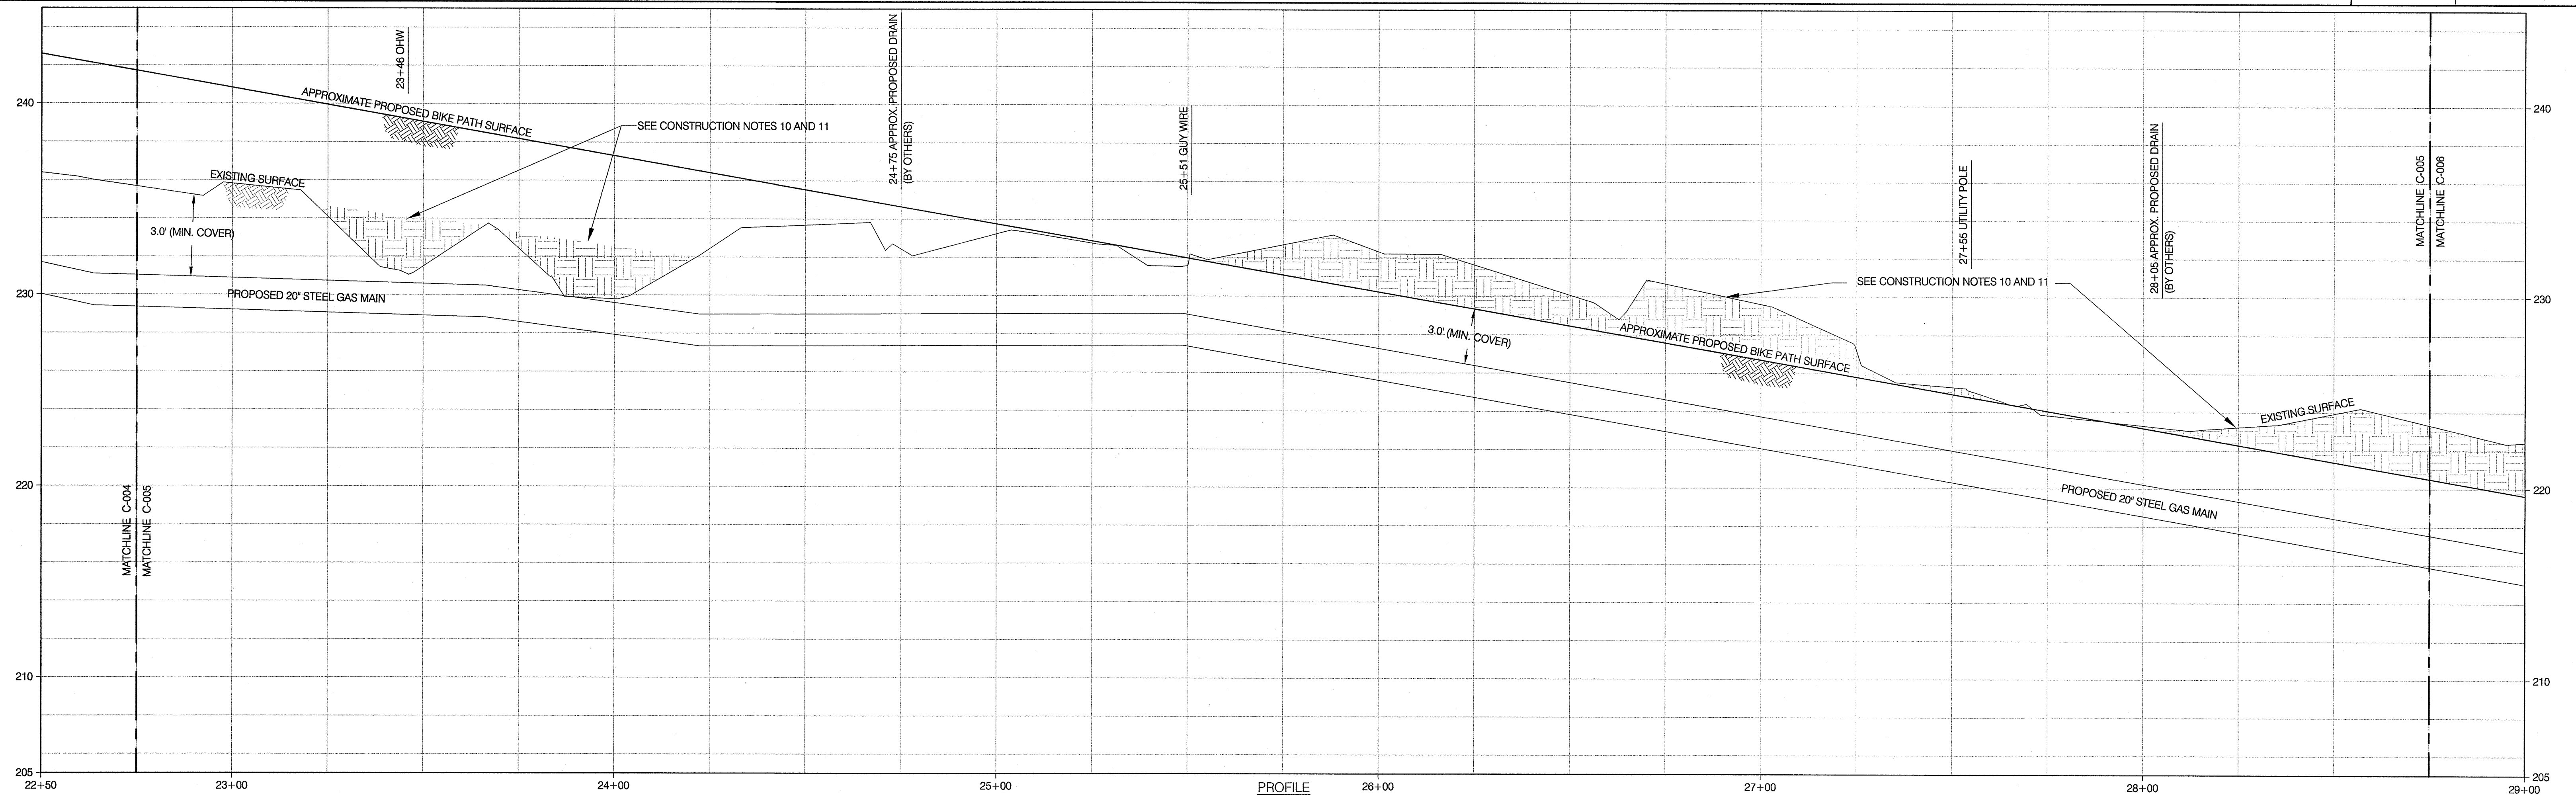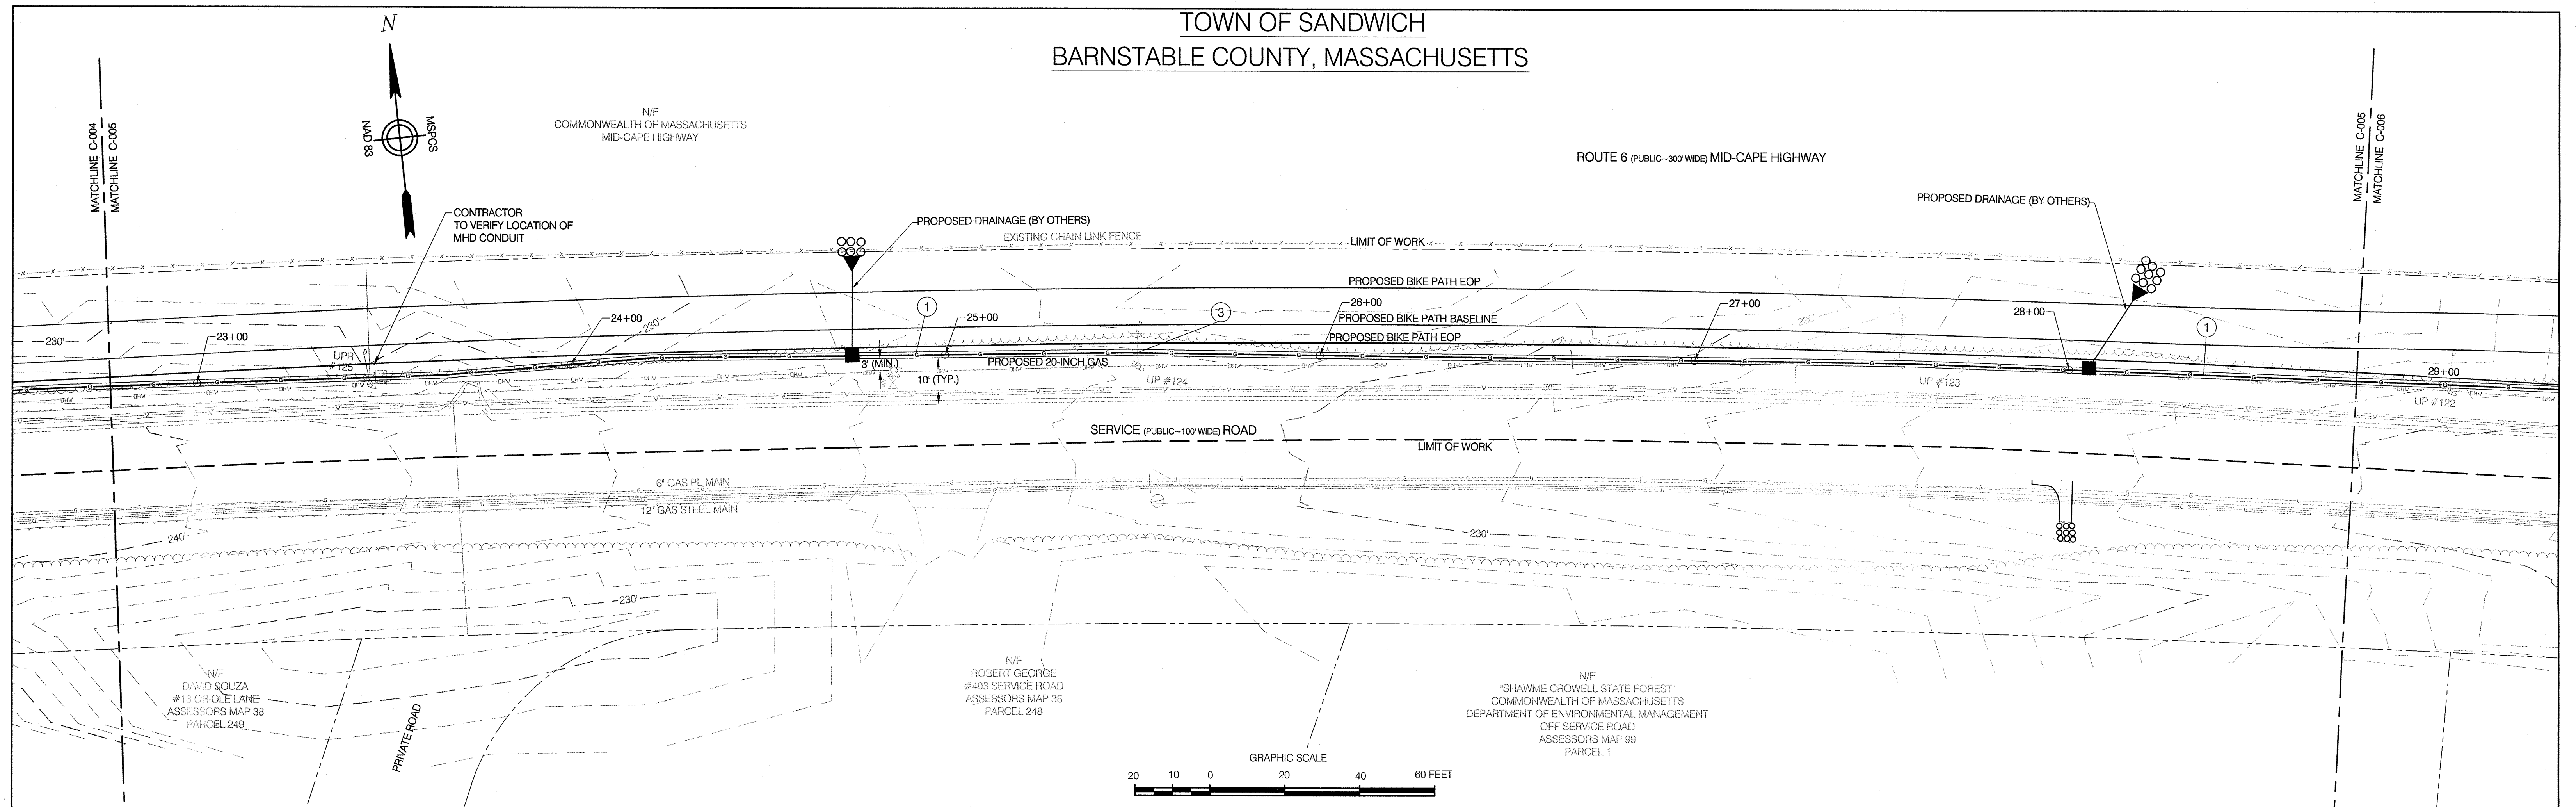[illegible]


HOR. SCALE: 1"=20' VER. SCALE: 1"=4'

Design/Engineering

Prepared For:

CHA
330 Bear Hill Road, Suite 304
Walworth, MA 02451
Main: (781) 982-7650 • www.chacompanies.com

COLONIAL GAS COMPANY
d/b/a
nationalgrid
GAS ENGINEERING DEPARTMENT
40 SYLVAN RD.
WALTHAM, MA 02451

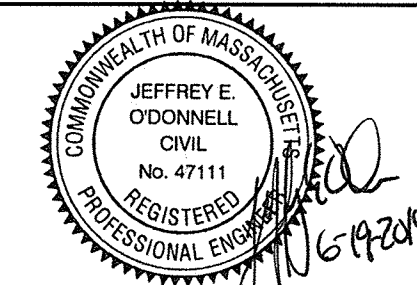

NATIONAL GRID SERVICE COMPANY, USA
SERVICE ROAD ALIGNMENT
SANDWICH, MA
BARNSTABLE COUNTY, MASSACHUSETTS

File No.: 15-646.01 ALIGN.dwg

APPROVED BY



DATE: SEPTEMBER 7, 2012

NAGER

NATIONAL GRID SERVICE COMPANY, USA

15-646.01-C-005

TOWN OF SANDWICH
BARNSTABLE COUNTY, MASSACHUSETTS

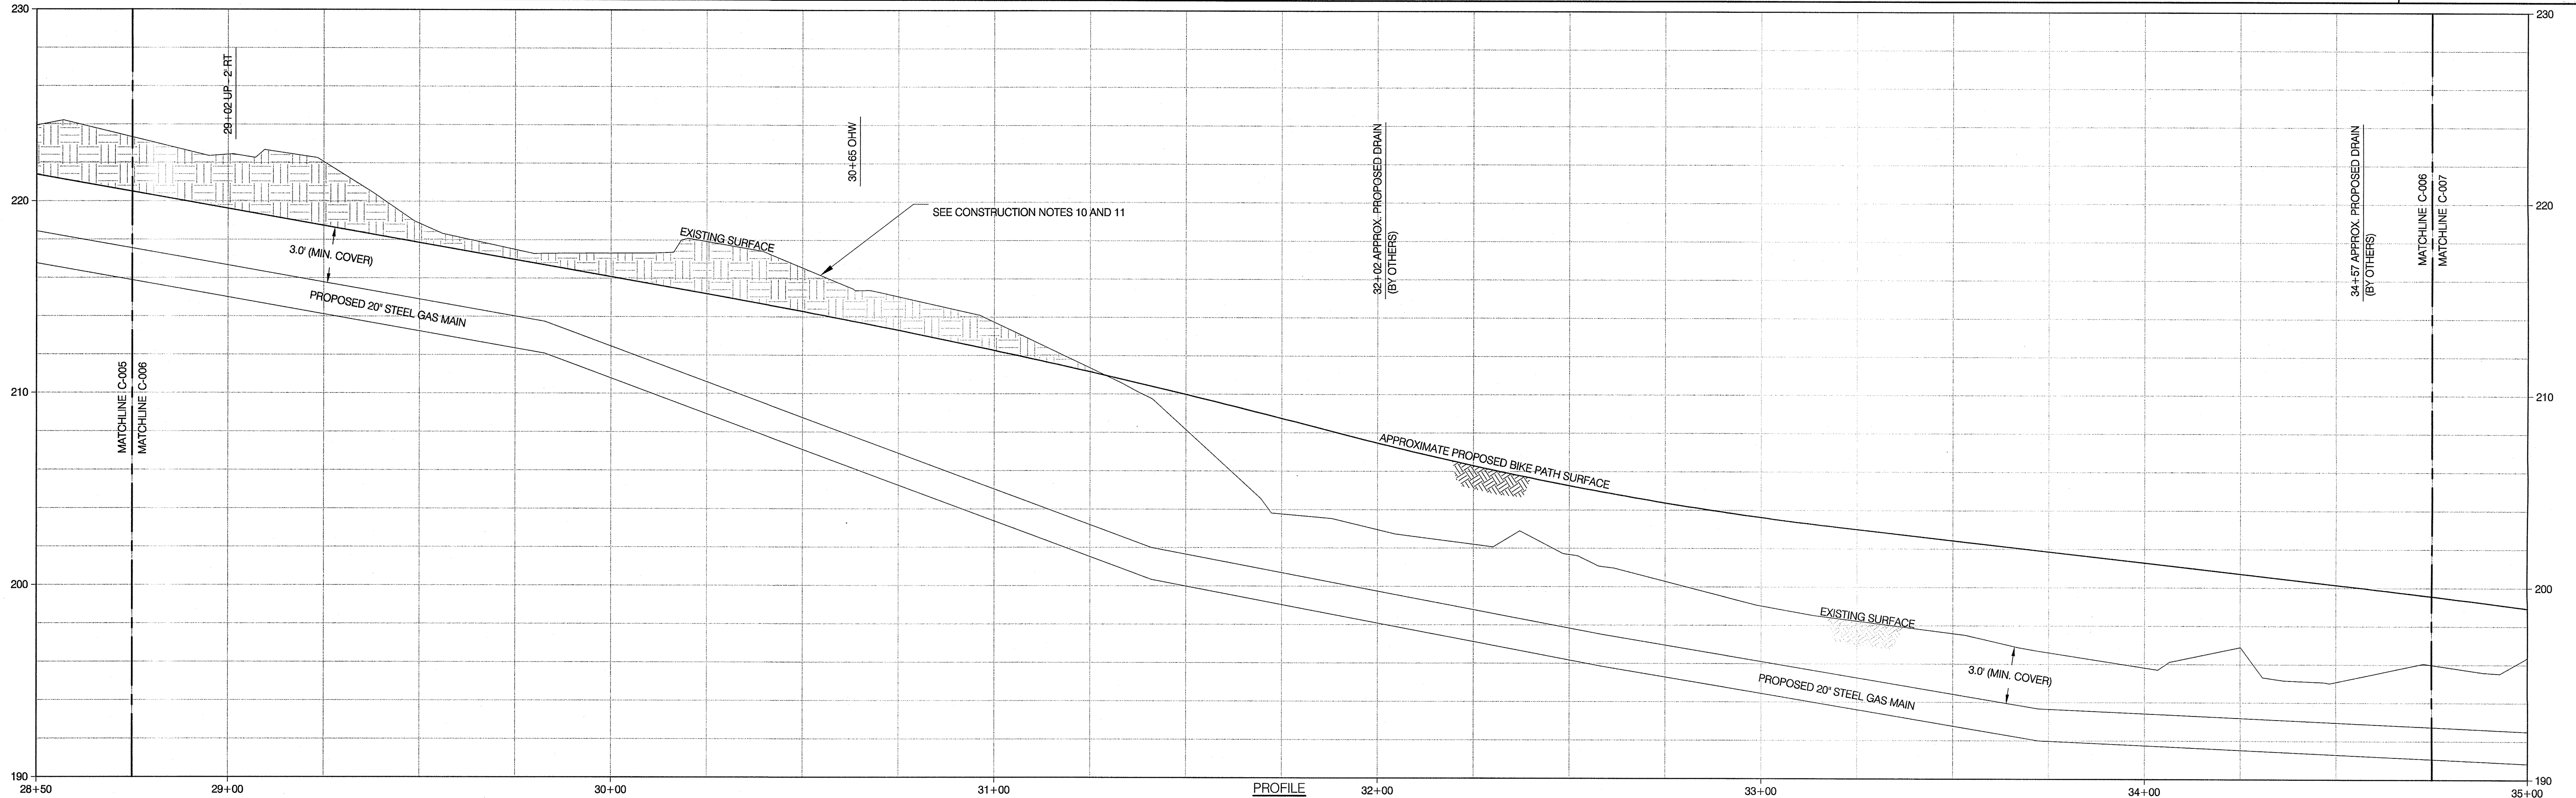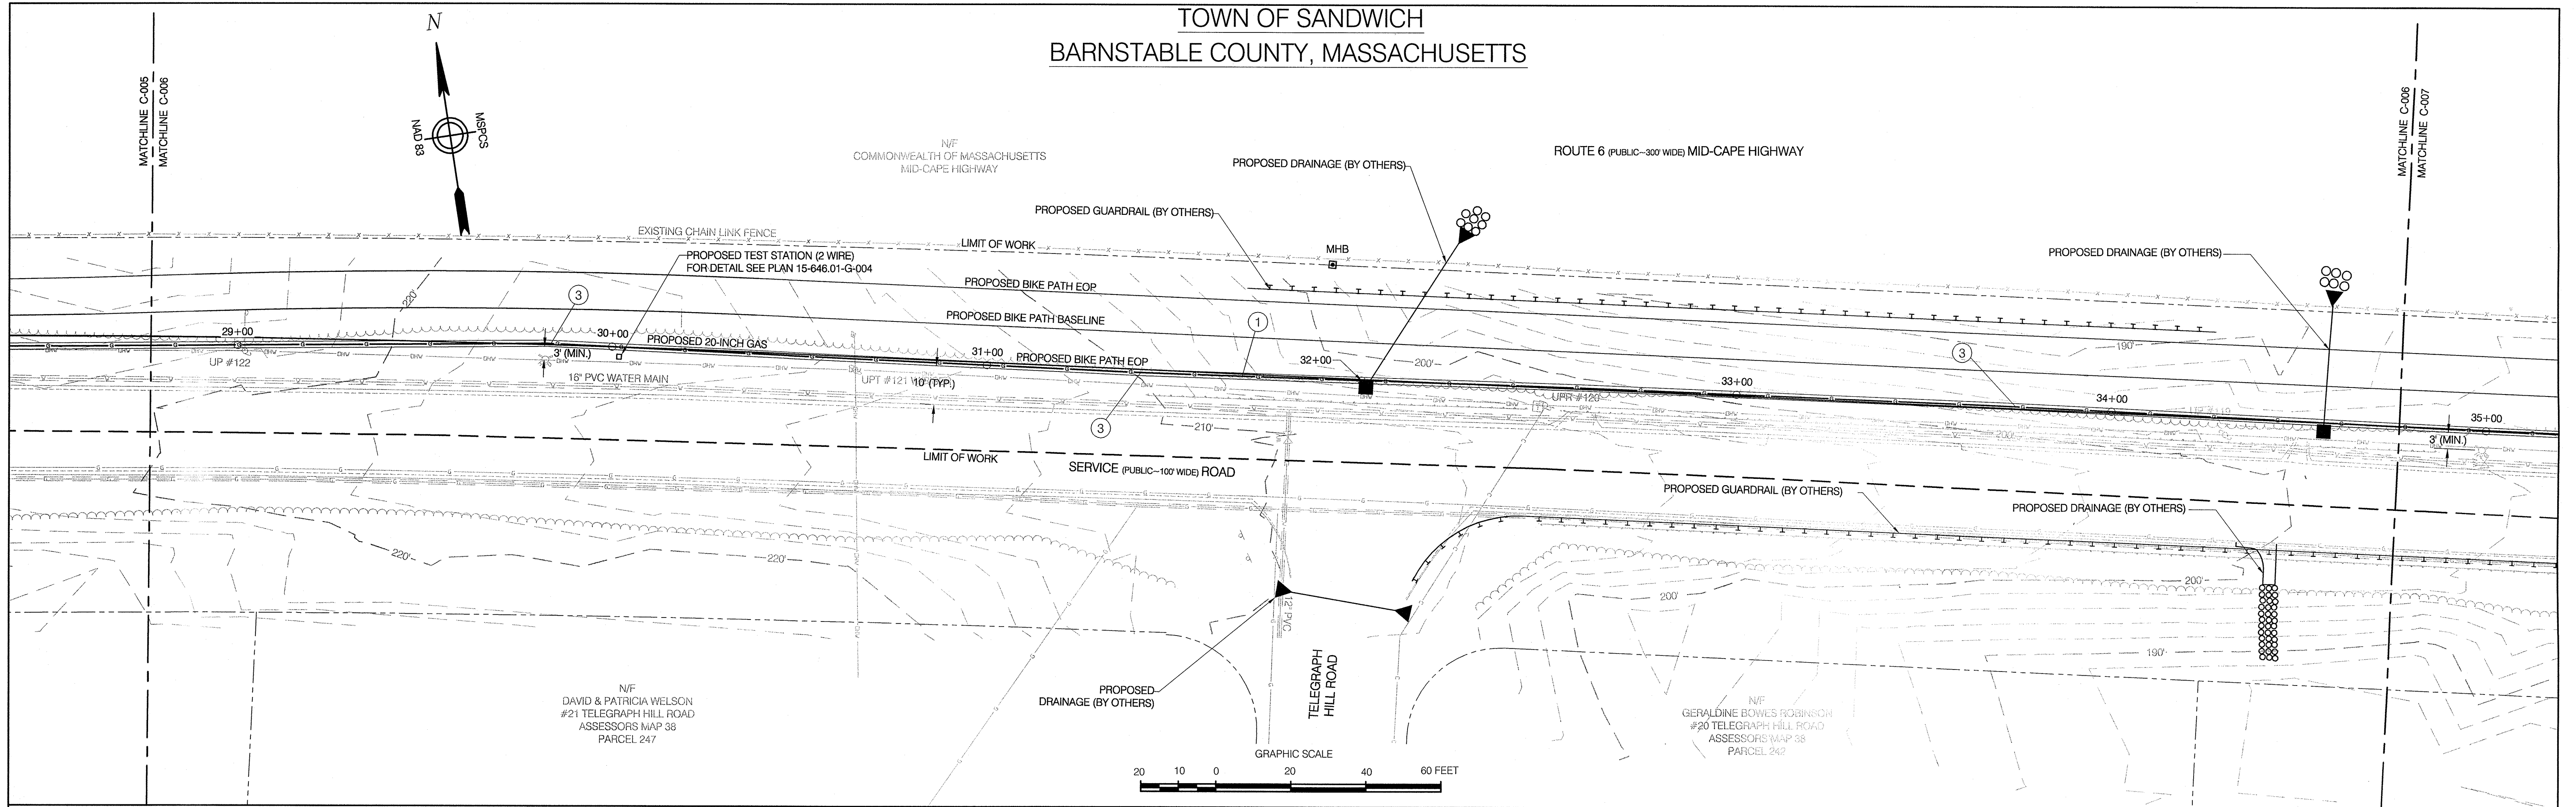

REFERENCE DRAWINGS

DRAWING NO.	TITLE	DRAWING NO.	TITLE


REVISIONS

NO.	DATE	REMARKS	REV.	KDW	SAB	KDW	APP.
0	6/14	REVISED FOR FINAL EFSB APPROVAL					JEO

PROFILE
HOR. SCALE: 1"=20' VER. SCALE: 1"=4'





Colonial Gas Company
d/b/a
nationalgrid
GAS ENGINEERING DEPARTMENT
40 SYLVAN RD.
WALTHAM, MA 02451

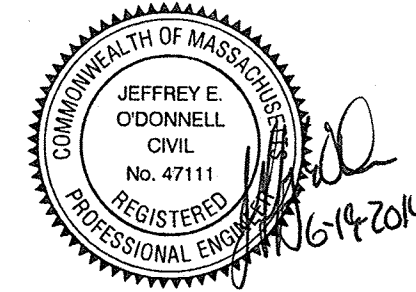

NATIONAL GRID SERVICE COMPANY, USA
SERVICE ROAD ALIGNMENT
SANDWICH, MA
BARNSTABLE COUNTY, MASSACHUSETTS
File No.: 15-646.01 ALIGN.dwg

APPROVED BY
DATE: SEPTEMBER 7, 2012
MANAGER
NATIONAL GRID SERVICE COMPANY, USA
15-646.01-C-006



TOWN OF SANDWICH
BARNSTABLE COUNTY, MASSACHUSETTS

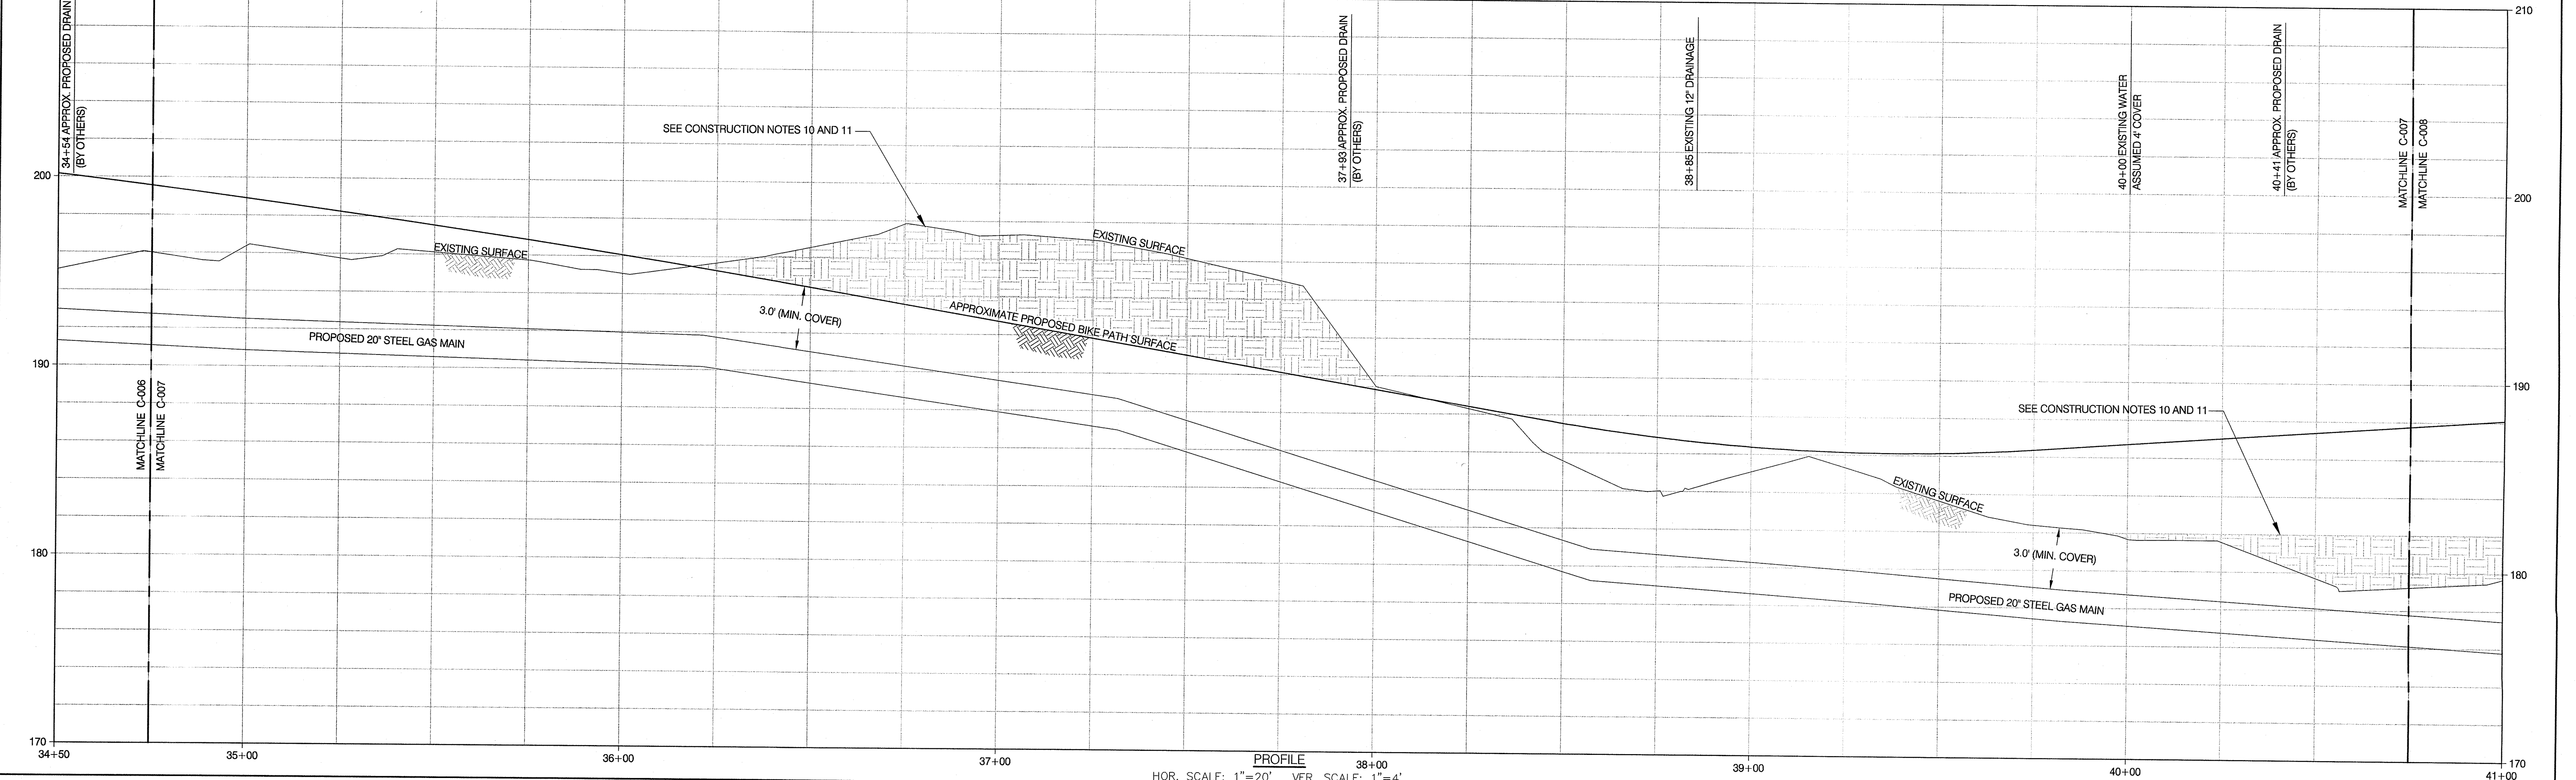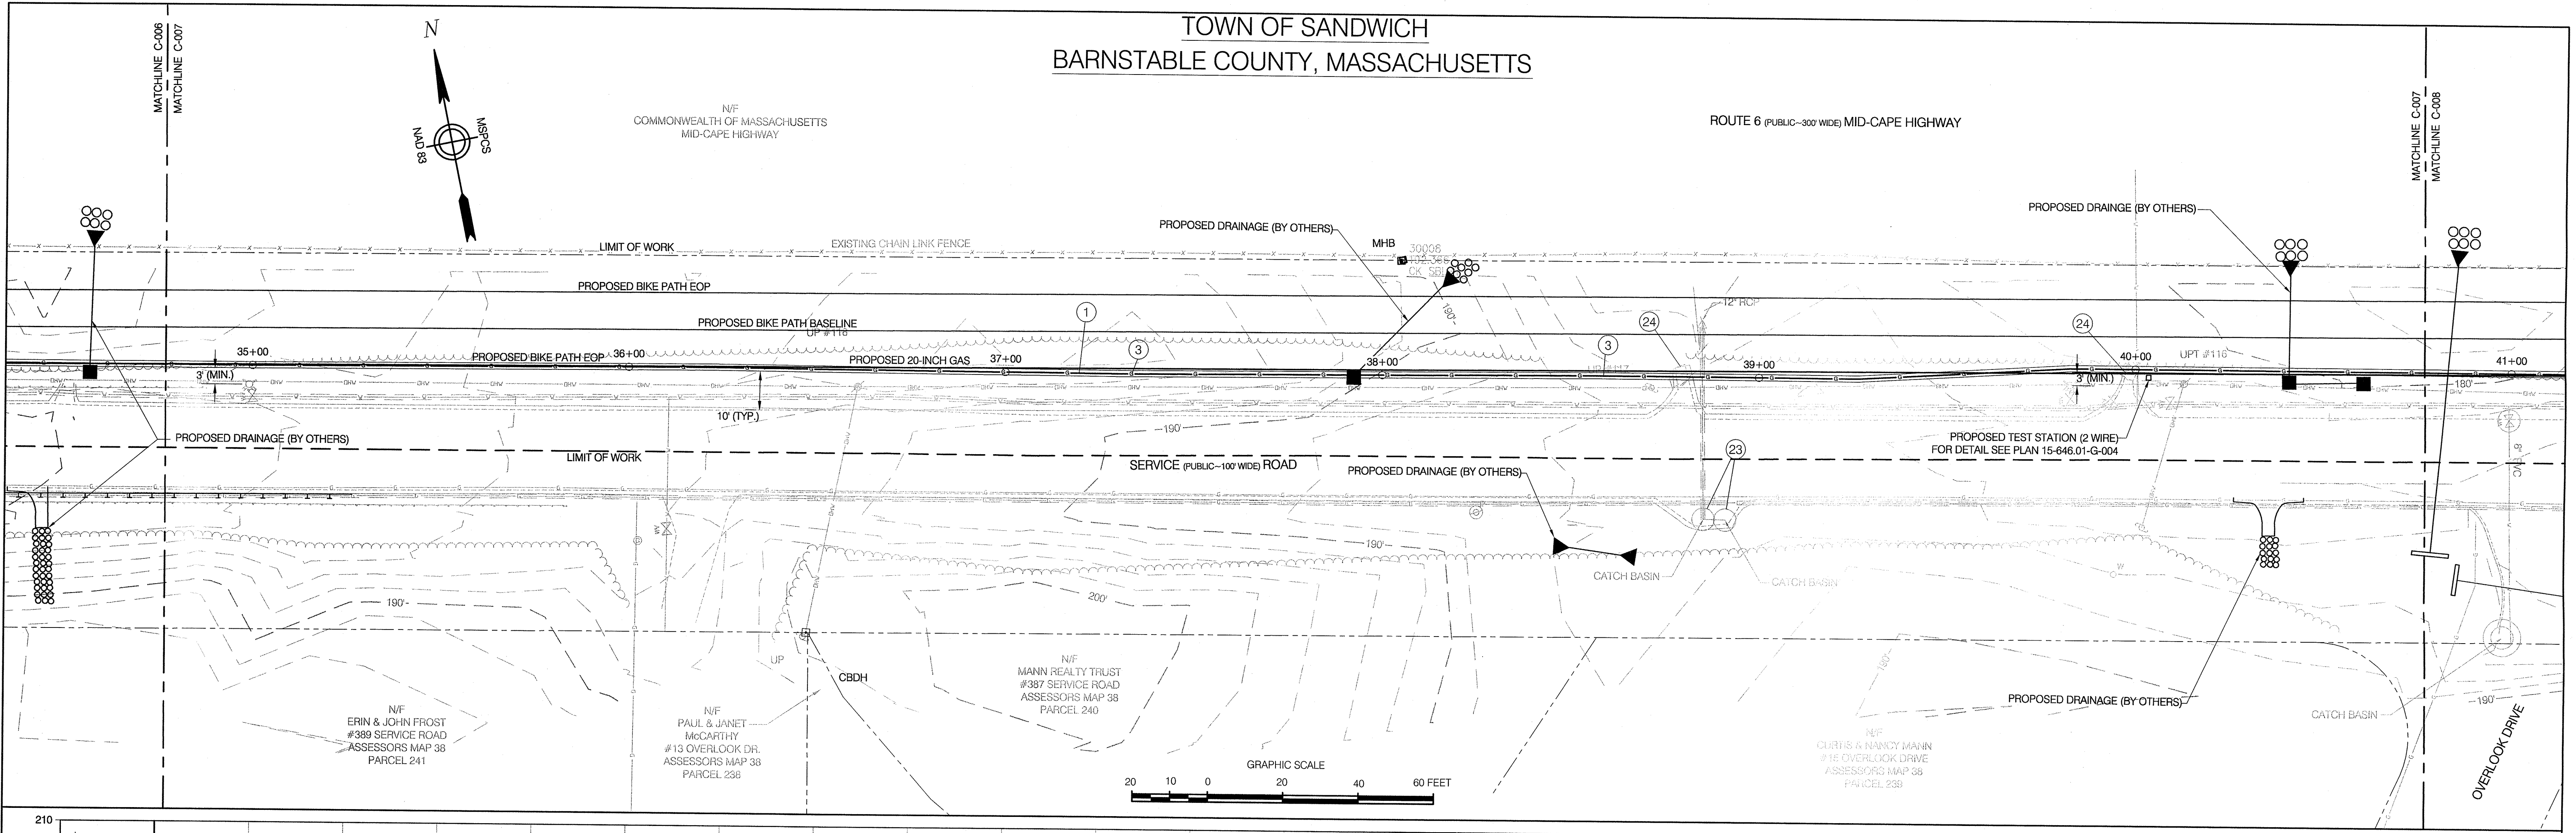

REFERENCE DRAWINGS				REVISIONS				DESIGN/ENGINEERING				NATIONAL GRID SERVICE COMPANY, USA			
DRAWING NO.	TITLE	DRAWING NO.	TITLE	NO.	DATE	REMARKS	REV.	CHK.	COR.	APP.		APPROVED BY			
				0	6/14	REVISED FOR FINAL EFSB APPROVAL	KDW	SAB	KDW	JEO		DATE: SEPTEMBER 7, 2012			
												MANAGER			
												NATIONAL GRID SERVICE COMPANY, USA			
												15-646.01-C-007			

File: W:\NATIONAL GRID\2011 RFP\01\01 SANDWICH\DRAWINGS\15-646.01 ALIGN 1-23_REV 0 (ISSUED FOR FINAL EFSB APPROVAL).DWG
Saved: 6/18/2014 1:41:05 PM Plotter: 6/18/2014 1:48:22 PM User: Waltham, Kevin.LaSalle@ngs.com

TOWN OF SANDWICH
BARNSTABLE COUNTY, MASSACHUSETTS

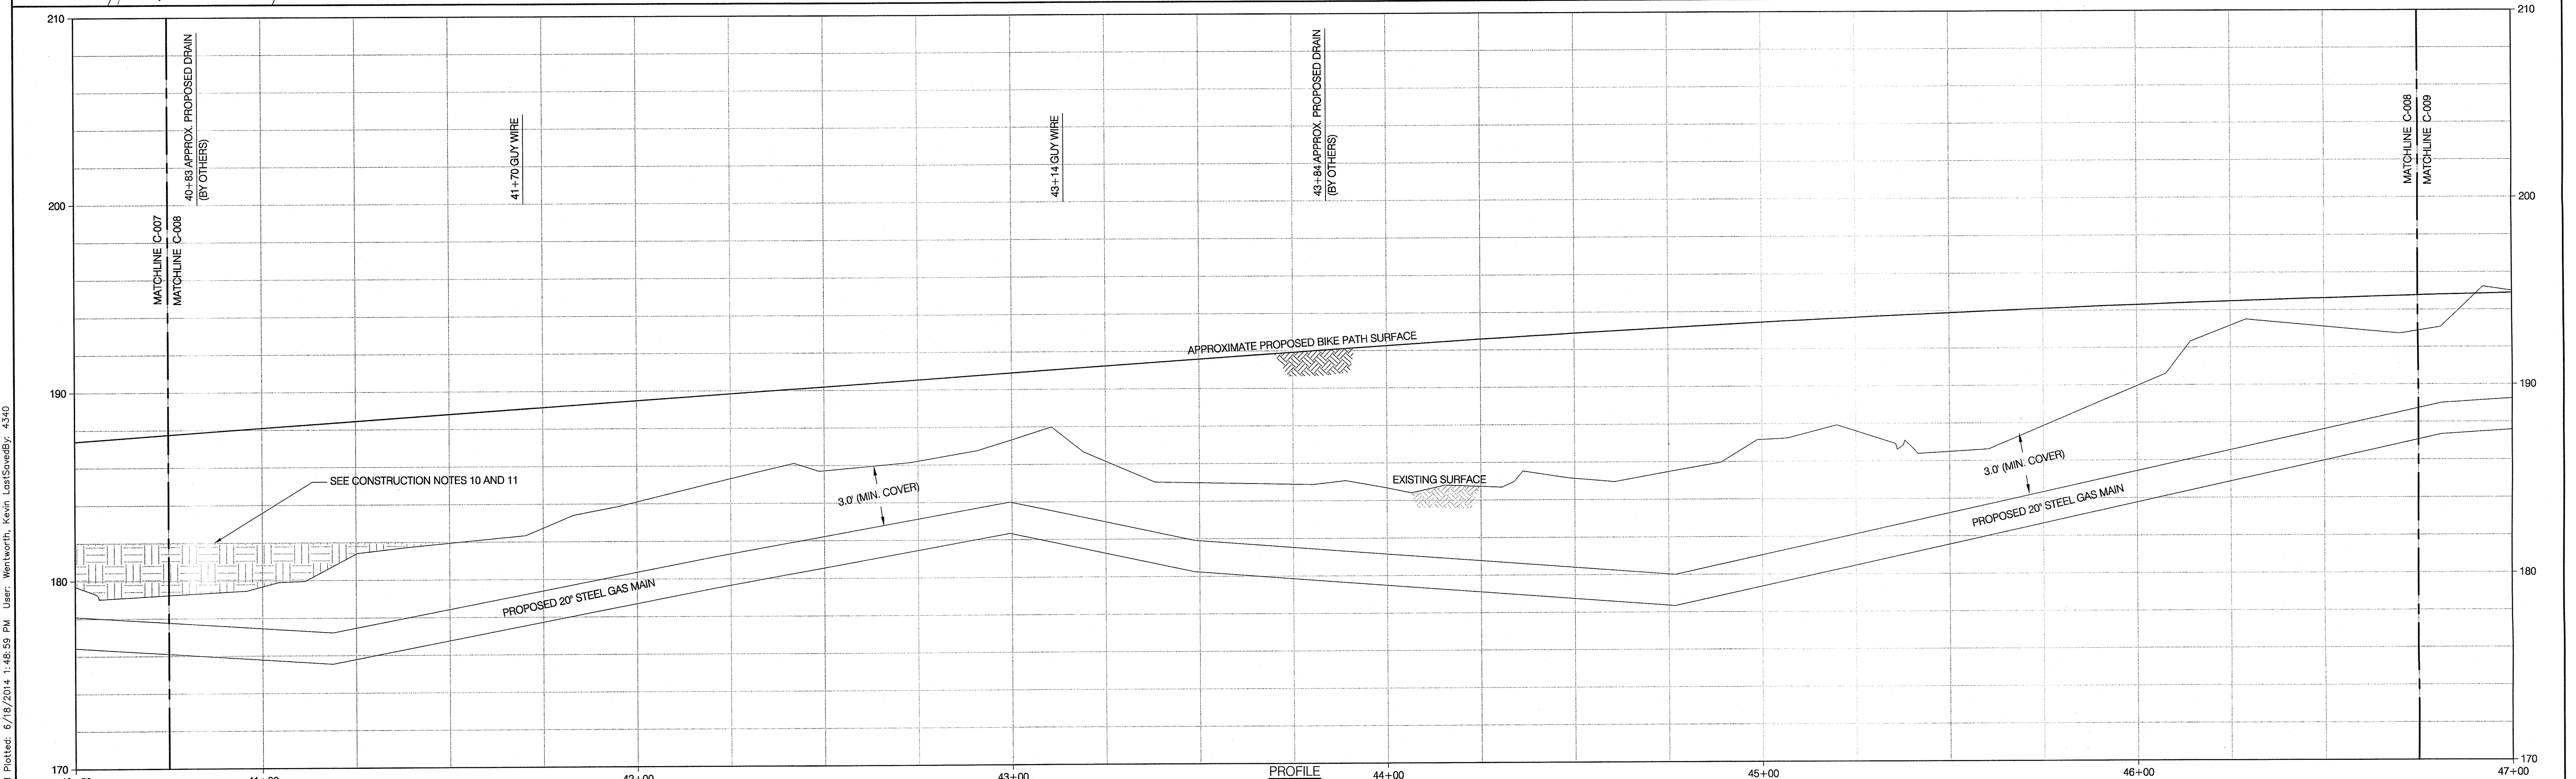
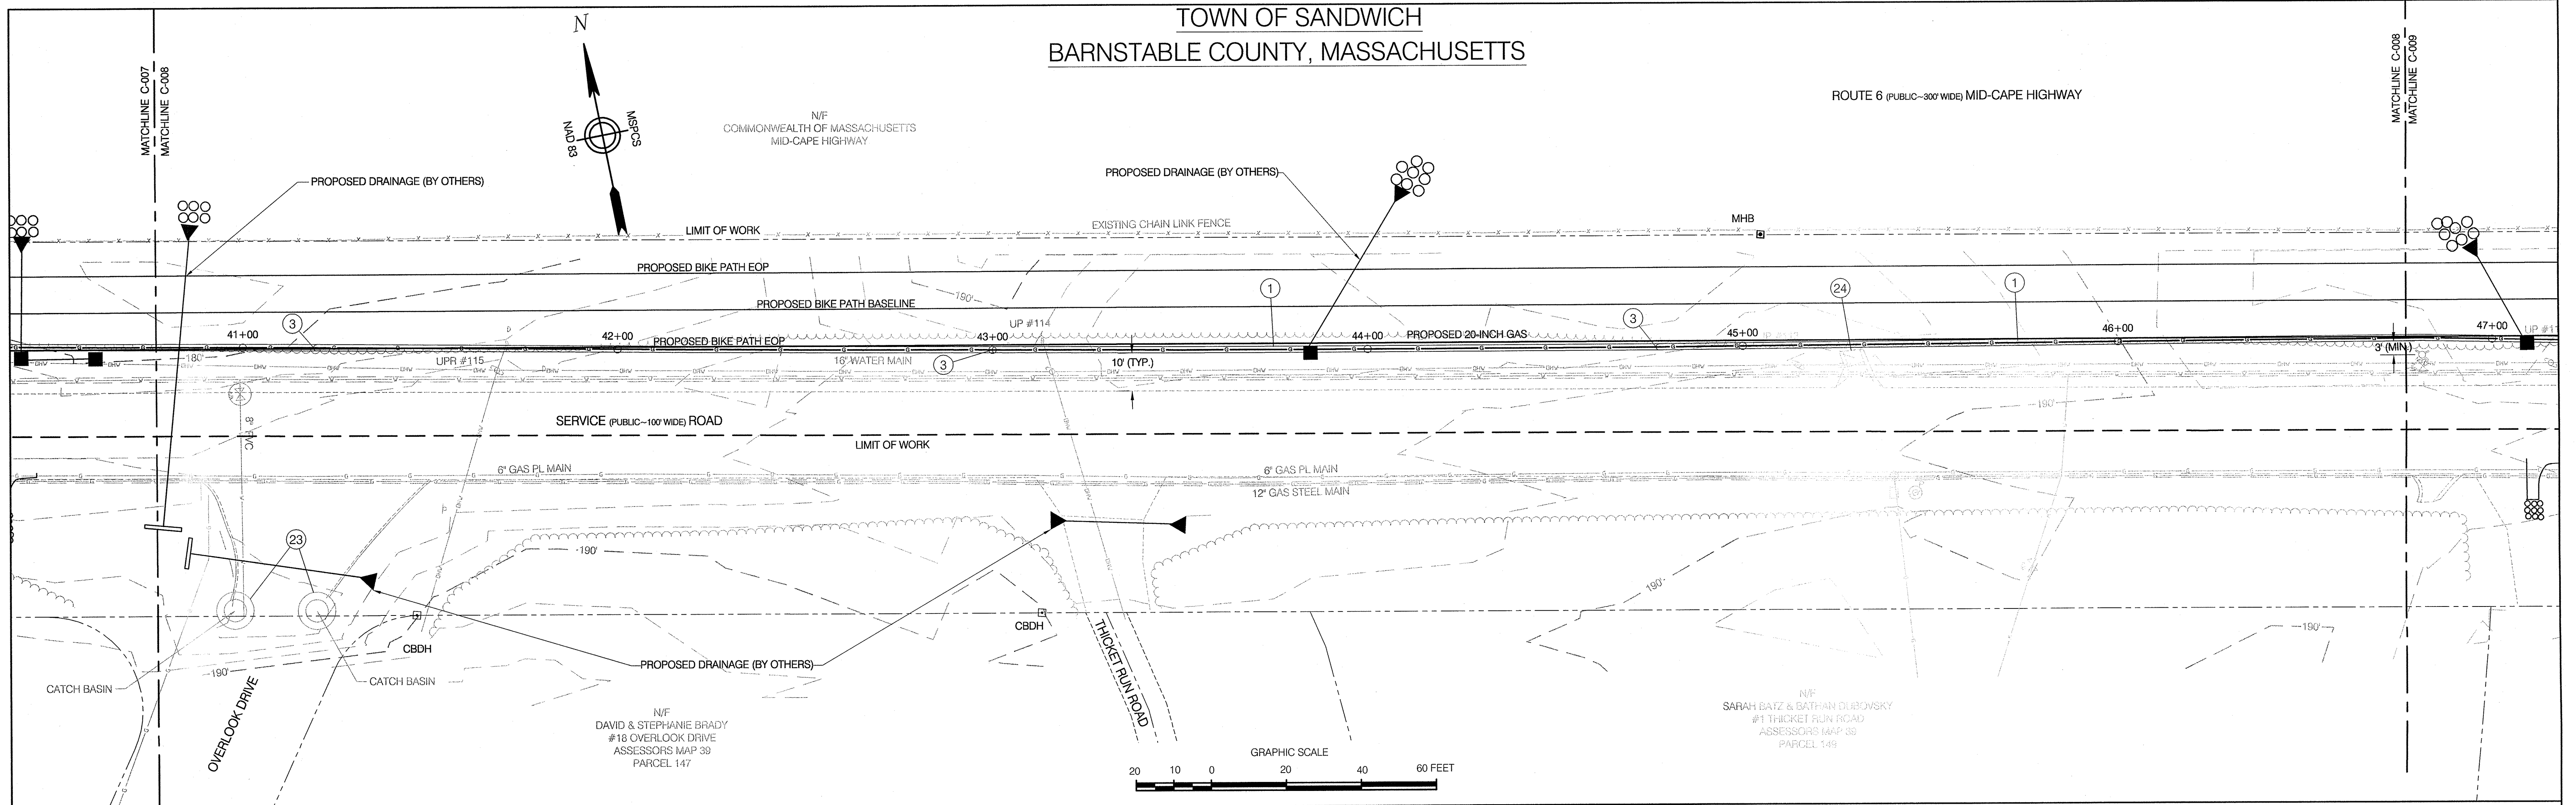


REFERENCE DRAWINGS				REVISIONS							
DRAWING NO.	TITLE	DRAWING NO.	TITLE	NO.	DATE	REMARKS	REV.	CKD.	COR.	APP.	
				0	6/14	REVISED FOR FINAL EFSB APPROVAL					

CHIA 330 Bear Hill Road, Suite 304 Waltham, MA 02451 Main: (781) 982-7650 • www.chiacompanies.com		COLONIAL GAS COMPANY d/b/a nationalgrid GAS ENGINEERING DEPARTMENT 40 SYLVAN RD. WALTHAM, MA 02451		NATIONAL GRID SERVICE COMPANY, USA SERVICE ROAD ALIGNMENT SANDWICH, MA BARNSTABLE COUNTY, MASSACHUSETTS File No.: 15-646.01 ALIGN.dwg		APPROVED BY DATE: SEPTEMBER 7, 2012 MANAGER NATIONAL GRID SERVICE COMPANY, USA 15-646.01-C-008	
---	--	--	--	--	--	---	--

TOWN OF SANDWICH
BARNSTABLE COUNTY, MASSACHUSETTS

ROUTE 6 (PUBLIC-300' WIDE) MID-CAPE HIGHWAY

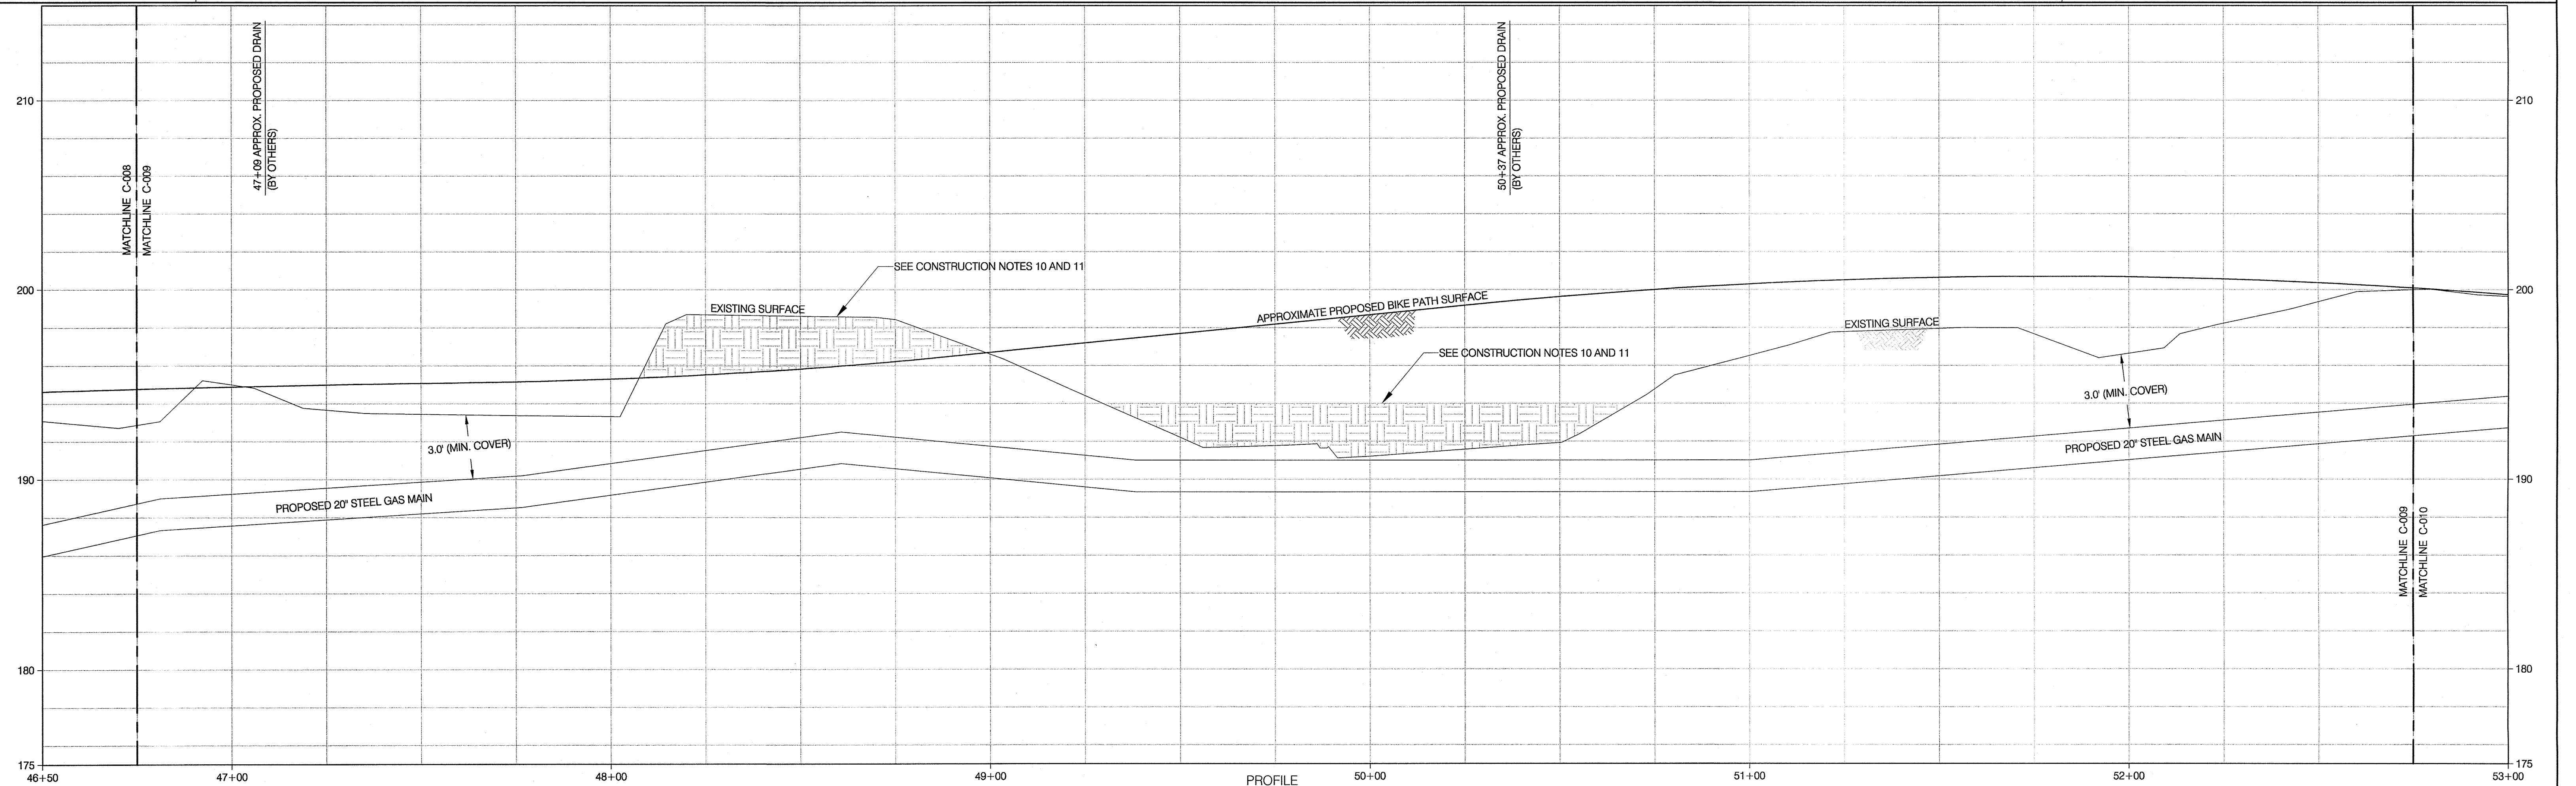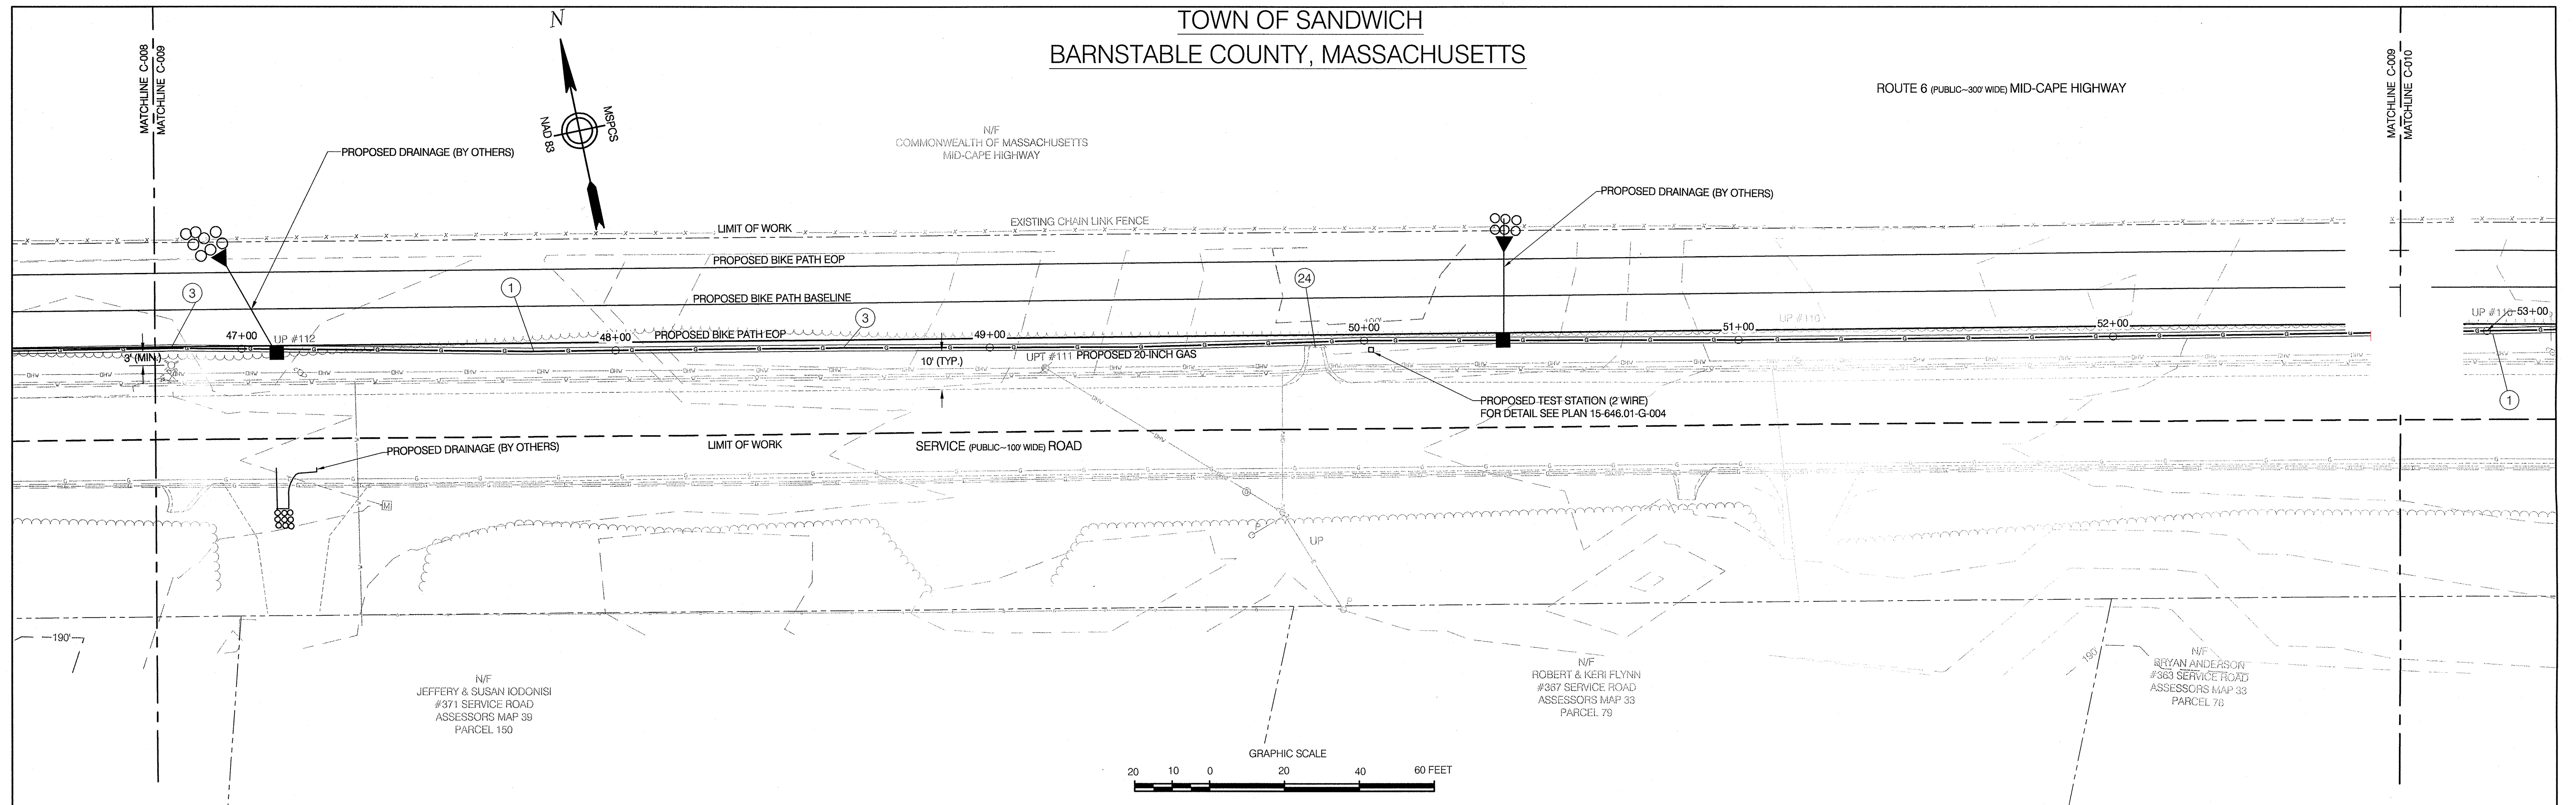

REFERENCE DRAWINGS


DRAWING NO.	TITLE	DRAWING NO.	TITLE

NO.	DATE	REVISIONS	REV.	CKD.	COR.	APP.
0	5/14	REVISED FOR FINAL EFSB APPROVAL	KDW	SAB	KDW	JEO

PROFILE
HOR. SCALE: 1"=20' VER. SCALE: 1"=4'



Design/Engineering
Prepared For:
COLONIAL GAS COMPANY
d/b/a
nationalgrid
GAS ENGINEERING DEPARTMENT
40 SILVER RD
WALTHAM, MA 02451


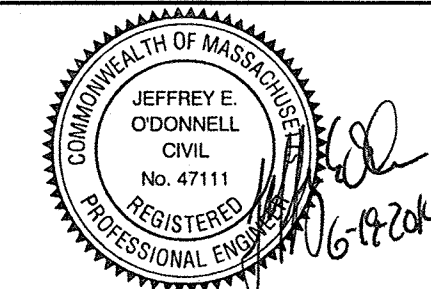


NATIONAL GRID SERVICE COMPANY, USA
SERVICE ROAD ALIGNMENT
SANDWICH, MA
BARNSTABLE COUNTY, MASSACHUSETTS
File No.: 15-646.01 ALIGN.dwg


APPROVED BY
DATE: SEPTEMBER 7, 2012
MANAGER
NATIONAL GRID SERVICE COMPANY, USA
15-646.01-C-009

N/F
COMMONWEALTH OF MASSACHUSETTS
MID-CAPE HIGHWAY

ROUTE 6 (PUBLIC~300' WIDE) MID-CAPE HIGHWAY

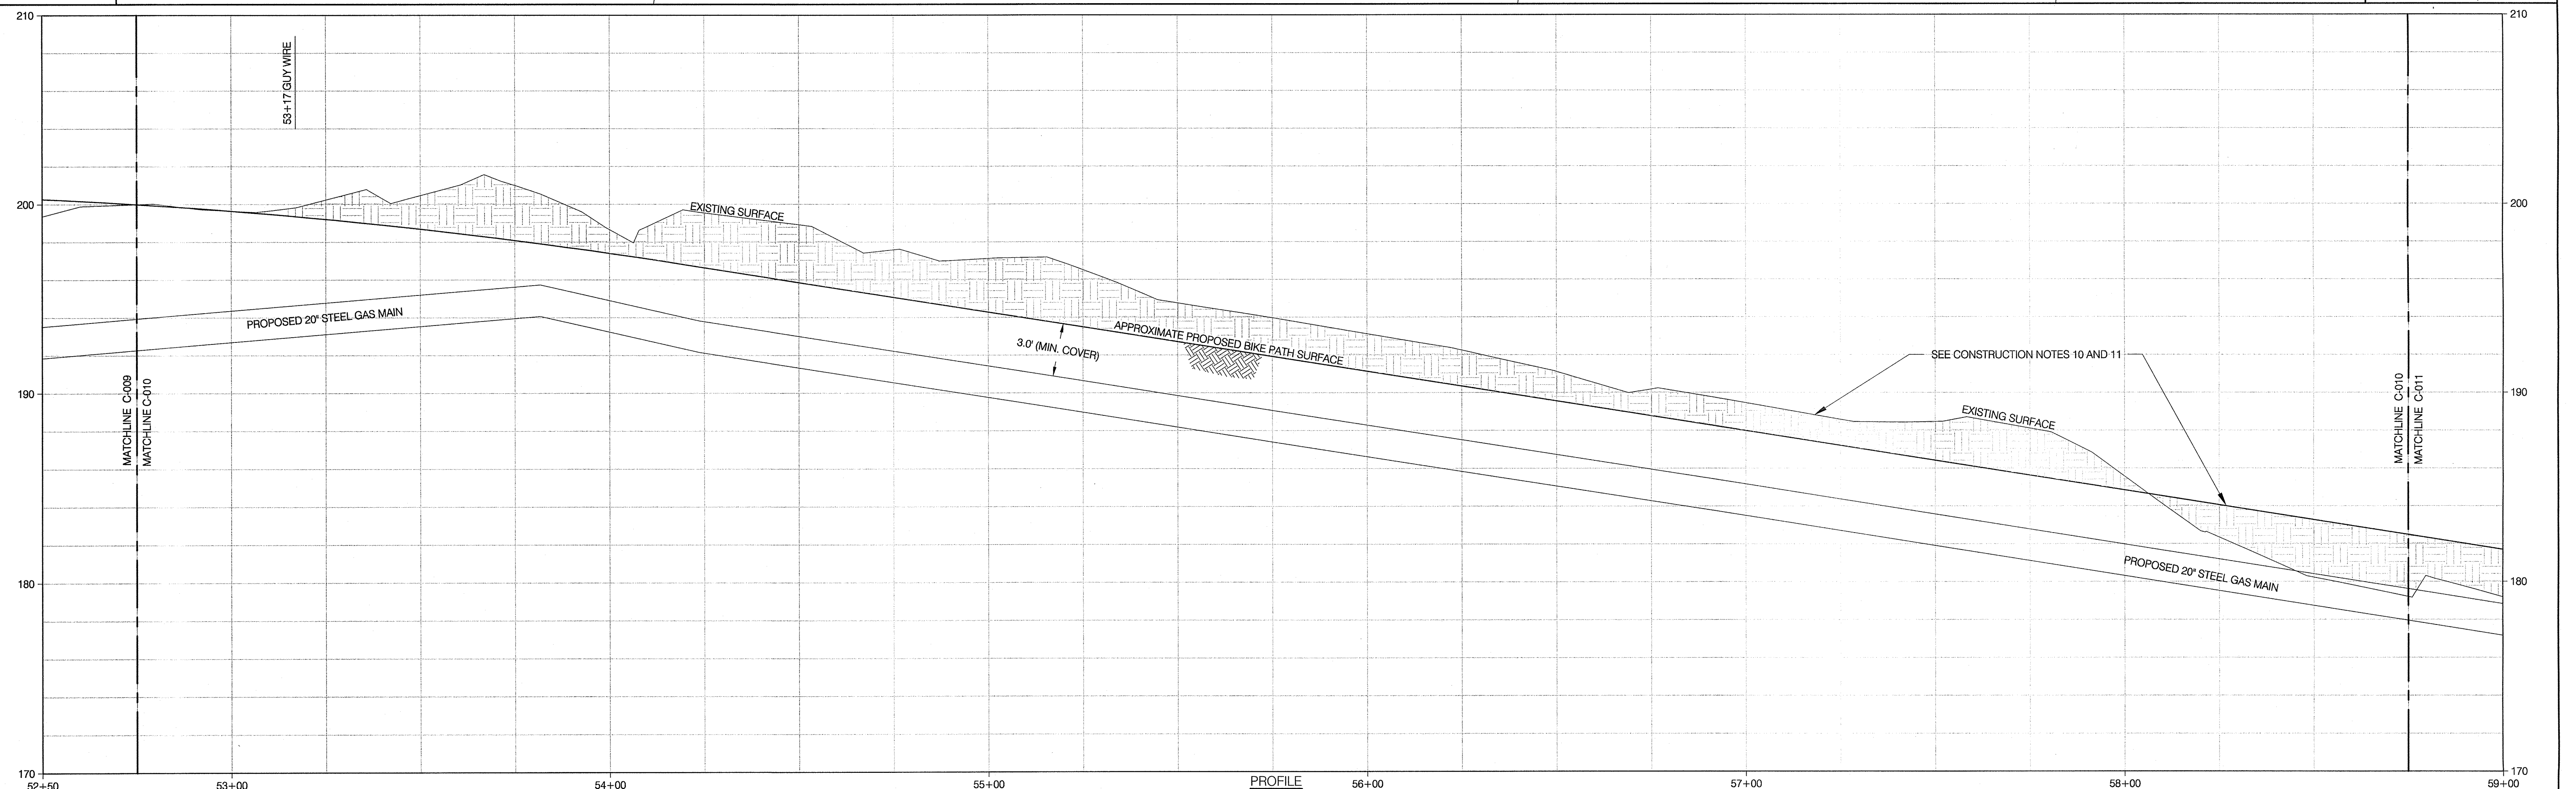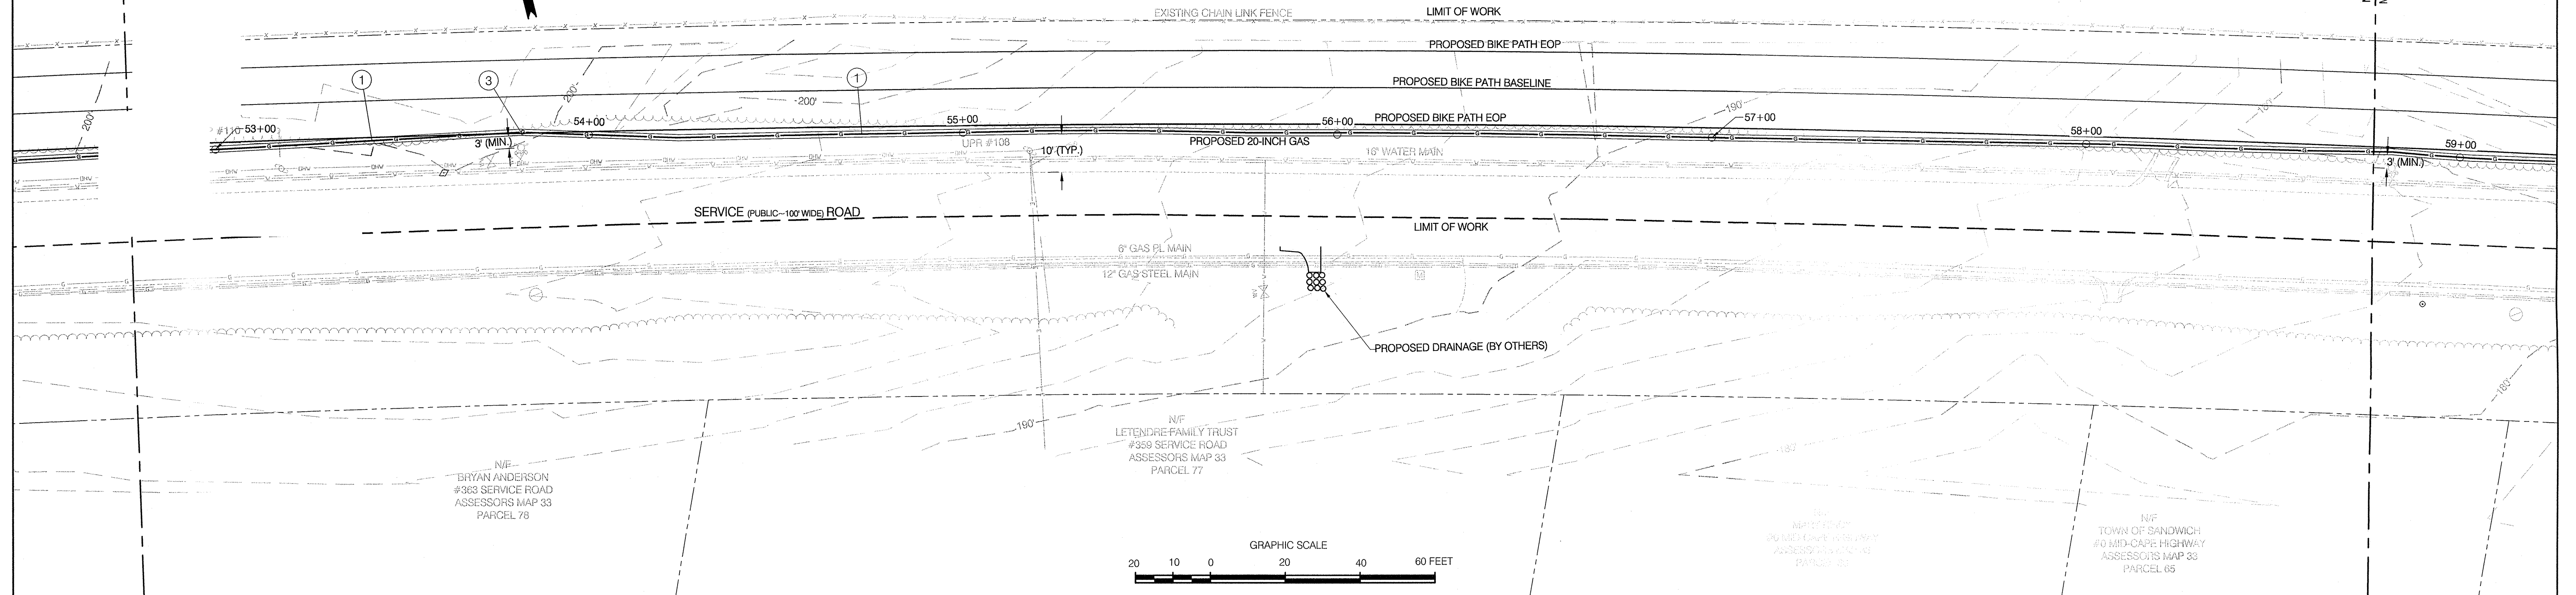[illegible]



DATE: 12/20/2010 DESIGN/ENGINEERING 	PREPARED FOR: COLONIAL GAS COMPANY d/b/a nationalgrid GAS ENGINEERING DEPARTMENT 40 SYLVAN RD. WALTHAM, MA 02451
---	---

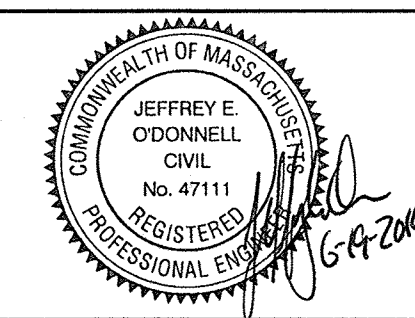

NATIONAL GRID SERVICE COMPANY, USA
SERVICE ROAD ALIGNMENT
SANDWICH, MA
BARNSTABLE COUNTY, MASSACHUSETTS
File No.: 15-646.01 ALIGN.dwg

APPROVED BY	
DATE: SEPTEMBER 7, 2011	MANAGER
NATIONAL GRID SERVICE COMPANY, USA	
15-646.01-C-010	

TOWN OF SANDWICH
BARNSTABLE COUNTY, MASSACHUSETTS

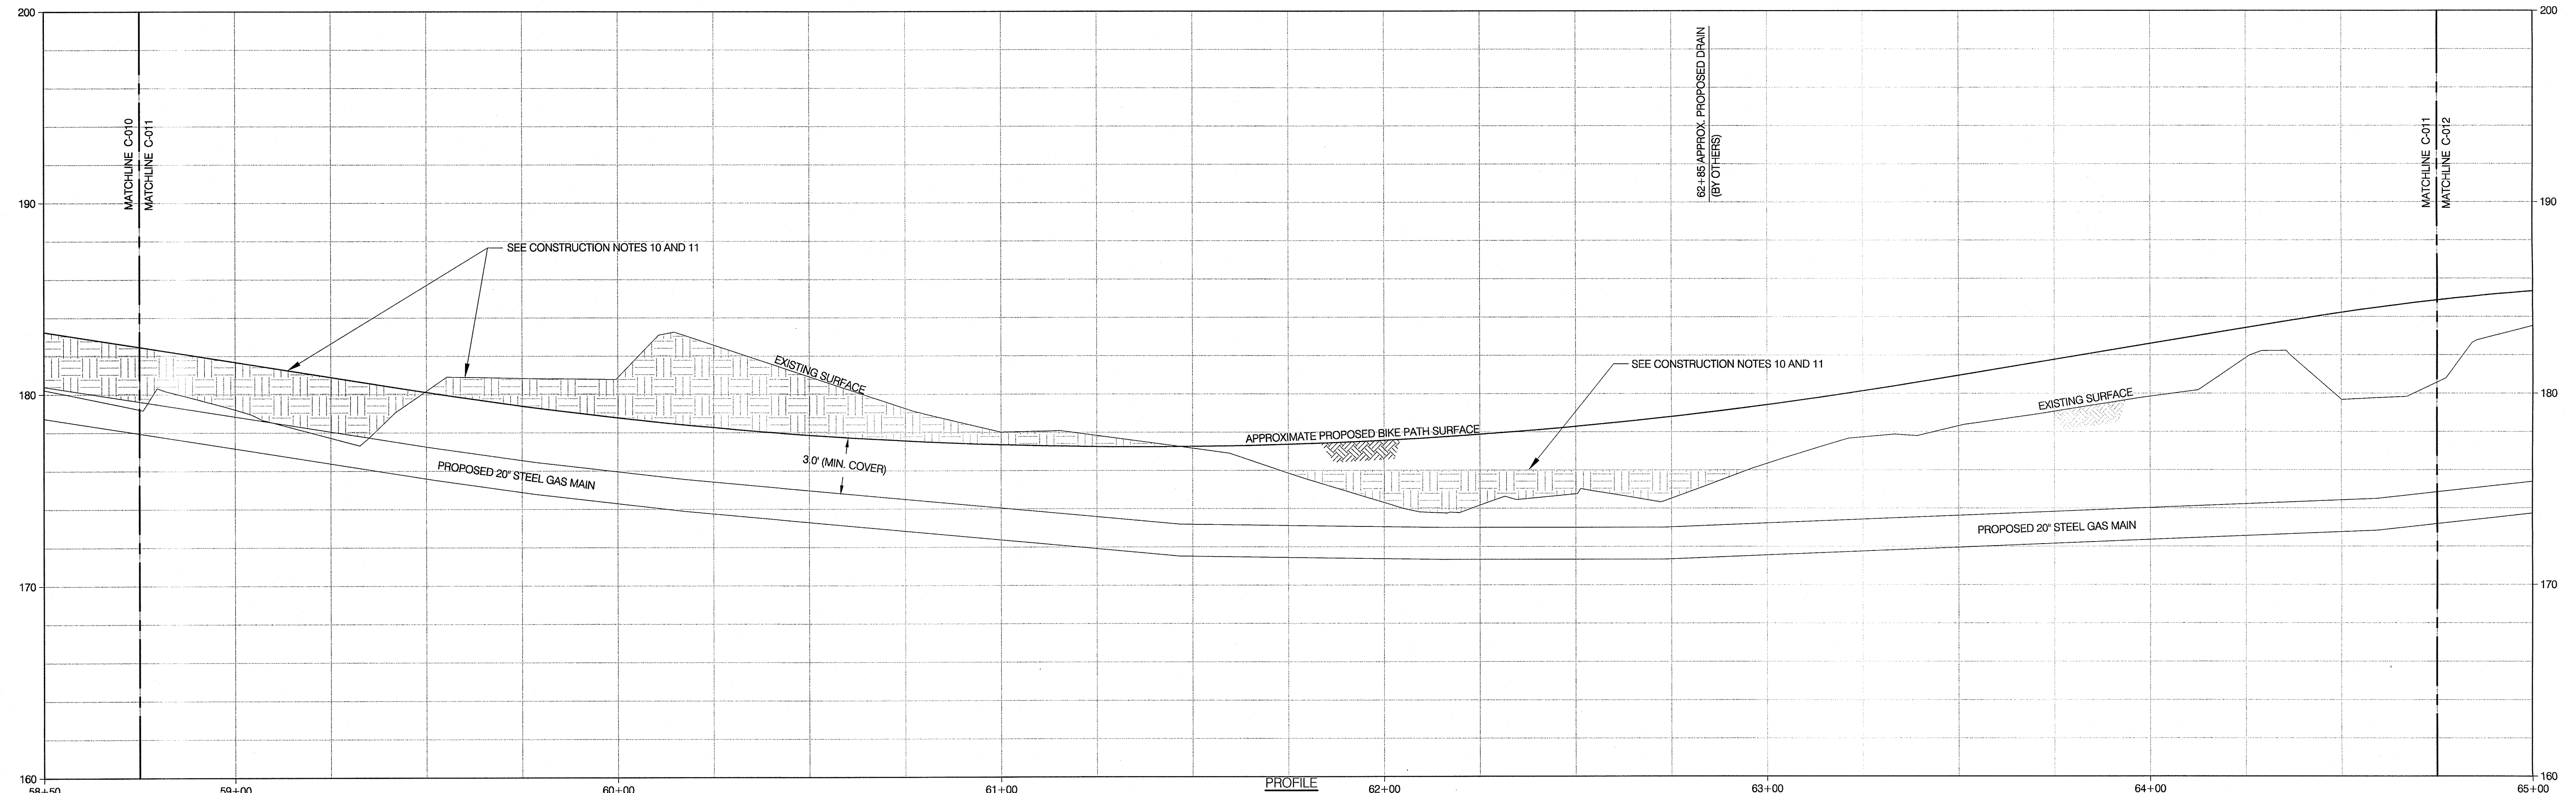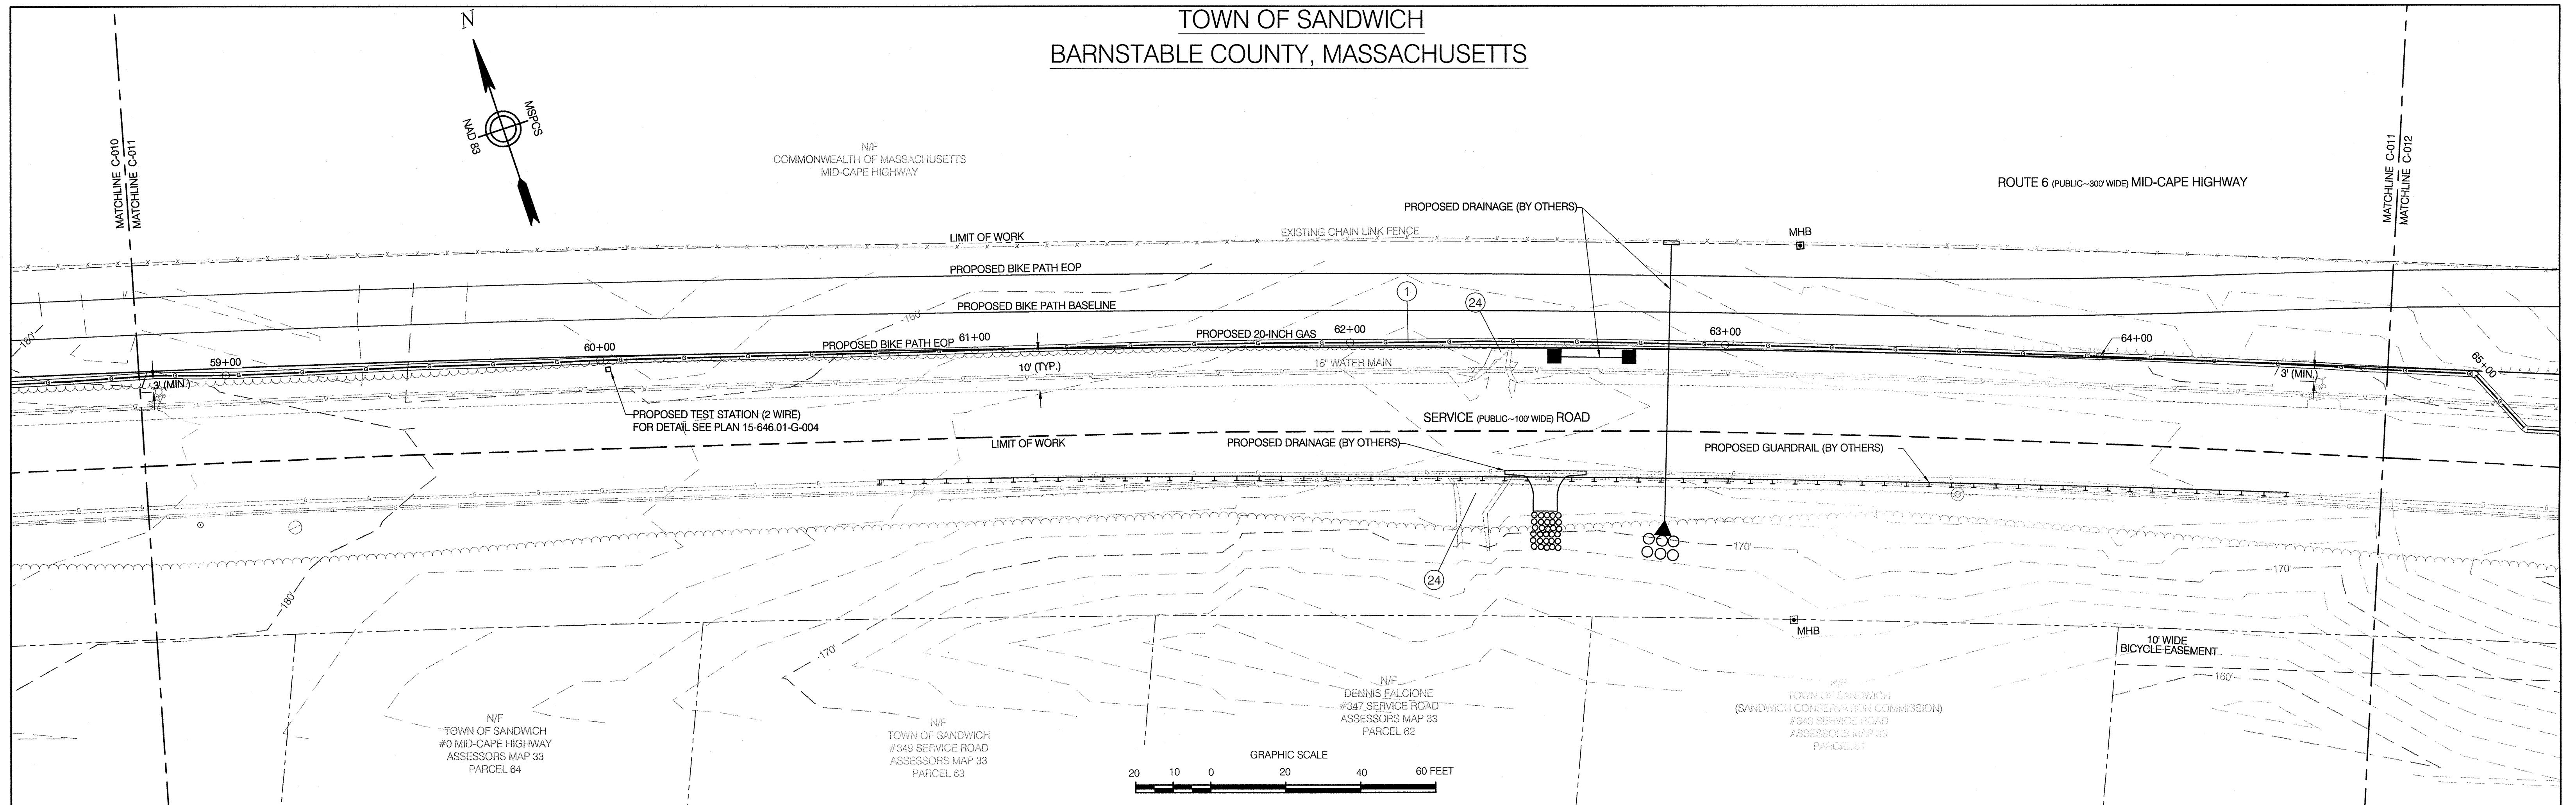

File: W:\NATIONAL GRID\2011 RFP 01\01 SANDWICH\DRAWINGS\15-646.01 ALIGN 1-23_REV 0 (ISSUED FOR FINAL EFSB APPROVAL).DWG
Saved: 6/18/2014 1:41:05 PM Plotted: 6/18/2014 1:50:52 PM User: Wentworth, Kevin LastSavedBy: 4340


REFERENCE DRAWINGS				REVISIONS						
DRAWING NO.	TITLE	DRAWING NO.	TITLE	NO.	DATE	REMARKS	REV.	CKD.	COR.	APP.
				0	6/14	REVISED FOR FINAL EFSB APPROVAL	KDW	SAB	KDW	JEO

PROFILE
HOR. SCALE: 1"=20' VER. SCALE: 1"=4'

Design/Engineering Prepared For:

CHIA
330 Bear Hill Road, Suite 304
Waltham, MA 02451
Main: (781) 962-7650 • www.chiacompanies.com



COLONIAL GAS COMPANY
d/b/a
nationalgrid
GAS ENGINEERING DEPARTMENT
40 SILVER HILL
WALTHAM, MA 02451

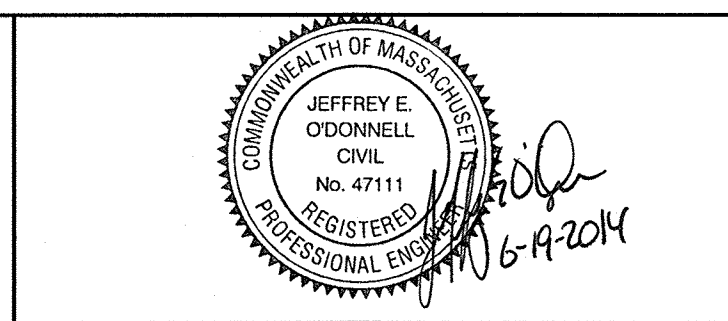

NATIONAL GRID SERVICE COMPANY, USA
SERVICE ROAD ALIGNMENT
SANDWICH, MA
BARNSTABLE COUNTY, MASSACHUSETTS
File No.: 15-646.01 ALIGN.dwg

APPROVED BY
DATE: SEPTEMBER 7, 2012
MANAGER
NATIONAL GRID SERVICE COMPANY, USA
15-646.01-C-011

A diagram of a magnetic compass rose. It features a circle with a cross inside, representing the compass. The top of the circle is labeled 'N' for North. The bottom of the circle is labeled 'MS' for Magnetic South. The left side of the circle is labeled 'ND 83' for North Divergence. The right side of the circle is labeled 'MS' for Magnetic South. The compass rose is oriented vertically, with North at the top and Magnetic South at the bottom.

  

Design/Engineering



CI LA

330 Bear Hill Road, Suite 304
Waltham, MA 02451
Main: (781) 982-7650 • www.chaco.com

NATIONAL GRID SERVICE COMPANY, USA SERVICE ROAD ALIGNMENT SANDWICH, MA BARNSTABLE COUNTY, MASSACHUSETTS	APPROVED BY
	DATE: SEPTEMBER 7, 2012 MANAGER
	NATIONAL GRID SERVICE COMPANY, USA 15-646.01-C-012

File No.: 15-646.01 ALIGN.dwg



TOWN OF SANDWICH
BARNSTABLE COUNTY, MASSACHUSETTS

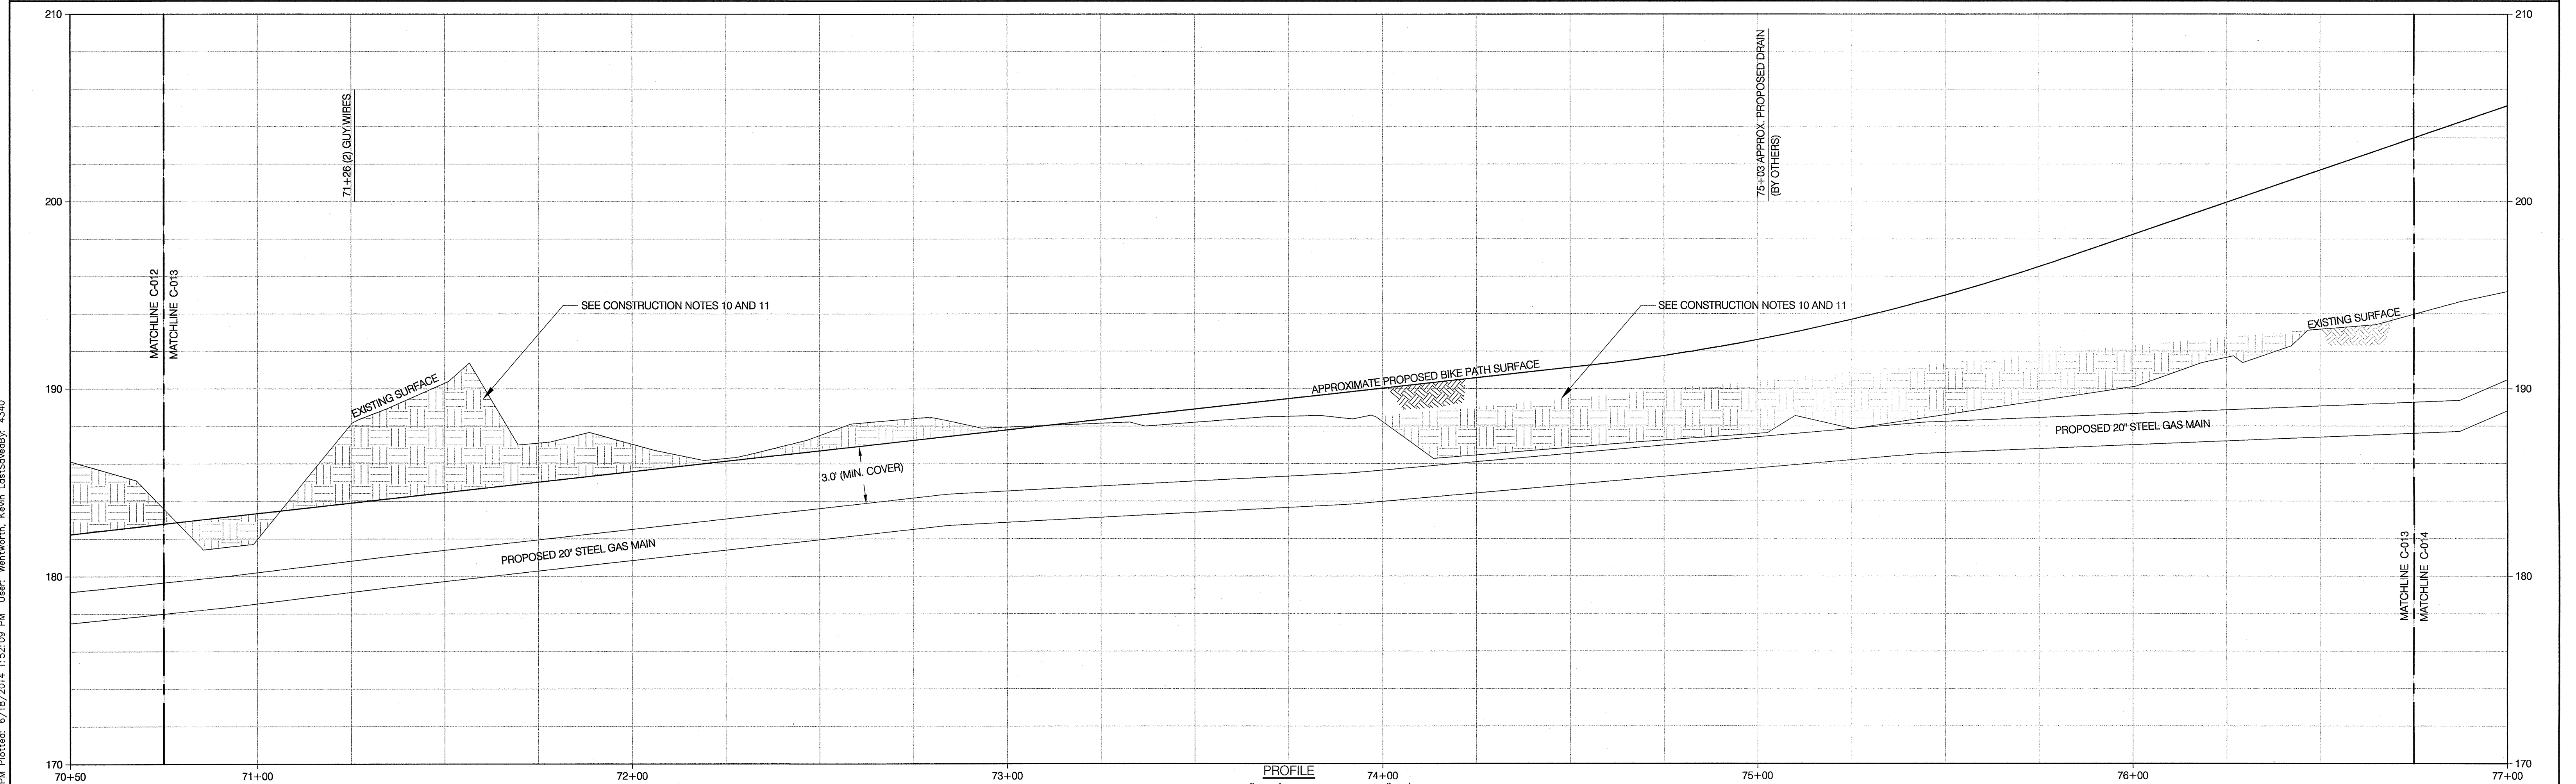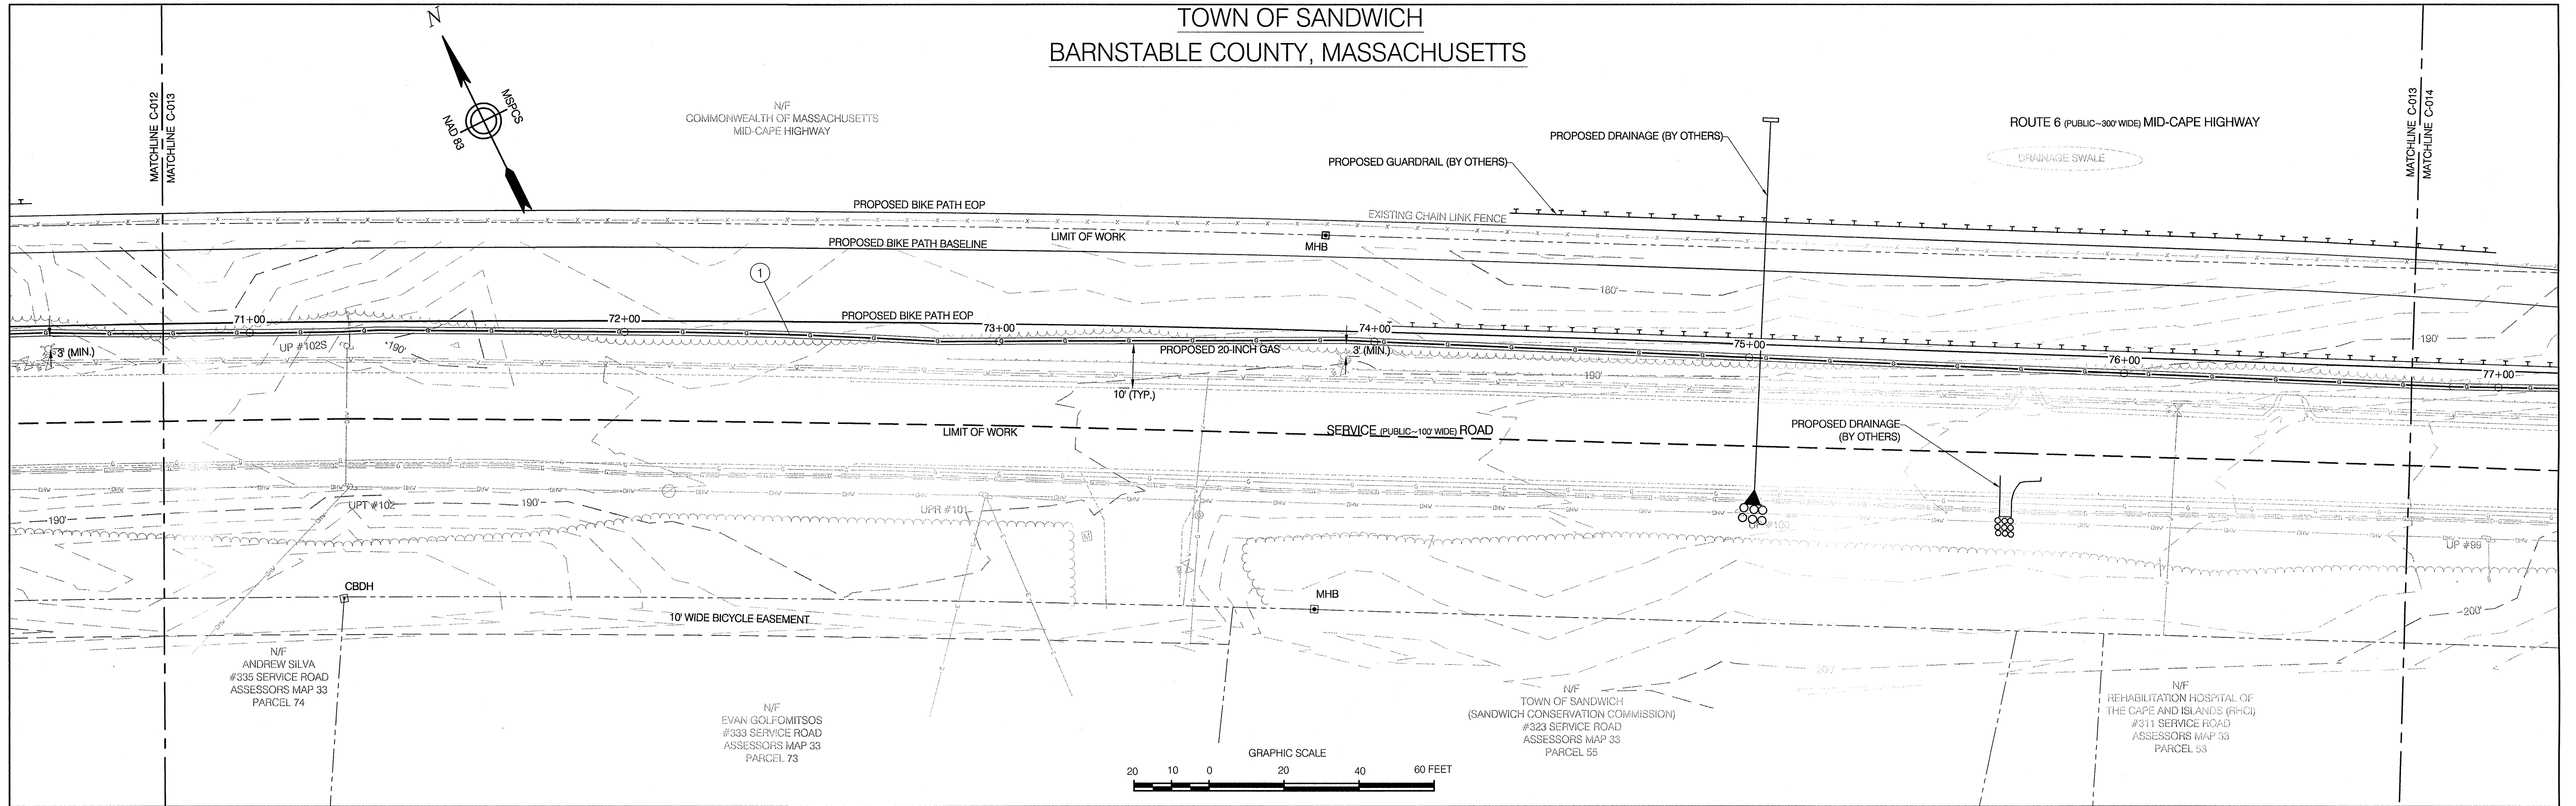

REFERENCE DRAWINGS				REVISIONS							
DRAWING NO.	TITLE	DRAWING NO.	TITLE	NO.	DATE	REMARKS	REV.	CKD.	COR.	APP.	
				0	6/14	REVISED FOR FINAL EFSB APPROVAL	KDW	SAB	KDW	JEO	

CHA 330 Bear Hill Road, Suite 304 Waltham, MA 02451 Main: (781) 882-7650 • www.chacompanies.com		colonial gas company d/b/a nationalgrid GAS ENGINEERING DEPARTMENT 45 SILVER RD. WALTHAM, MA 02451		NATIONAL GRID SERVICE COMPANY, USA SERVICE ROAD ALIGNMENT SANDWICH, MA BARNSTABLE COUNTY, MASSACHUSETTS File No.: 15-646.01 ALIGN.dwg		APPROVED BY DATE: SEPTEMBER 7, 2012 MANAGER NATIONAL GRID SERVICE COMPANY, USA 15-646.01-C-013	
---	--	--	--	---	--	--	--

TOWN OF SANDWICH
BARNSTABLE COUNTY, MASSACHUSETTS

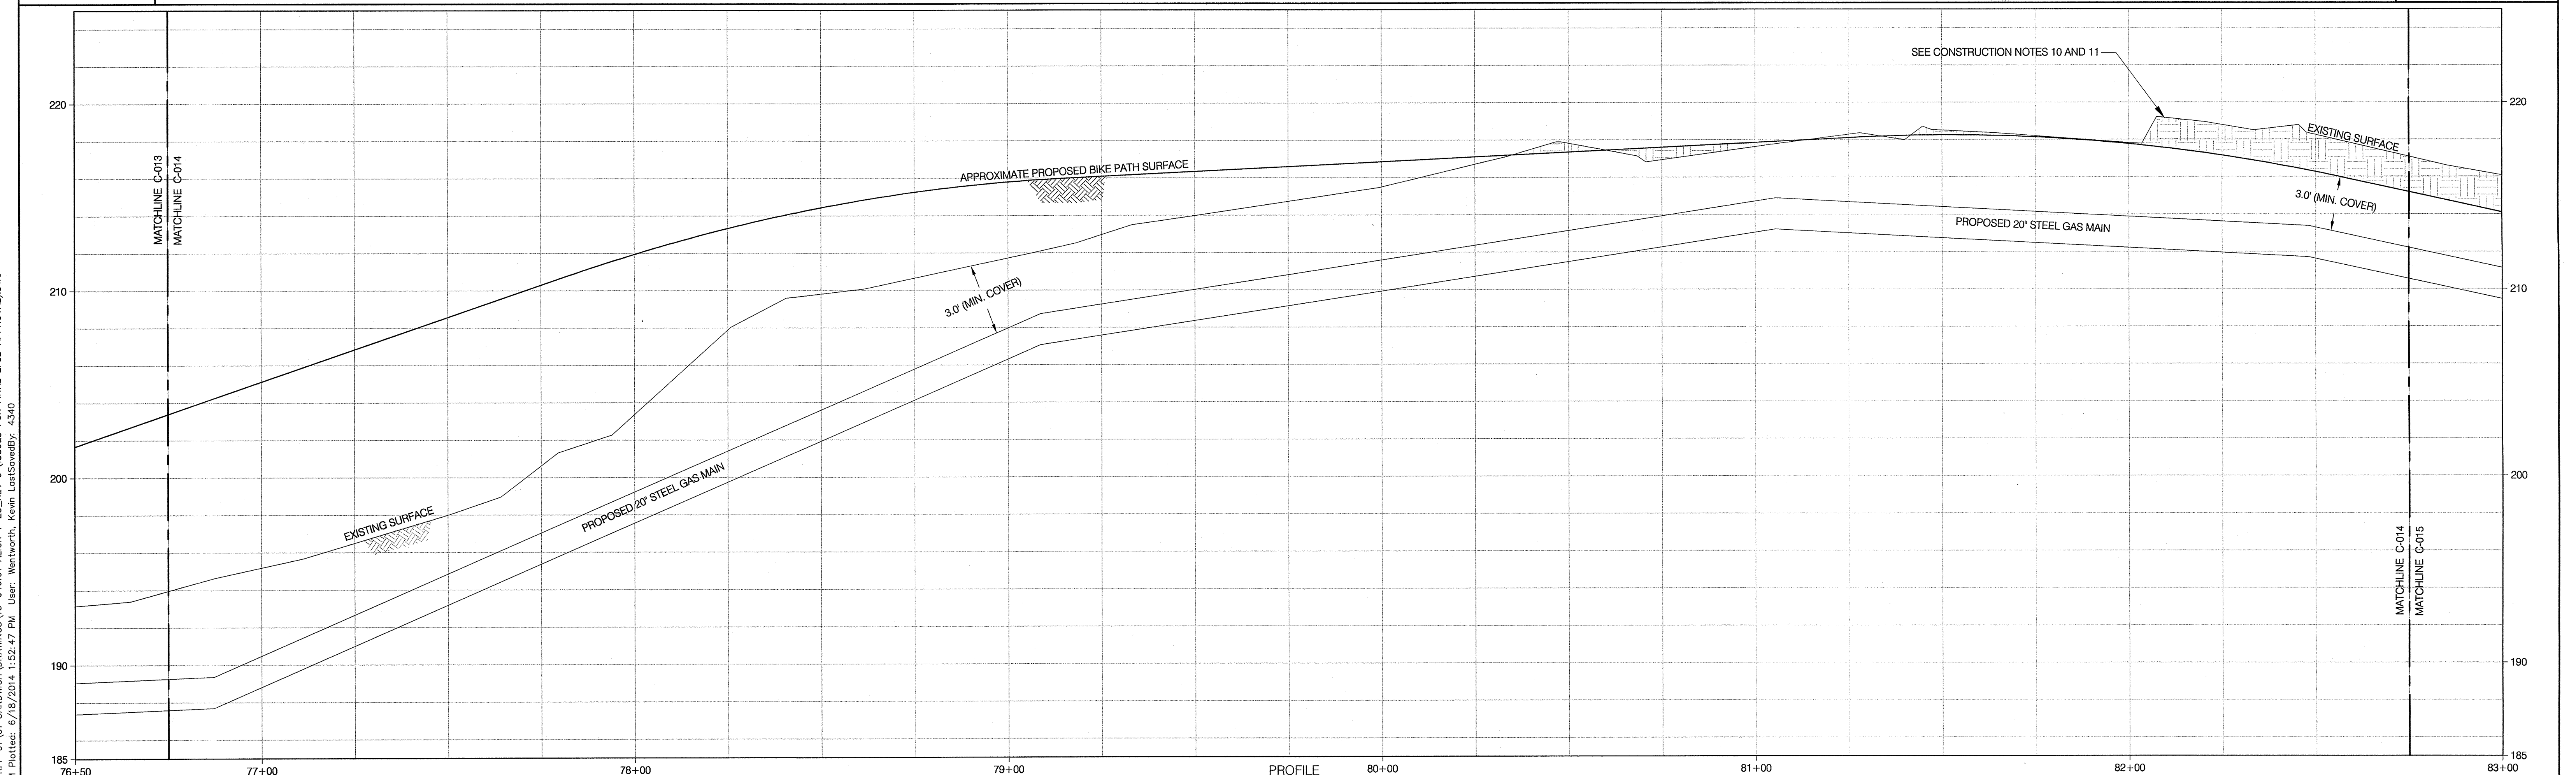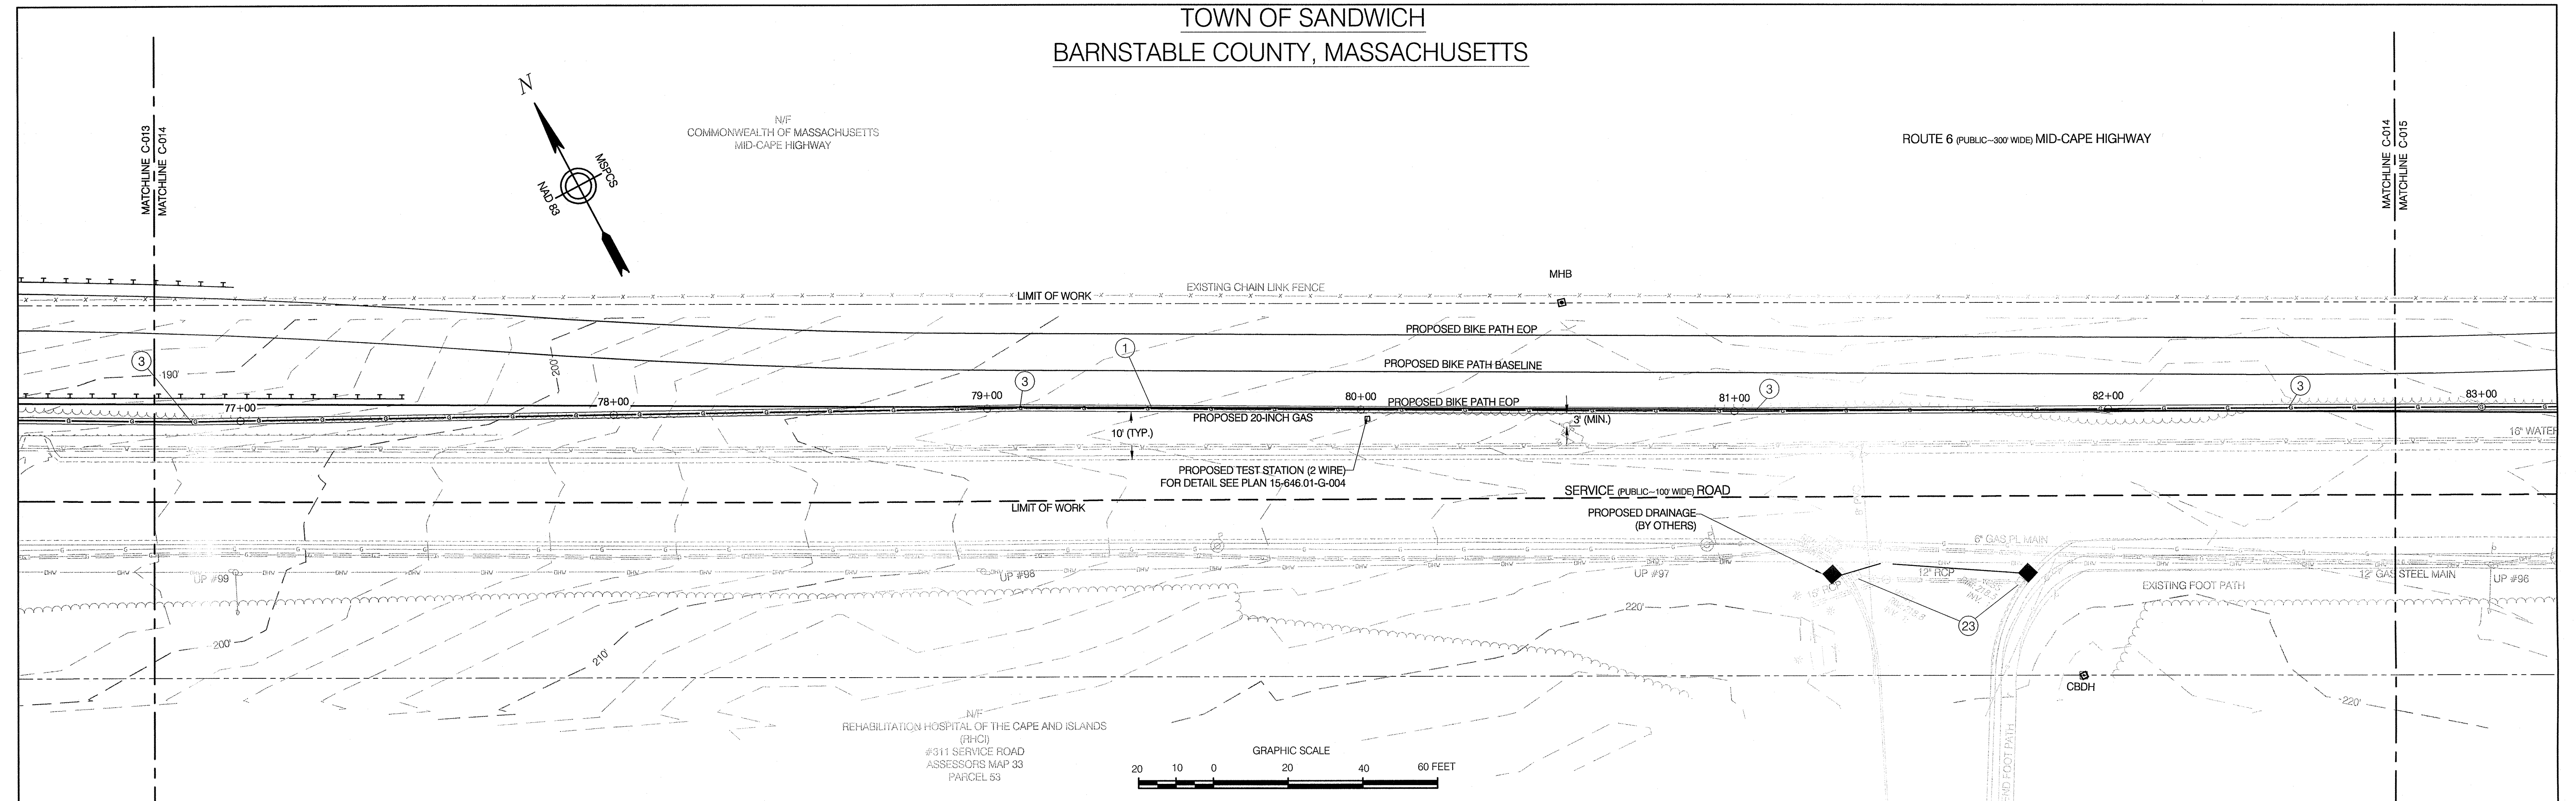

REFERENCE DRAWINGS				REVISIONS						
DRAWING NO.	TITLE	DRAWING NO.	TITLE	NO.	DATE	REMARKS	REV.	CKD.	COR.	APP.
				0	6/14	REVISED FOR FINAL EFSB APPROVAL	KDW	SAB	KDW	JEO

Design/Engineering

Prepared For:

nationalgrid

330 Bear Hill Road, Suite 304
Waltham, MA 02451
Main: (781) 962-7650 • www.chacompanies.com

COLONIAL GAS COMPANY
d/b/a
nationalgrid
GAS ENGINEERING DEPARTMENT
40 SILVER RD.
WALTHAM, MA 02451



JEFFREY E. O'DONNELL
CIVIL
No. 47111
REGISTERED
PROFESSIONAL ENGINEER
6-19-2014

NATIONAL GRID SERVICE COMPANY, USA
SERVICE ROAD ALIGNMENT
SANDWICH, MA
BARNSTABLE COUNTY, MASSACHUSETTS
File No.: 15-646.01 ALIGN.dwg

APPROVED BY
DATE: SEPTEMBER 7, 2012
MANAGER
NATIONAL GRID SERVICE COMPANY, USA
15-646.01-C-014

File: W:\NATIONAL GRID\2011 RFP 01\01 SANDWICH\DRAWINGS\15-646.01 ALIGN 1-23_REV 0 (ISSUED FOR FINAL EFSB APPROVAL).DWG
Saved: 6/18/2014 1:41:05 PM Plotted: 6/18/2014 1:52:47 PM User: Wentworth, Kevin LastSavedBy: 4340



TOWN OF SANDWICH
BARNSTABLE COUNTY, MASSACHUSETTS

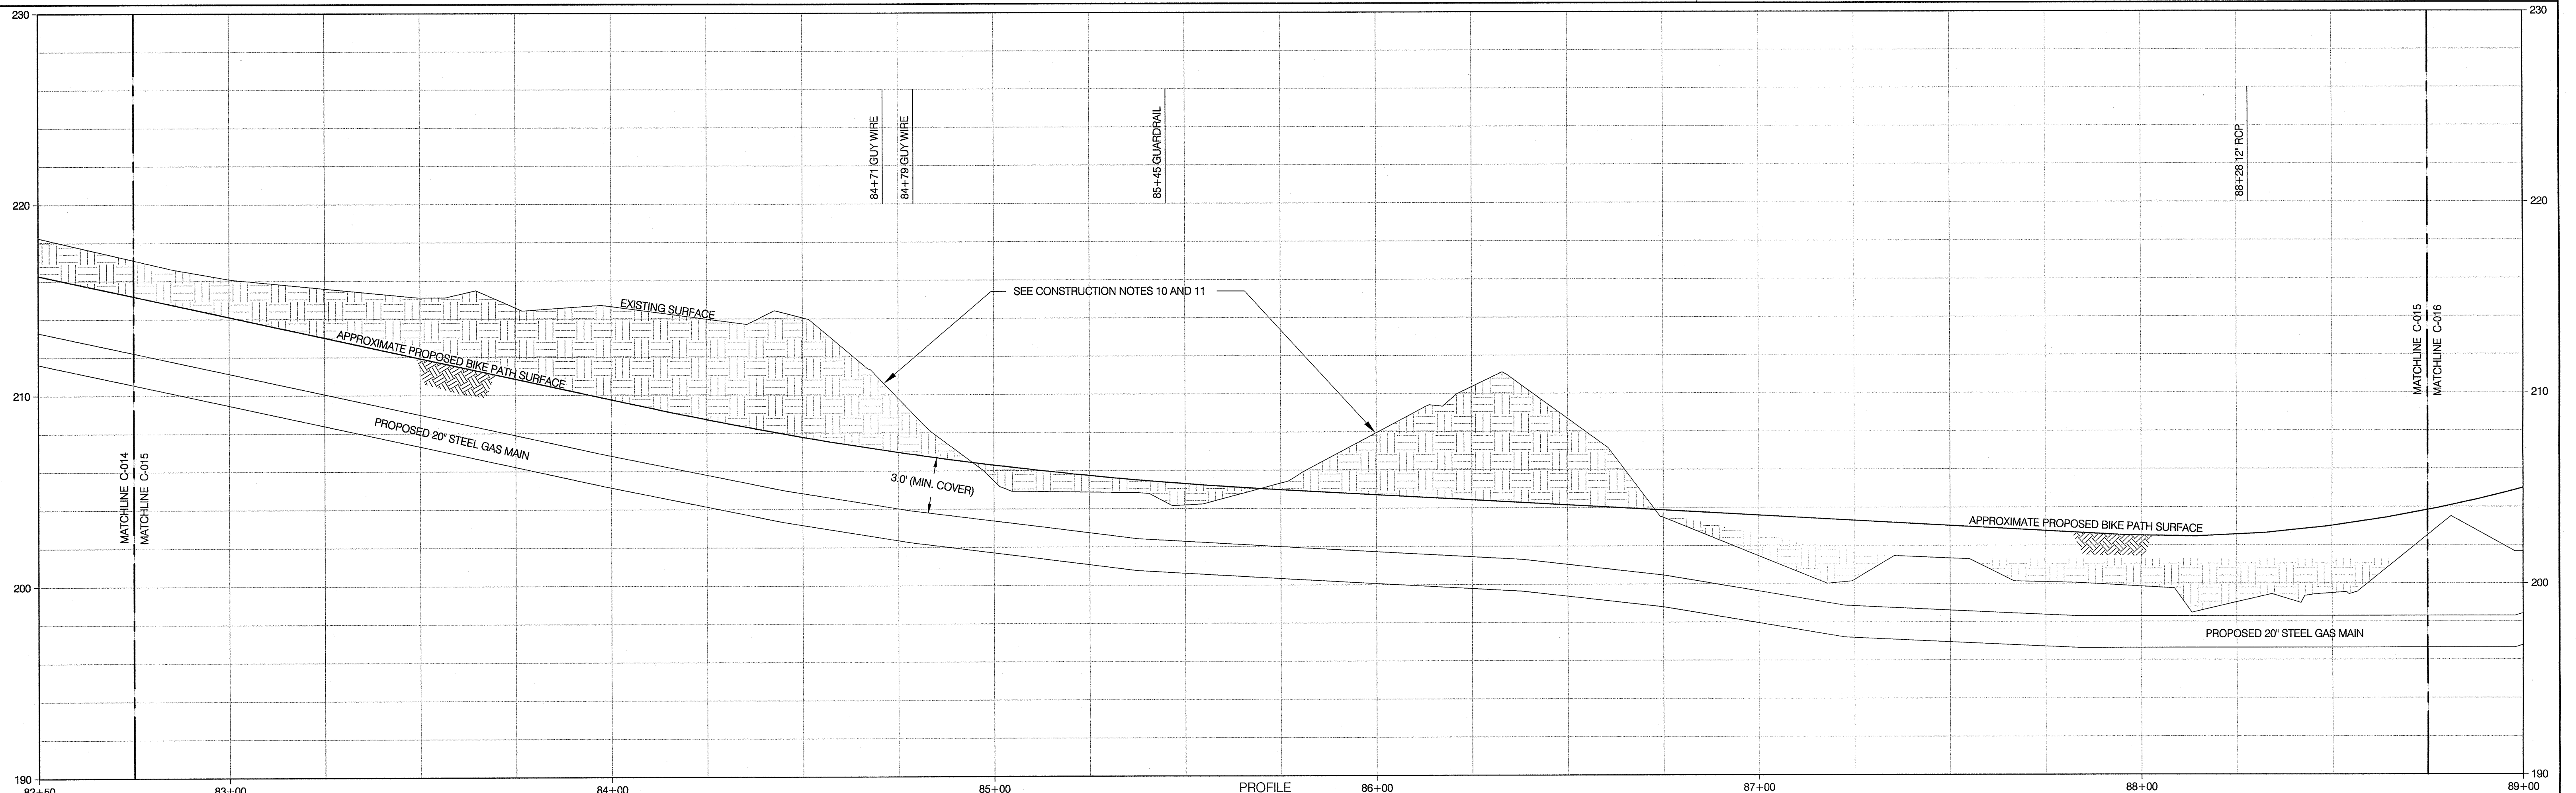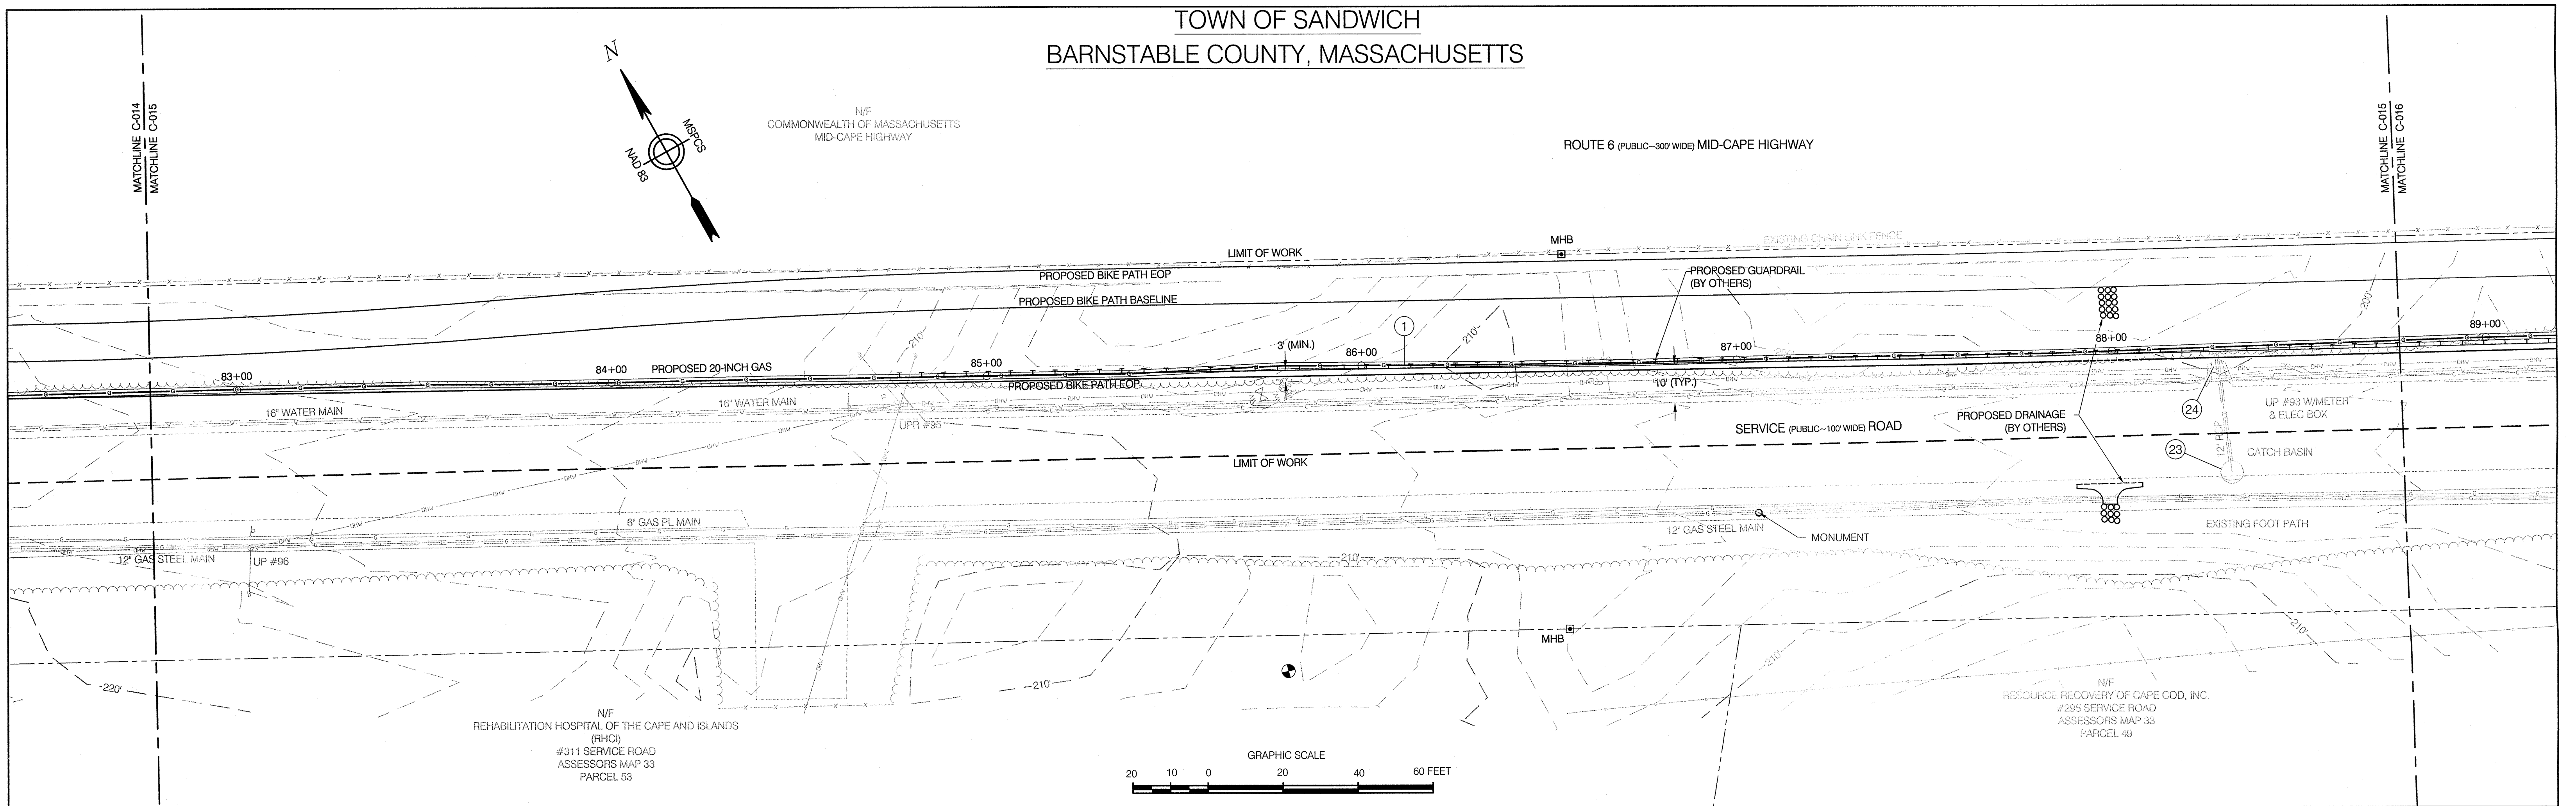

REFERENCE DRAWINGS				REVISIONS							
DRAWING NO.	TITLE	DRAWING NO.	TITLE	NO.	DATE	REMARKS	REV.	CKD.	COR.	APP.	
				0	6/14	REVISED FOR FINAL EFSB APPROVAL	KDW	SAB	KDW	JEG	

CHIA 330 Bear Hill Road, Suite 304 Waltham, MA 02451 Main: (781) 962-7650 • www.chiacompanies.com	Design/Engineering nationalgrid Prepared For: COLONIAL GAS COMPANY d/b/a GAS ENGINEERING DEPARTMENT 40 SYLVAN RD. WALTHAM, MA 02451	 JEFFREY E. O'DONNELL CIVIL No. 47111 REGISTERED PROFESSIONAL ENGINEER 6/19/2014	NATIONAL GRID SERVICE COMPANY, USA SERVICE ROAD ALIGNMENT SANDWICH, MA BARNSTABLE COUNTY, MASSACHUSETTS File No.: 15-646.01 ALIGN.dwg	APPROVED BY DATE: SEPTEMBER 7, 2012 MANAGER NATIONAL GRID SERVICE COMPANY, USA 15-646.01-C-015
---	---	---	--	---

 ROUTE 6 (PUBLIC-300' WIDE) MID-CAPE HIGHWAY

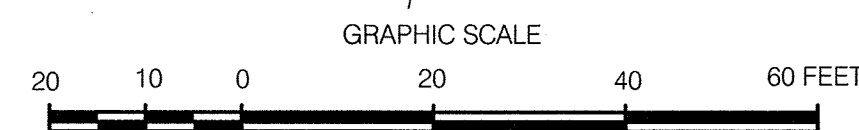



Design/Engineering

CHIA

330 Bear Hill Road, Suite 304
Waltham, MA 02451
Main: (781) 982-7650 • www.chiacompanies.com

APPROVED BY	
DATE: SEPTEMBER 7, 2012	MANAGER
NATIONAL GRID SERVICE COMPANY, USA	
15-646.01-C-016	

TOWN OF SANDWICH
BARNSTABLE COUNTY, MASSACHUSETTS

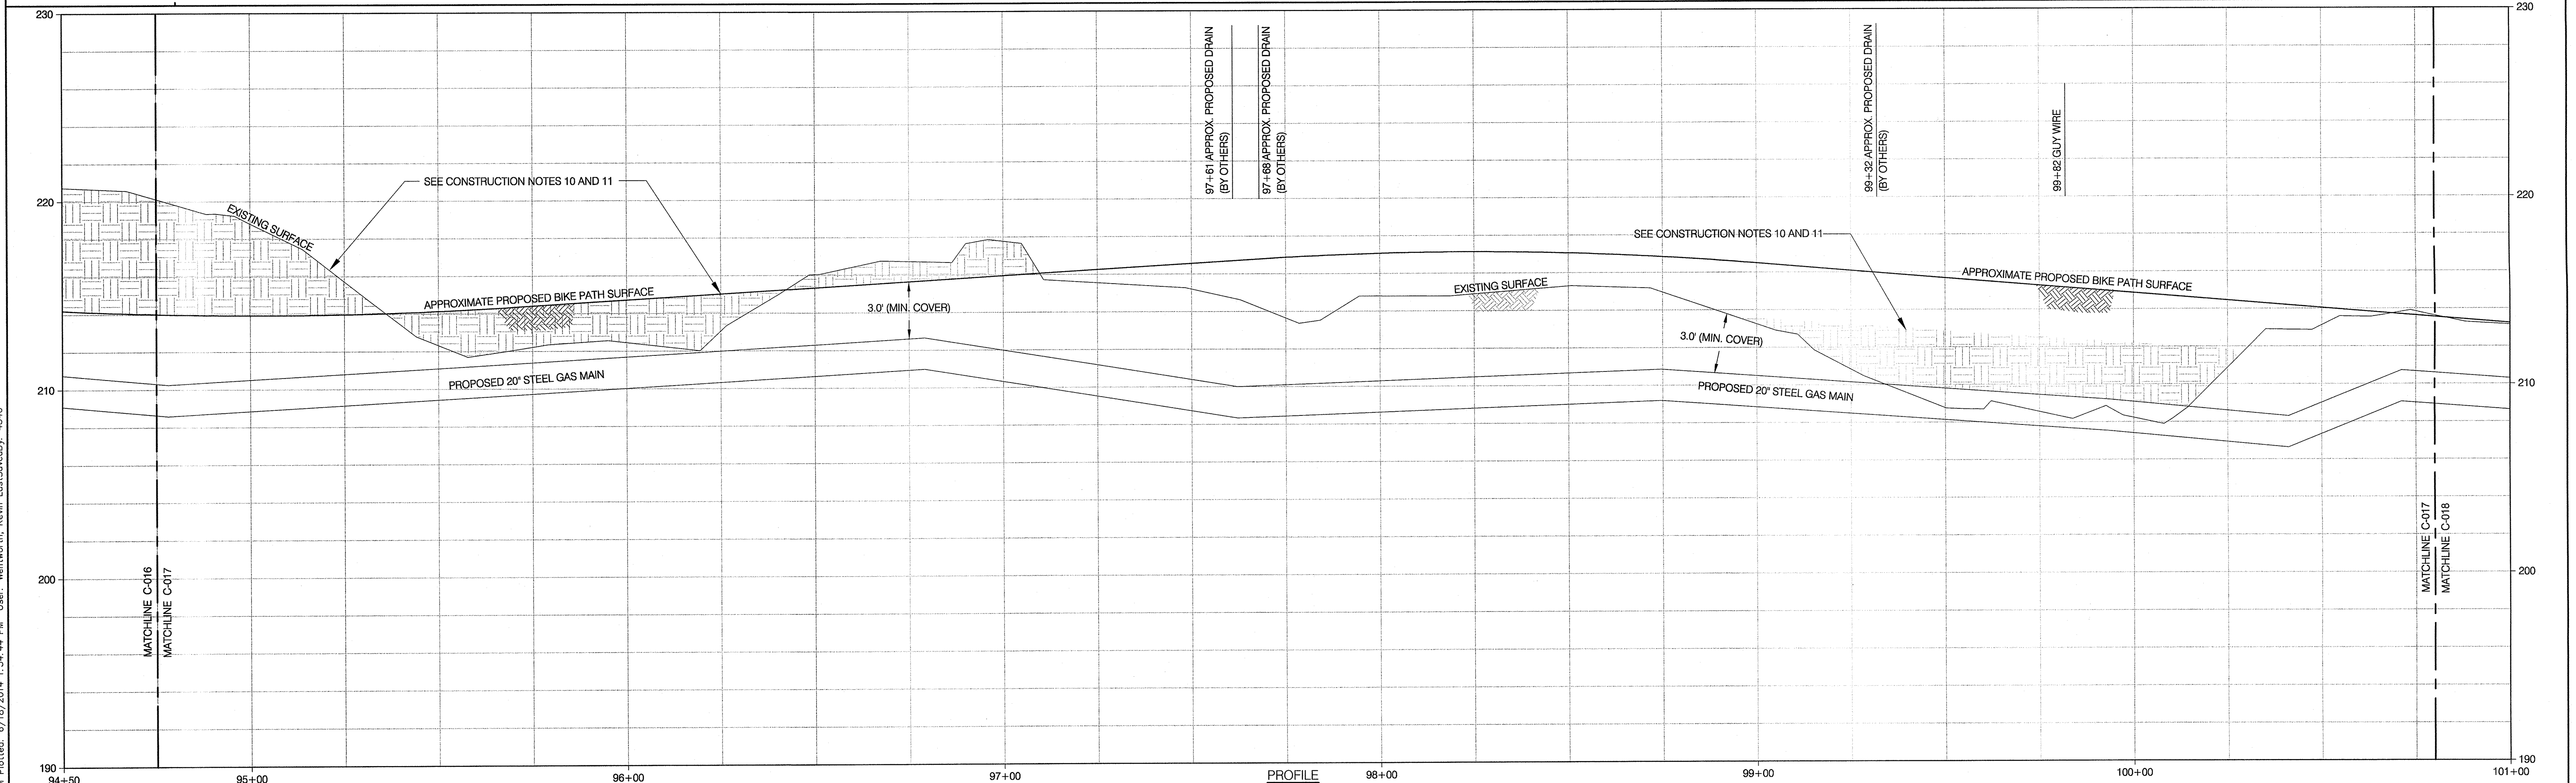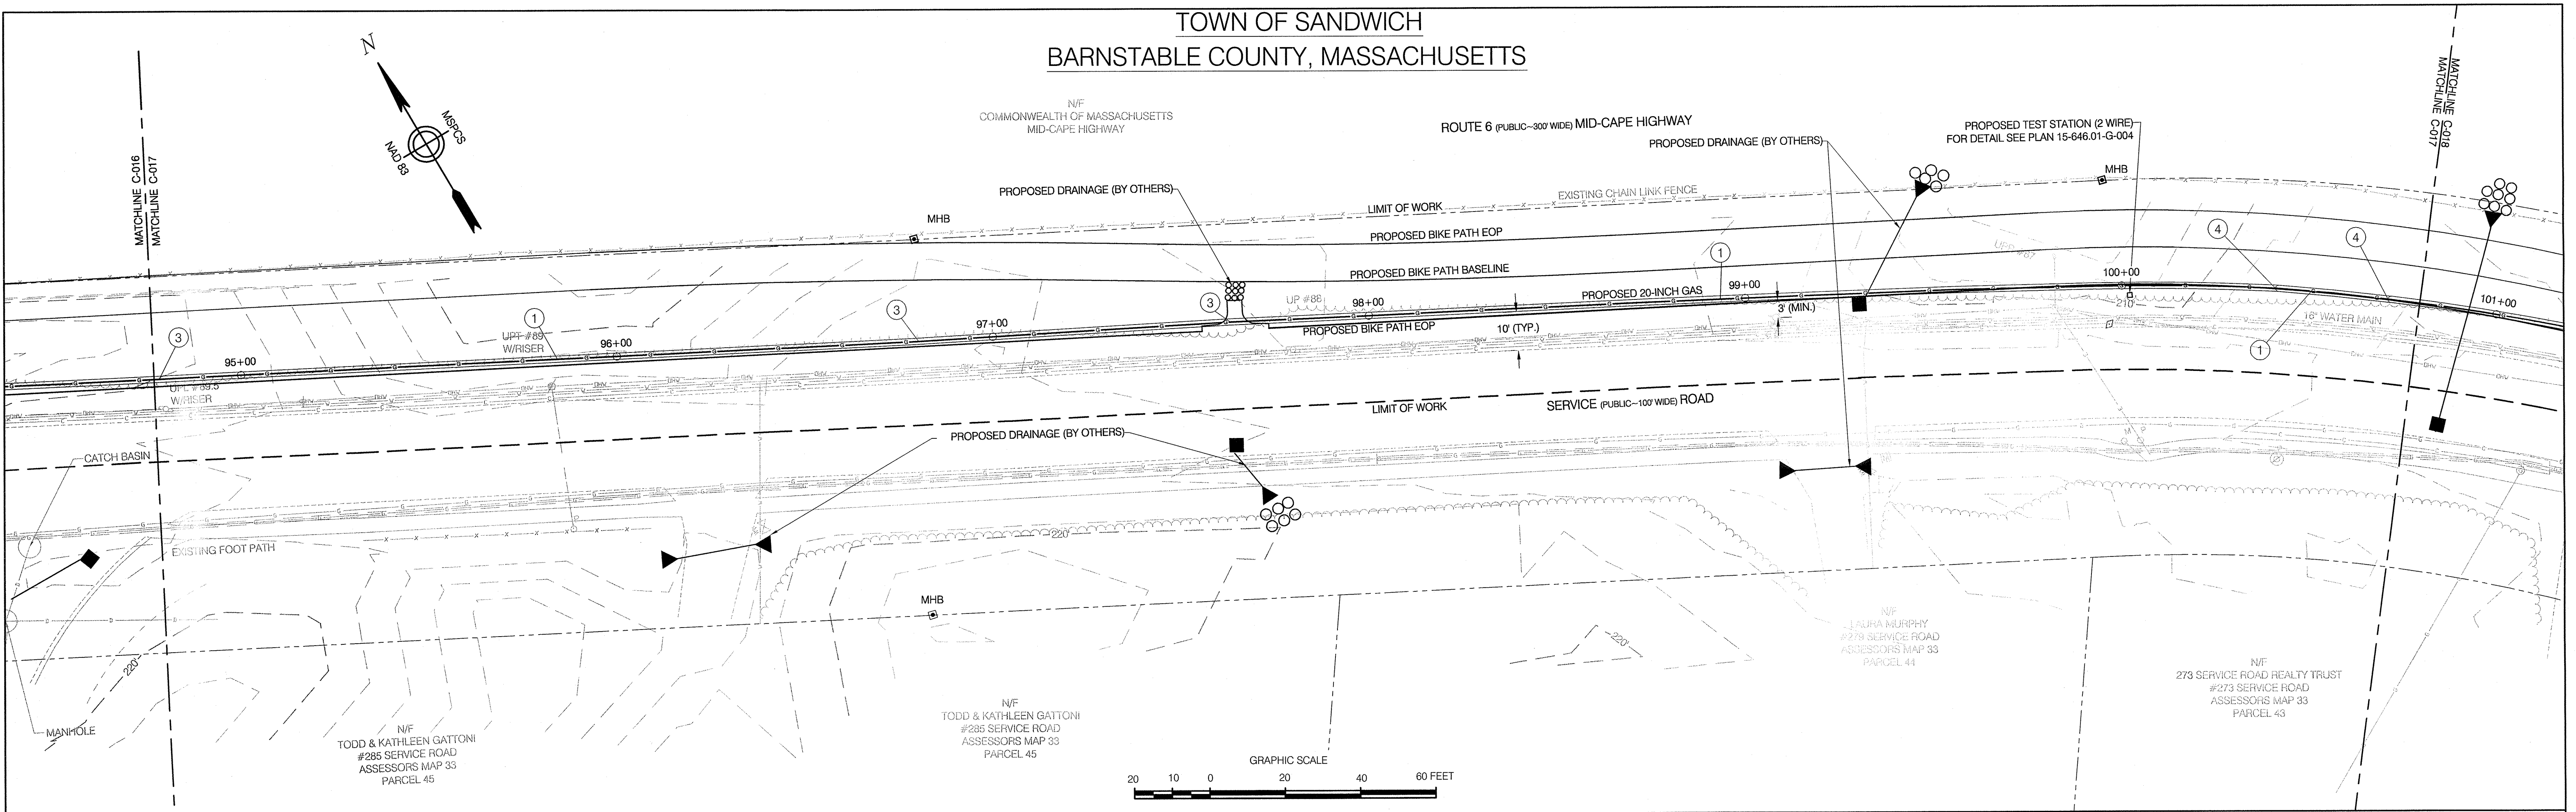



REFERENCE DRAWINGS				REVISIONS			
DRAWING NO.	TITLE	DRAWING NO.	TITLE	NO.	DATE	REMARKS	REV. CKD. COR. APP.
				0	6/14	REVISED FOR FINAL EFSB APPROVAL	KDW SAB KDW JEO

DESIGN/ENGINEERING		PREPARED FOR:	
CHIA		COLONIAL GAS COMPANY	
330 Bear Hill Road, Suite 304 Waltham, MA 02451 Main: (781) 862-7850 • www.chiacompanies.com		d/b/a nationalgrid GAS ENGINEERING DEPARTMENT 40 SYLVAN RD. WALTHAM, MA 02451	

NATIONAL GRID SERVICE COMPANY, USA SERVICE ROAD ALIGNMENT SANDWICH, MA BARNSTABLE COUNTY, MASSACHUSETTS		APPROVED BY DATE: SEPTEMBER 7, 2012 MANAGER NATIONAL GRID SERVICE COMPANY, USA	
File No.: 15-646.01 ALIGN.dwg		15-646.01-C-017	

File: W:\NATIONAL GRID\2011 RFP 01\01 SANDWICH\DRAWINGS\15-646.01 ALIGN 1-23_REV 0 (ISSUED FOR FINAL EFSB APPROVAL).DWG
Saved: 6/18/2014 1:41:05 PM Plotted: 6/18/2014 1:54:44 PM User: Wentworth, Kevin LastSavedBy: 4340

TOWN OF SANDWICH
BARNSTABLE COUNTY, MASSACHUSETTS

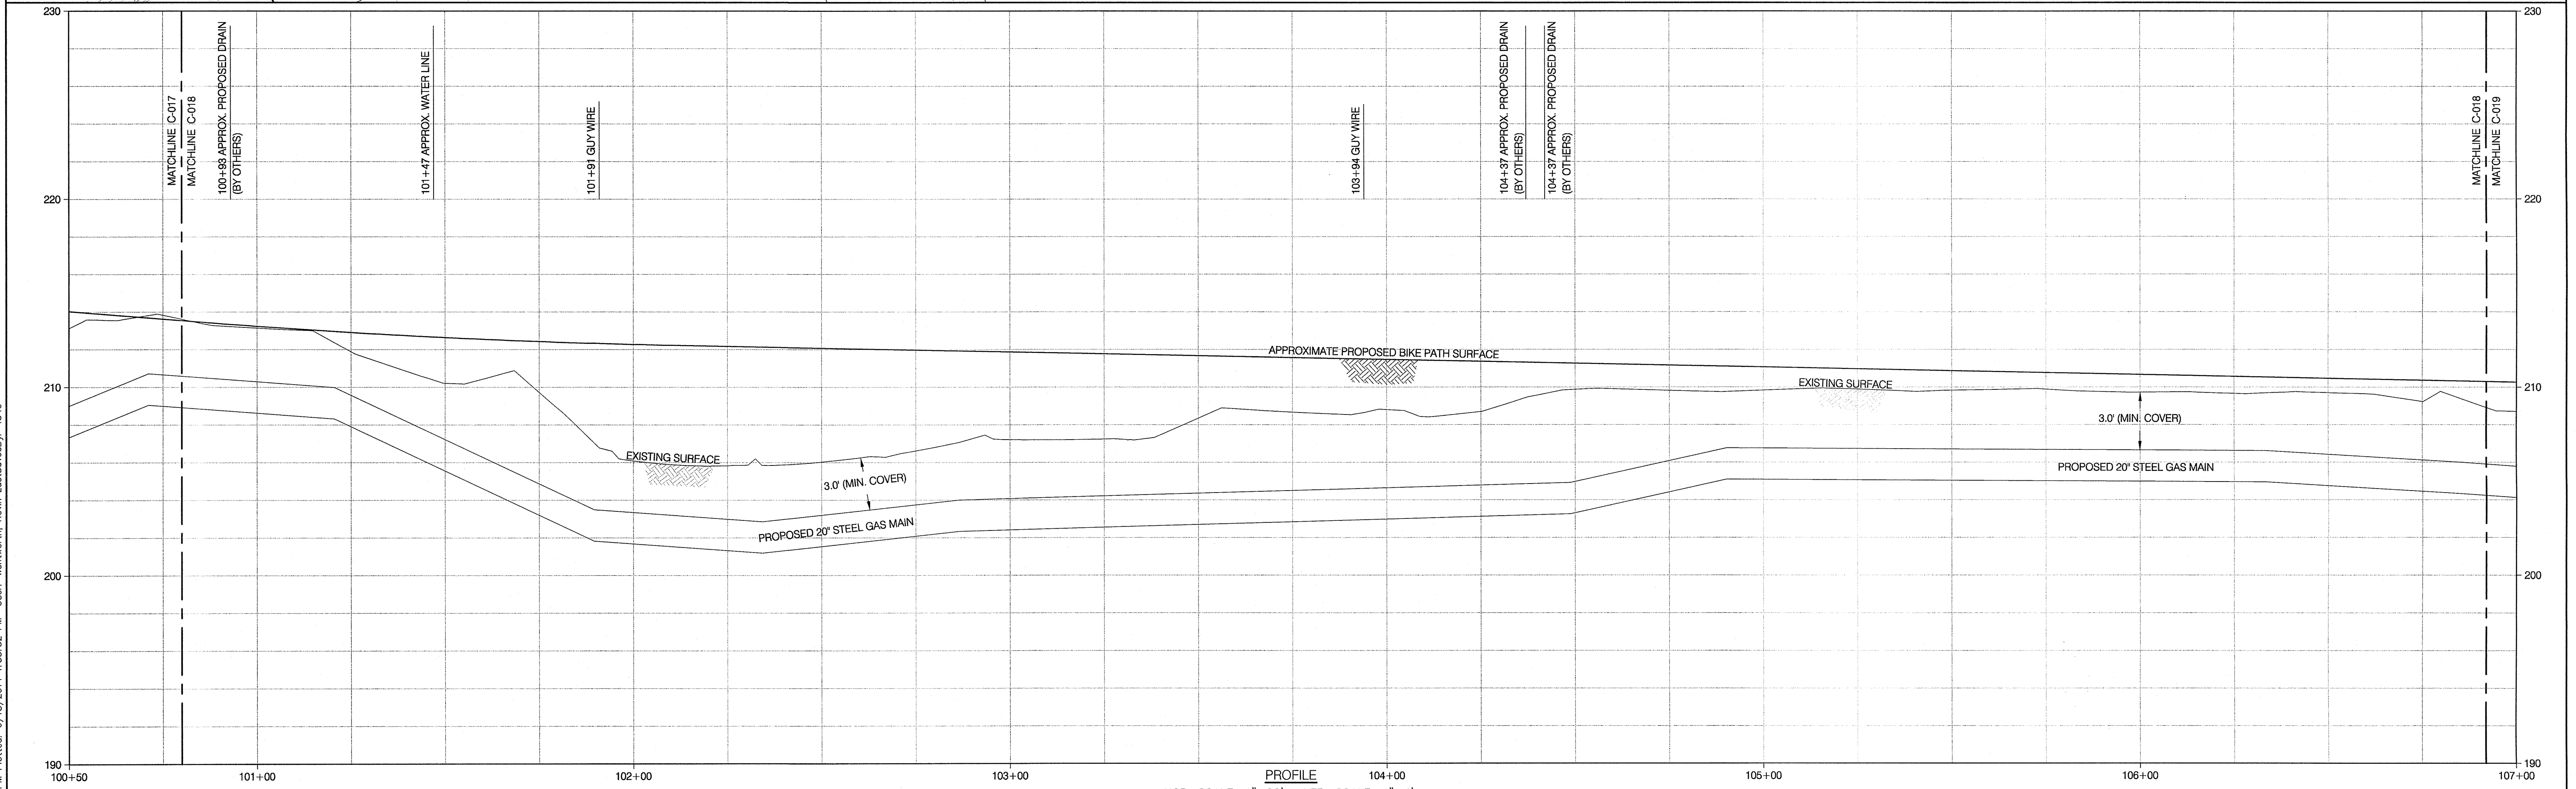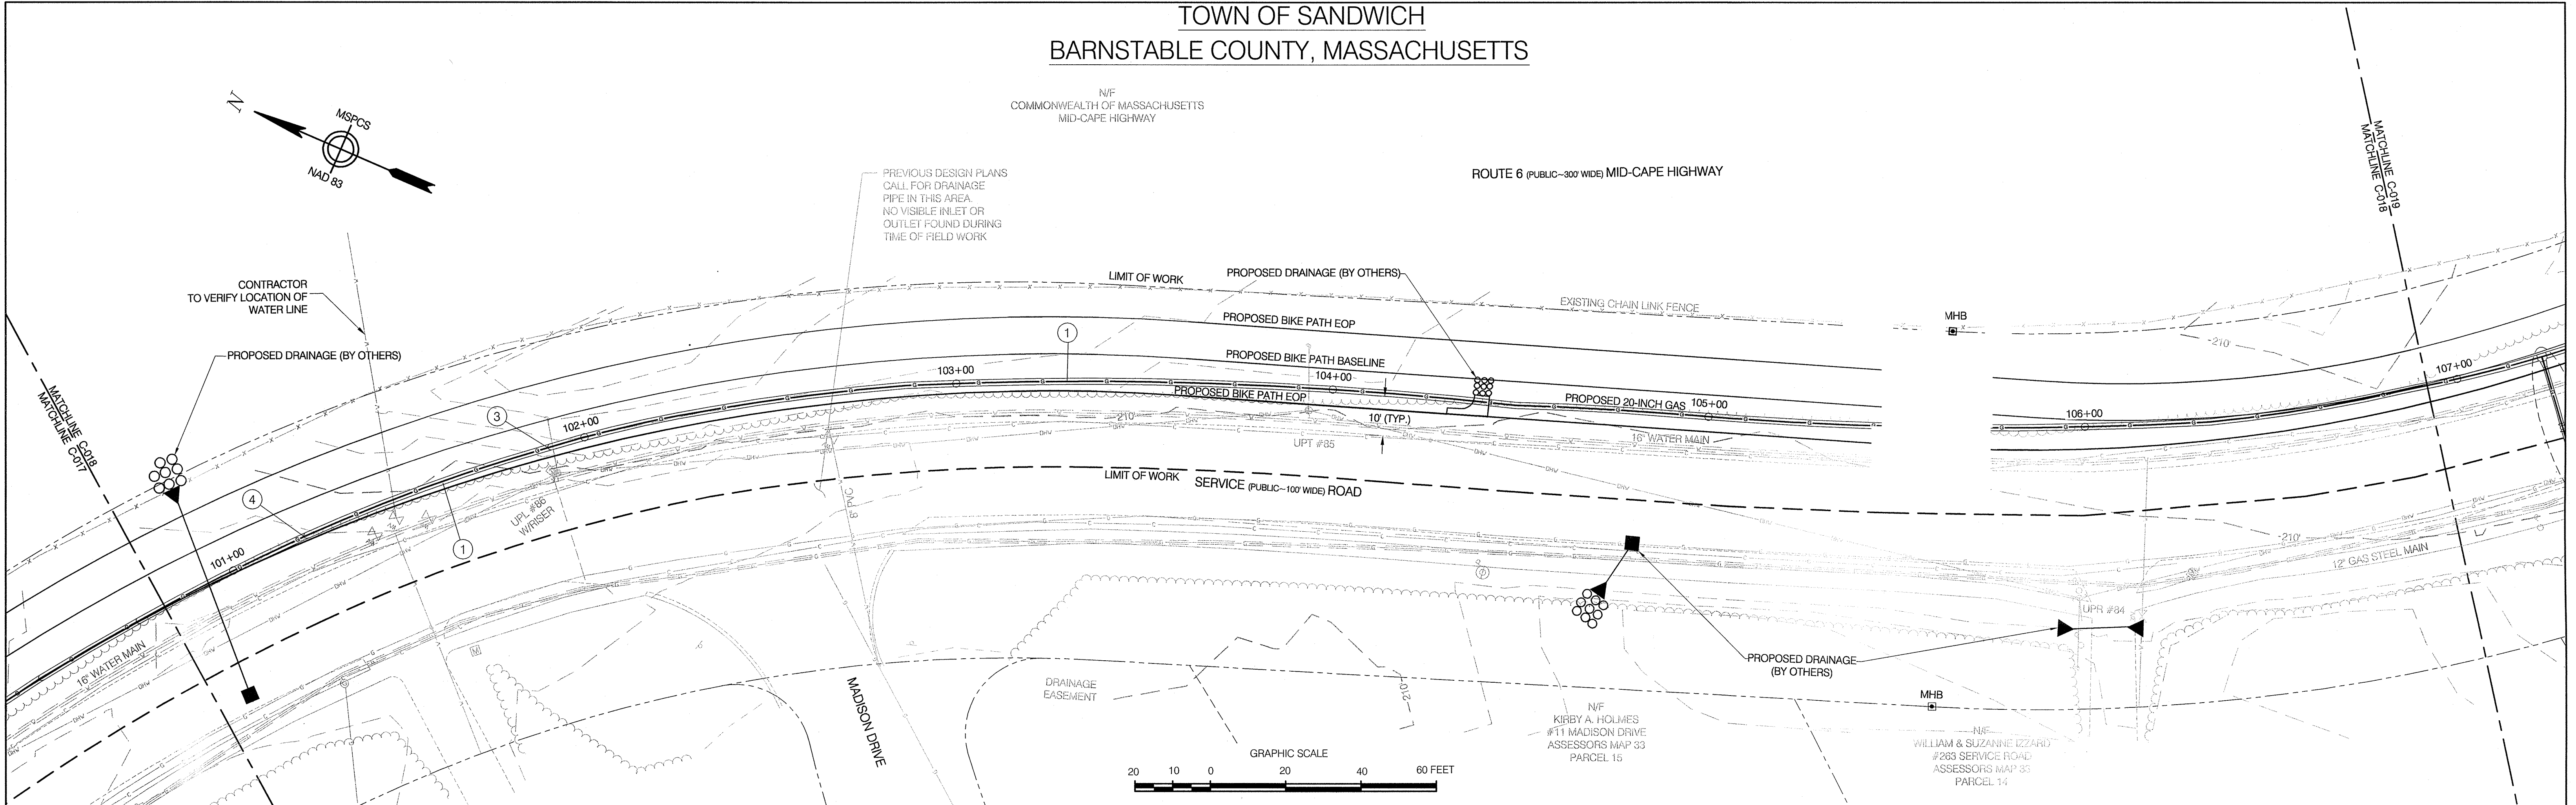

REFERENCE DRAWINGS				REVISIONS						
DRAWING NO.	TITLE	DRAWING NO.	TITLE	NO.	DATE	REMARKS	REV.	CKD.	COR.	APP.
				0	6/14	REVISED FOR FINAL EFSB APPROVAL	KDW	SAB	KDW	JEO

Design/Engineering

CHA

330 Bear Hill Road, Suite 304
Waltham, MA 02451
Main: (781) 962-7650 • www.chacompanies.com

Prepared For:

COLONIAL GAS COMPANY
d/b/a
nationalgrid
GAS ENGINEERING DEPARTMENT
40 SILVER HILL
WALTHAM, MA 02451

APPROVED BY

DATE: SEPTEMBER 7, 2012


MANAGER

NATIONAL GRID SERVICE COMPANY, USA


15-646.01-C-018

NATIONAL GRID SERVICE COMPANY, USA
SERVICE ROAD ALIGNMENT
SANDWICH, MA
BARNSTABLE COUNTY, MASSACHUSETTS

File No.: 15-646.01 ALIGN.dwg

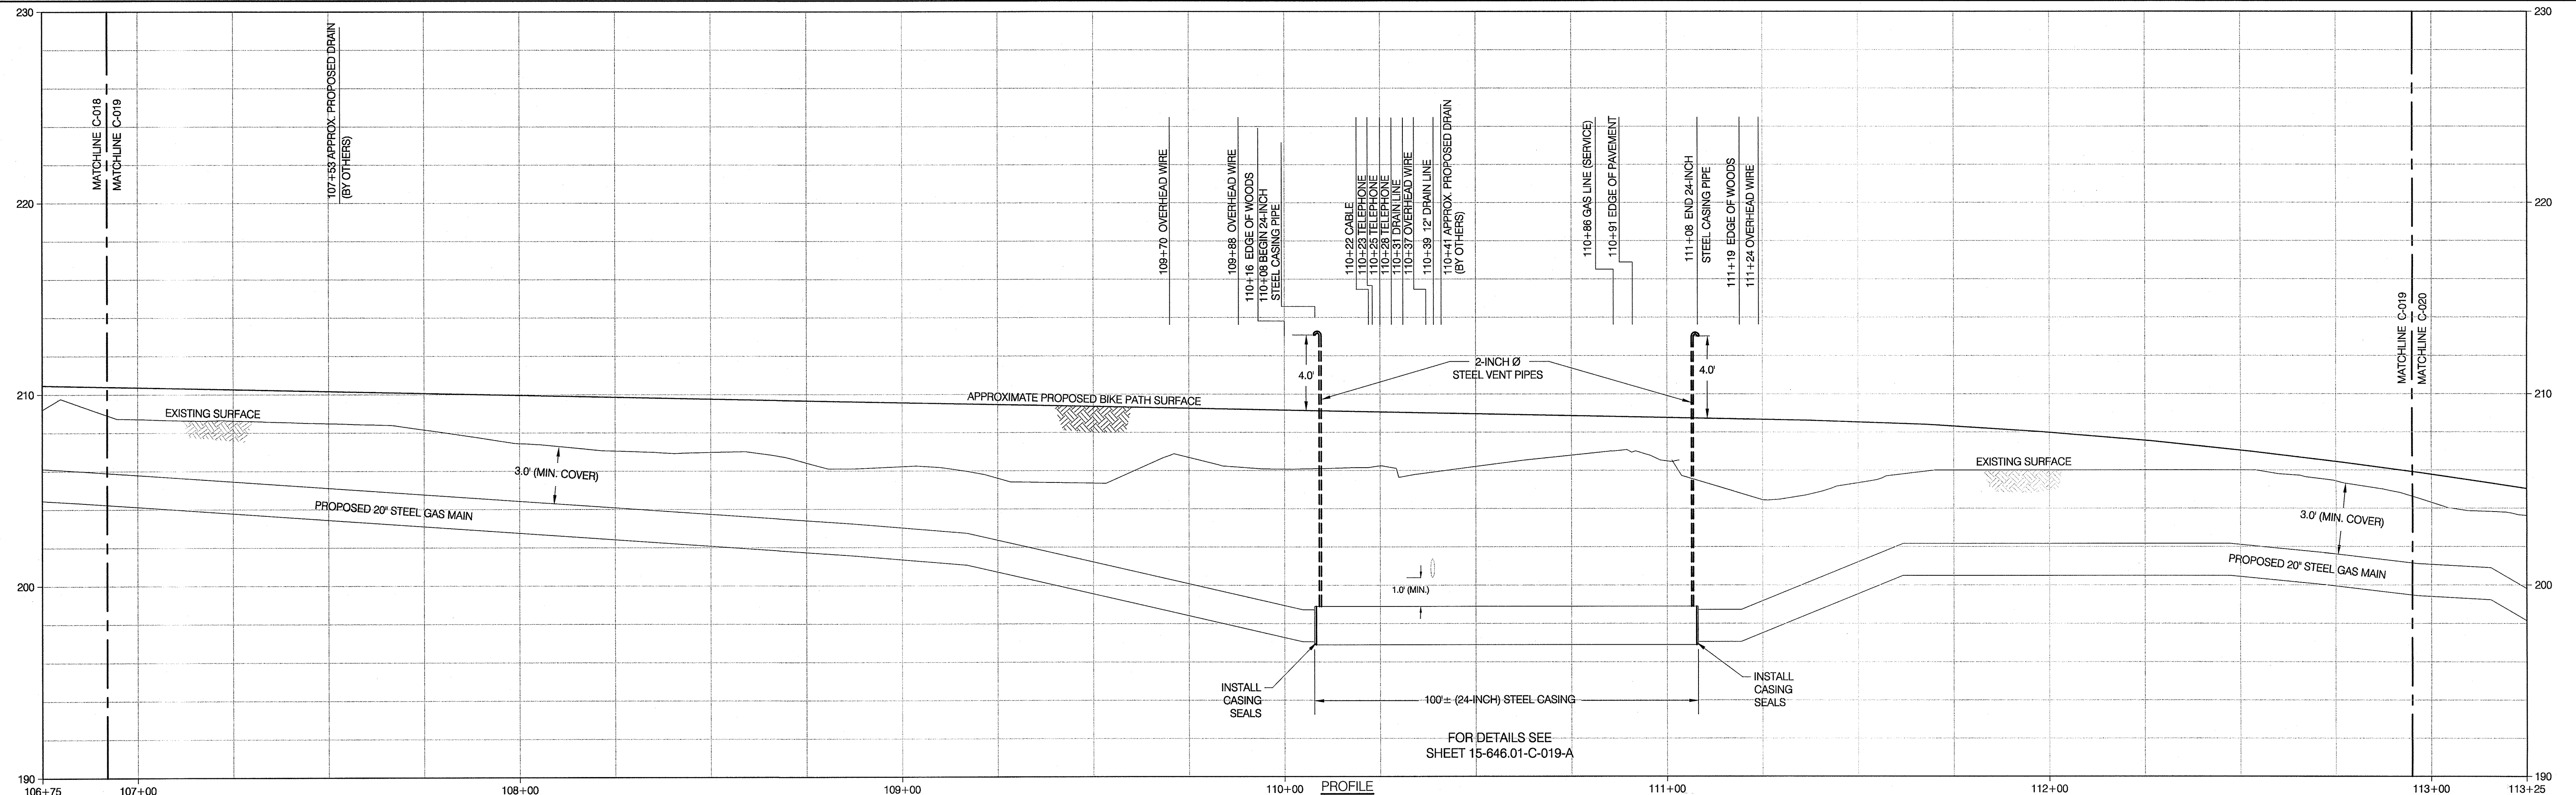[illegible][illegible]

COLONIAL GAS COMPANY
d/b/a
nationalgrid
GAS ENGINEERING DEPARTMENT
40 SYLVAN RD.
WALTHAM, MA 02451

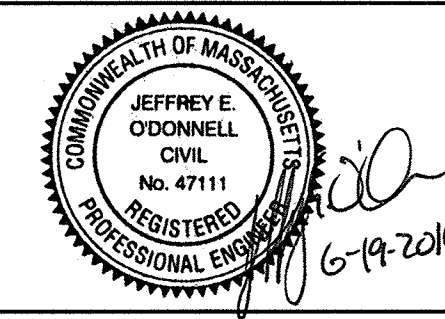

NATIONAL GRID SERVICE COMPANY, USA
SERVICE ROAD ALIGNMENT
SANDWICH, MA
BARNSTABLE COUNTY, MASSACHUSETTS




File No.: 15-646.01 ALIGN.dwg

APPROVED BY	
DATE: SEPTEMBER 7, 2012	MANAGER
NATIONAL GRID SERVICE COMPANY, USA	
15-646.01-C-019	

File: W:\NATIONAL GRID\2011 RFP 01\01 SANDWICH\DRAWINGS\ROAD CROSSING DETAILS\15-646.01 JACK & BORE DETAILS.DWG
Saved: 6/18/2014 5:12:13 PM Plotted: 6/18/2014 5:17:58 PM User: Wentworth, Kevin LastSavedBy: 4340

GENERAL NOTES

1. SITE DETAIL SHOWN HEREON IS BASED UPON TOPOGRAPHIC DETAIL SURVEY CONDUCTED BY COLER & COLANTONIO, INC. IN JULY 2011 AND DETAIL SURVEY PROVIDED BY BSC.
2. PROPERTY LINES SHOWN HEREON ARE BASED ON TAX MAP LOCATION AND DO NOT REPRESENT A PROPERTY LINE RETRACEMENT SURVEY EFFORT.
3. LOCATION OF ANY IDENTIFIED UNDERGROUND UTILITIES IS APPROXIMATE ONLY, AND IS NOT WARRANTED TO BE CORRECT. ADDITIONAL UTILITIES MAY EXIST WHICH ARE NOT INDICATED ON THESE PLANS. ALL EXISTING UTILITIES SHALL BE VERIFIED BY THE CONTRACTOR FOR SERVICE, SIZE, INVERT ELEVATIONS, LOCATION, ETC. CONTRACTOR MUST NOTIFY DIG-SAFE AT 1-888-344-7233 AT LEAST 72 HOURS PRIOR TO ANY CONSTRUCTION.
4. SURVEY WAS CONDUCTED IN MASSACHUSETTS MAINLAND ZONE 2001, NAD83 HORIZONTAL COORDINATE SYSTEM. ELEVATIONS ARE BASED ON NAVD 1988, US SURVEY FEET. ELEVATIONS WERE TRANSFERRED TO THIS SITE VIA STATIC GPS SURVEY METHODS AND REFERENCED TO TEMPORARY BENCHMARKS AS SHOWN ON THE PLAN.
5. THE PURPOSE OF THIS PLAN IS TO IDENTIFY TO THE APPROPRIATE PERMITTING AGENCY THE PROPOSED LOCATION FOR A GAS PIPELINE AND ITS LOCATION RELATIVE TO EXISTING UTILITIES WITHIN THE LIMITS OF A ROAD RIGHT-OF-WAY, INCLUDING ELEVATION INFORMATION WHERE OBTAINABLE.
6. THE PROPOSED 20-INCH STEEL PIPE ROAD CROSSING WILL BE CONSTRUCTED VIA PIPE JACKING CONSTRUCTION METHODS.
7. ALL CONSTRUCTION SIGNING, DRUMS, BARRICADES AND OTHER DEVICES SHALL CONFORM WITH PART VI OF THE 2003 MANUAL ON UNIFORM TRAFFIC CONTROL DEVICES (M.U.T.C.D.) REVISION 3 AND AS AMENDED.
8. ALL VEHICLES ARE TO BE HIGHLY VISIBLE USING ROTATING BEACONS AND BE MARKED BY USE OF TRAFFIC CONES.
9. NATIONAL GRID SHALL NOTIFY EACH ABUTTER AT LEAST 48 HOURS IN ADVANCE OF THE START OF ANY WORK THAT WILL REQUIRE THE TEMPORARY OBSTRUCTION OF ACCESS.
10. BACKFILL MATERIAL WILL CONSIST OF SUITABLE EXCAVATED MATERIAL COMPACTED.
11. BLASTING NOT PERMITTED.

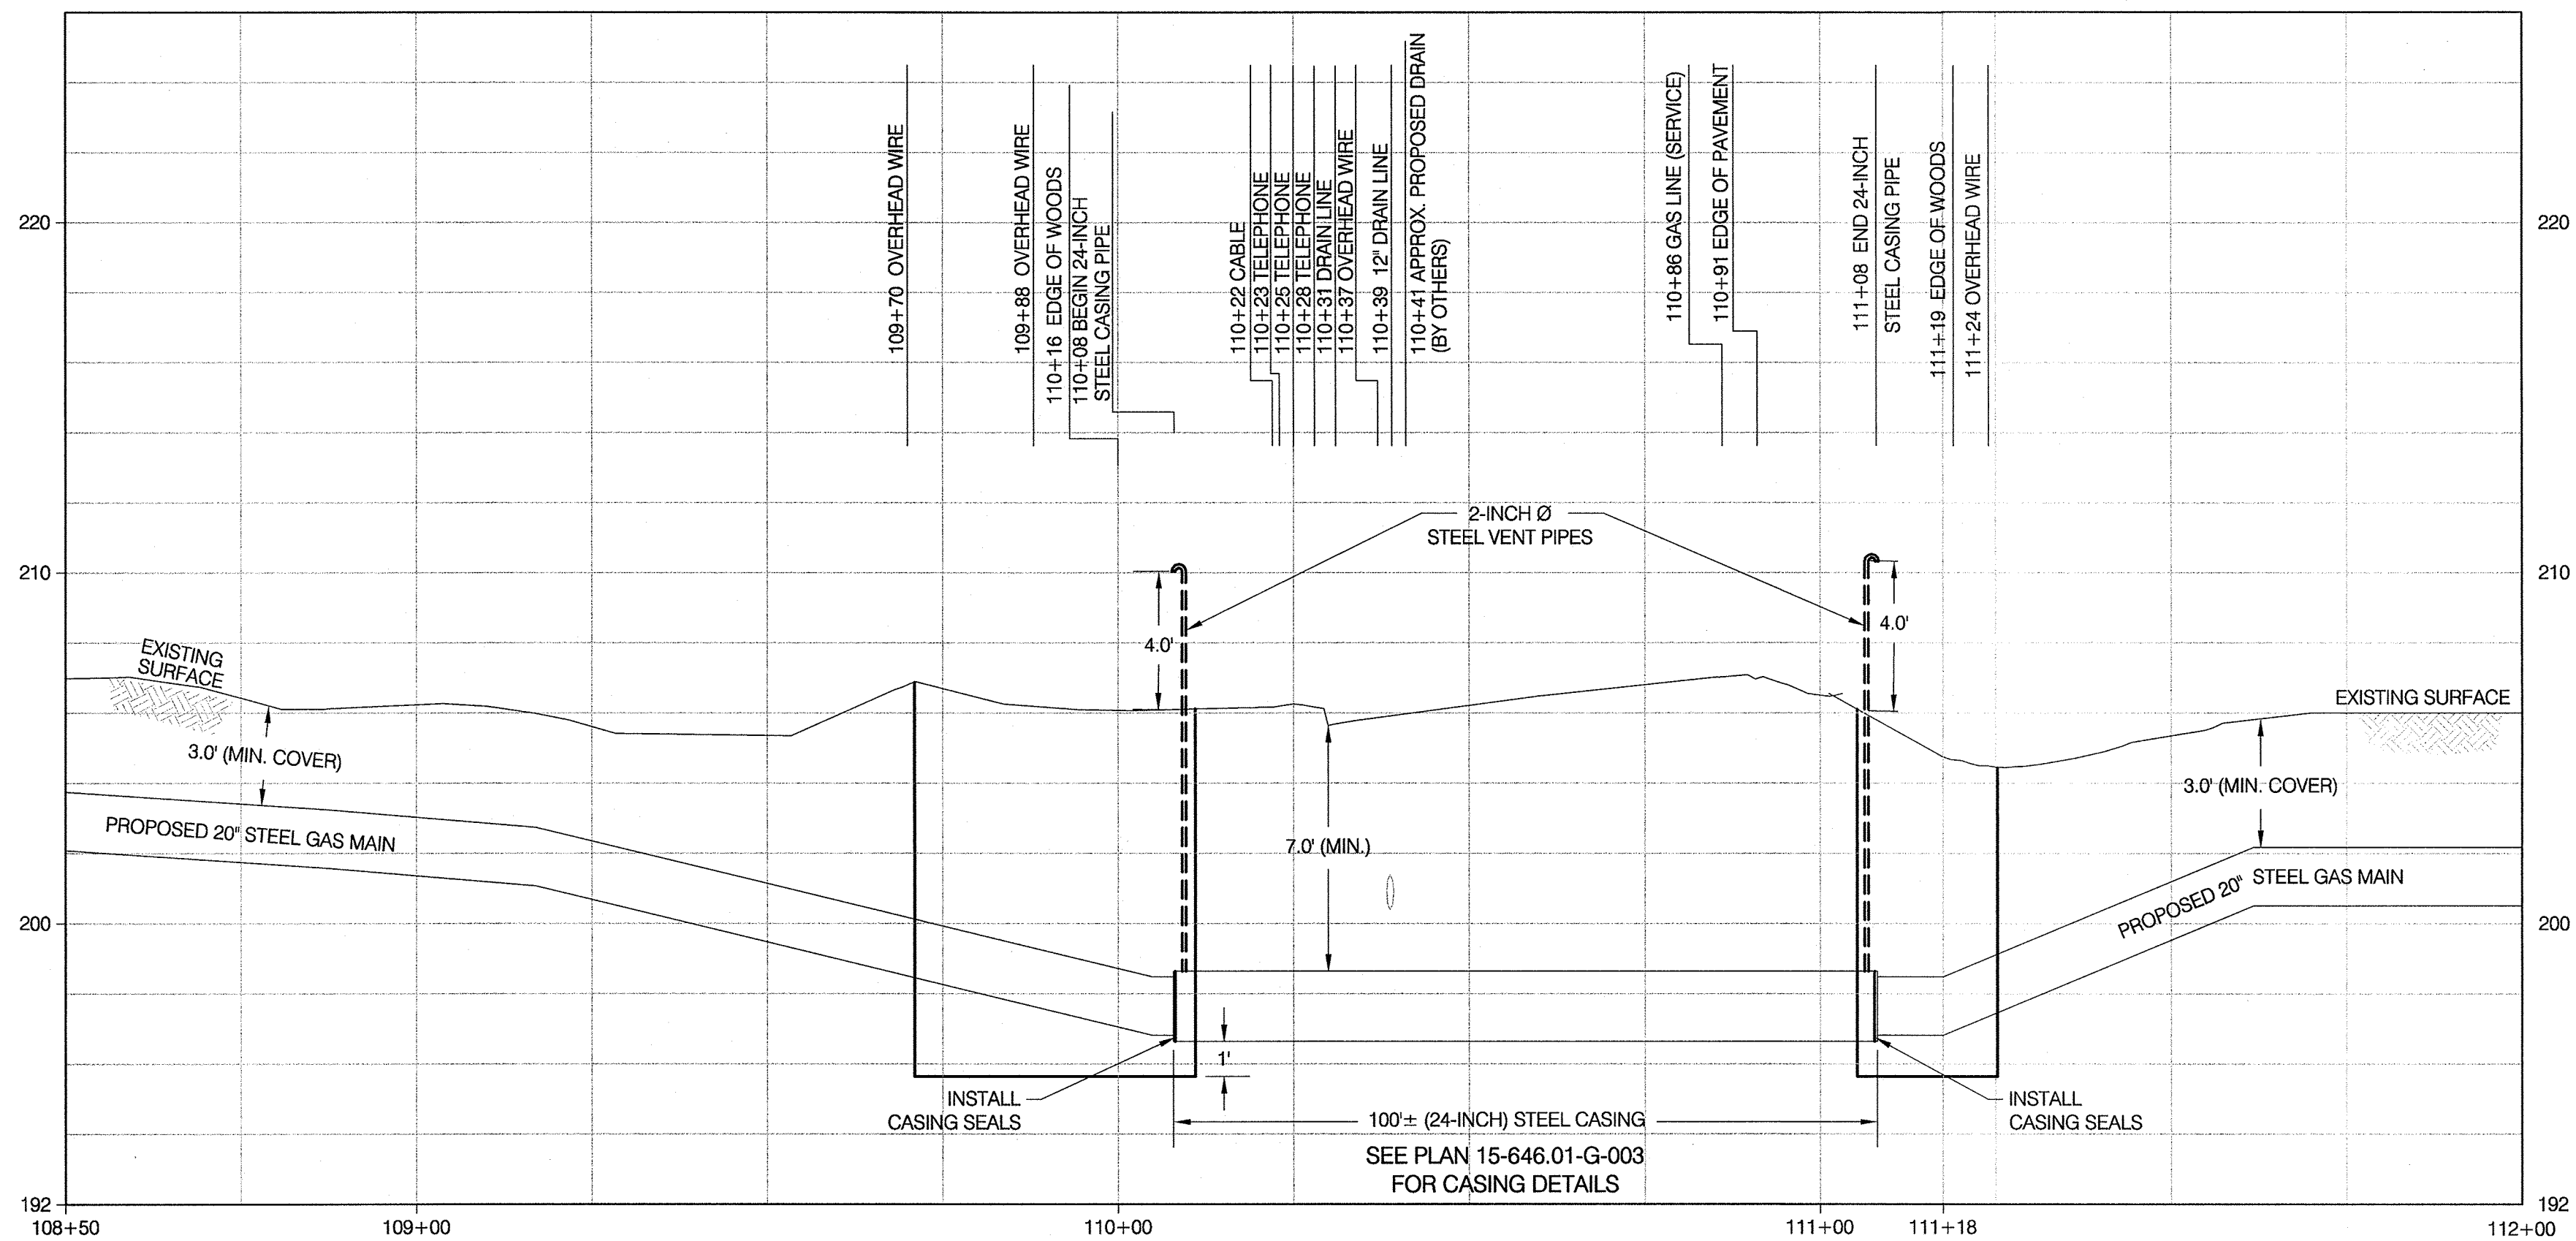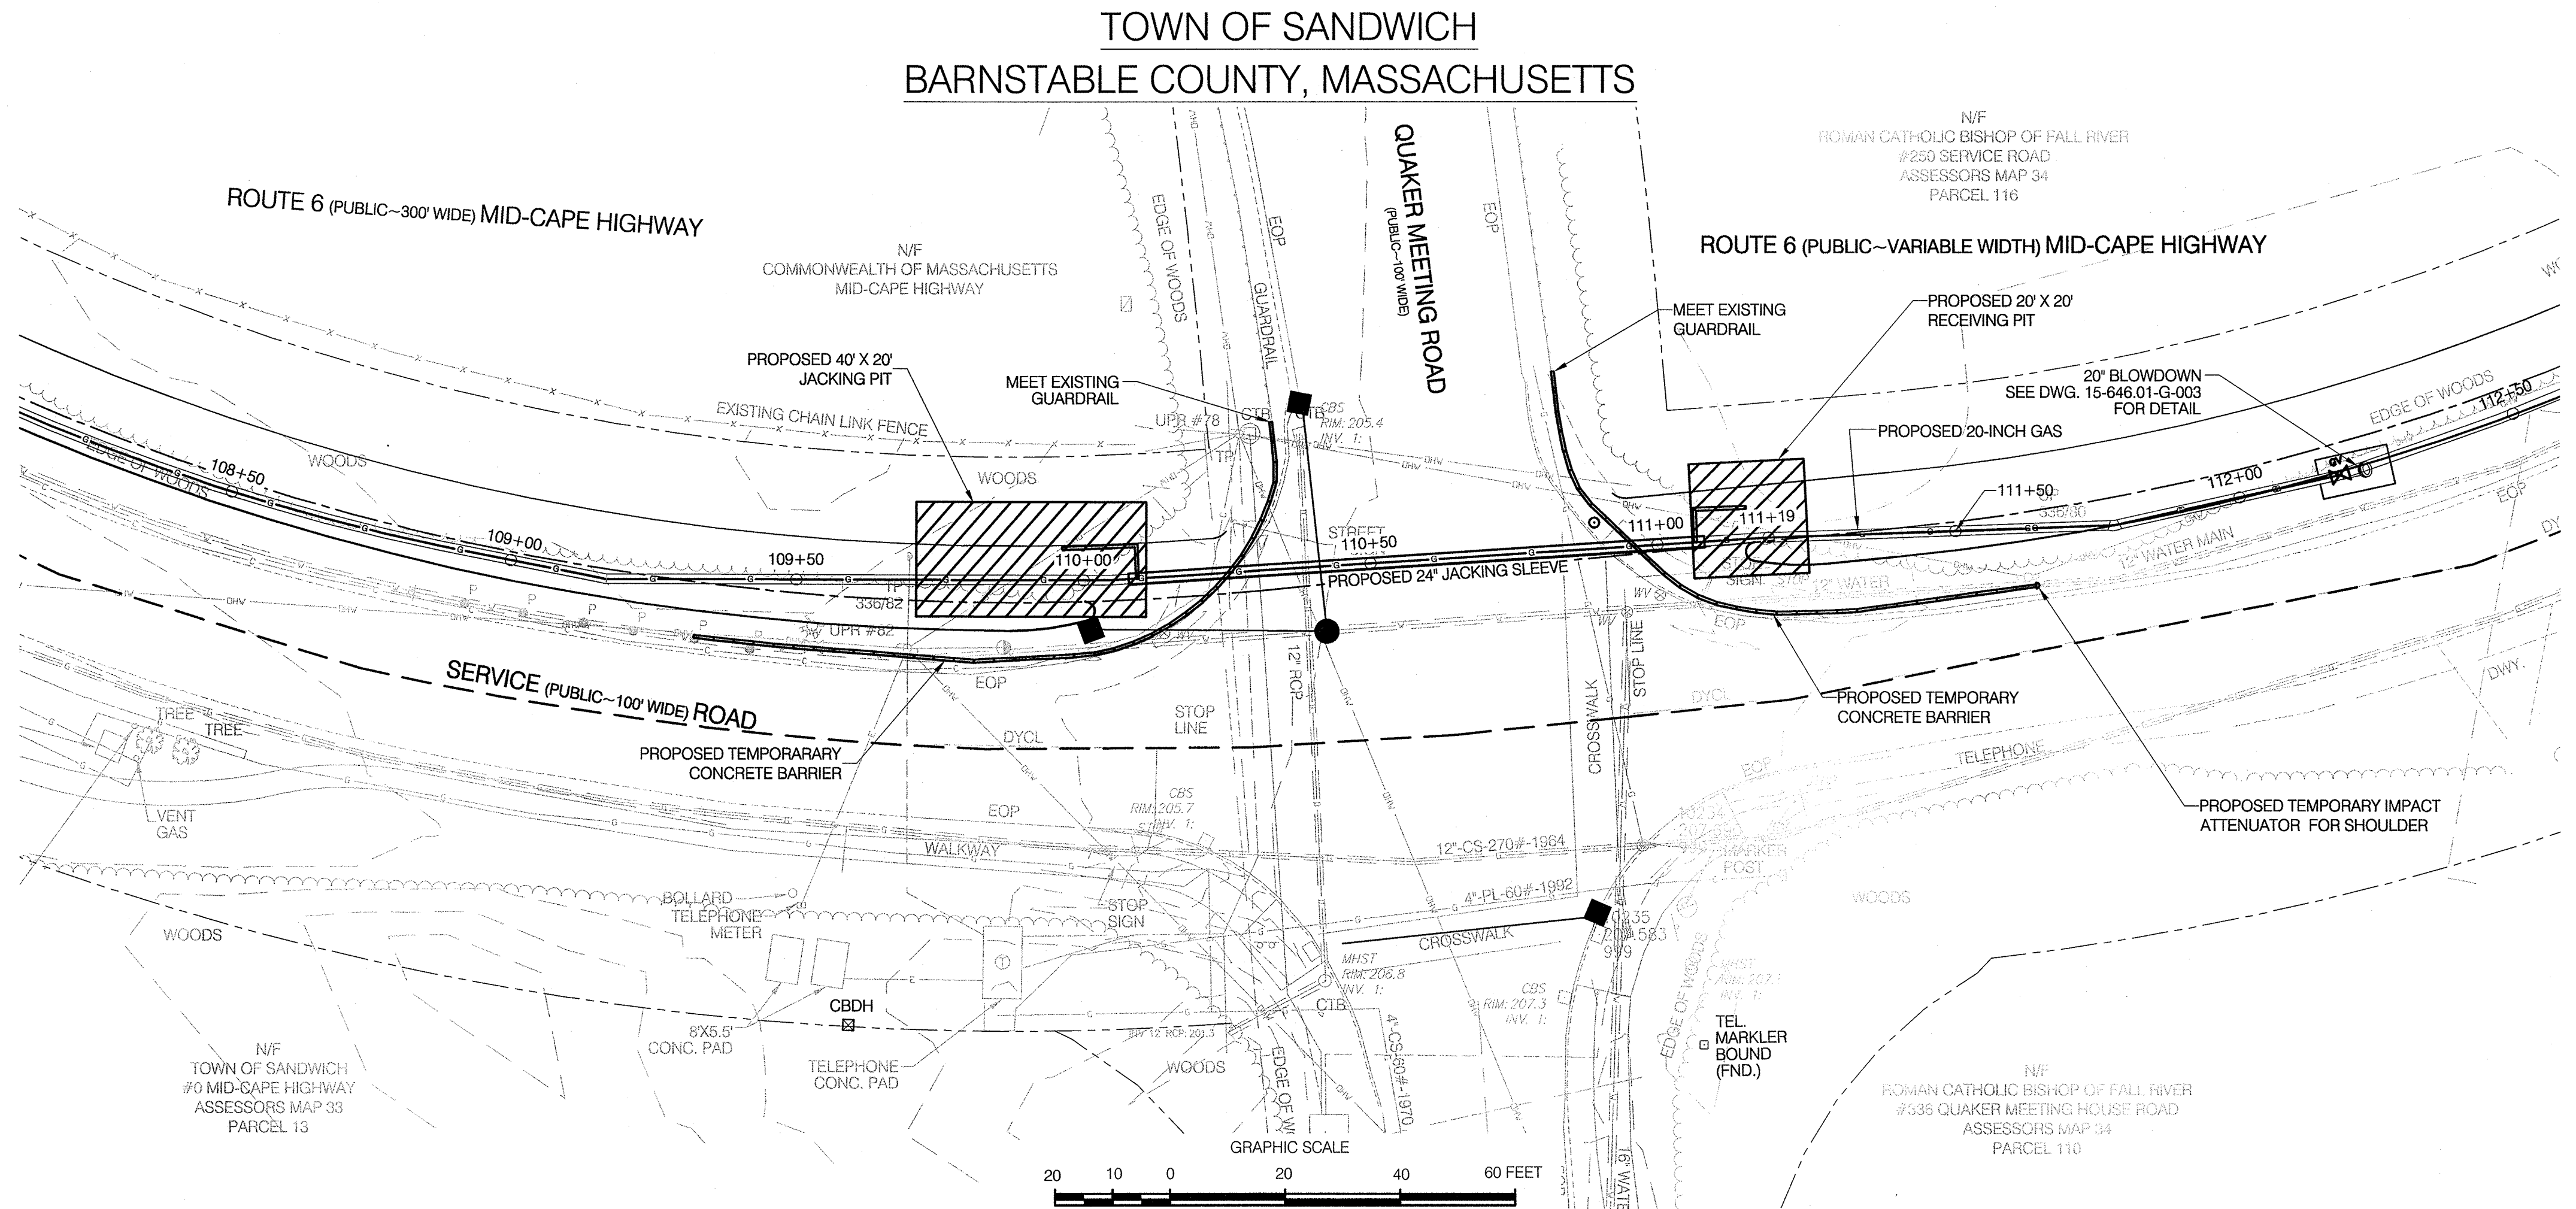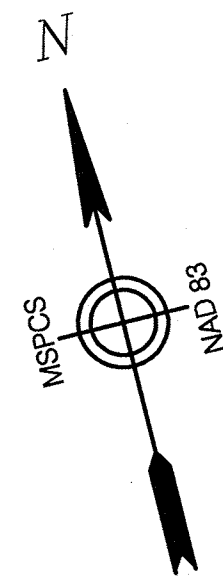

PROFILE
HOR. SCALE: 1"=20'
VER. SCALE: 1"=5'

REFERENCE DRAWINGS

DRAWING NO.	TITLE	DRAWING NO.	TITLE

REVISIONS


NO.	DATE	REMARKS	REV.	CKD.	COR.	APP.
0	6/14	REVISED FOR FINAL EFSB APPROVAL	KDW	SAB	KDW	JEQ

Design/Engineering



Prepared For:

COLONIAL GAS COMPANY
d/b/a
nationalgrid
GAS ENGINEERING DEPARTMENT
40 SCULMAN RD.
WALTHAM, MA 02451

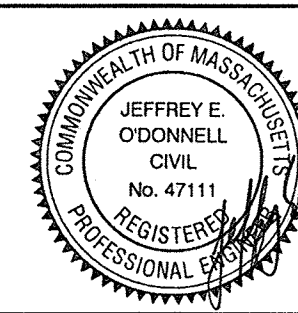

NATIONAL GRID
PROPOSED 20-INCH GAS MAIN
QUAKER MEETING HOUSE ROAD CROSSING DETAIL
SANDWICH, MASSACHUSETTS

File No.: 15-646.01 JACK & BORE DETAILS.dwg



APPROVED BY

DATE: SEPTEMBER 24, 2012


MANAGER

NATIONAL GRID SERVICE COMPANY, USA

15-646.01-C-019A

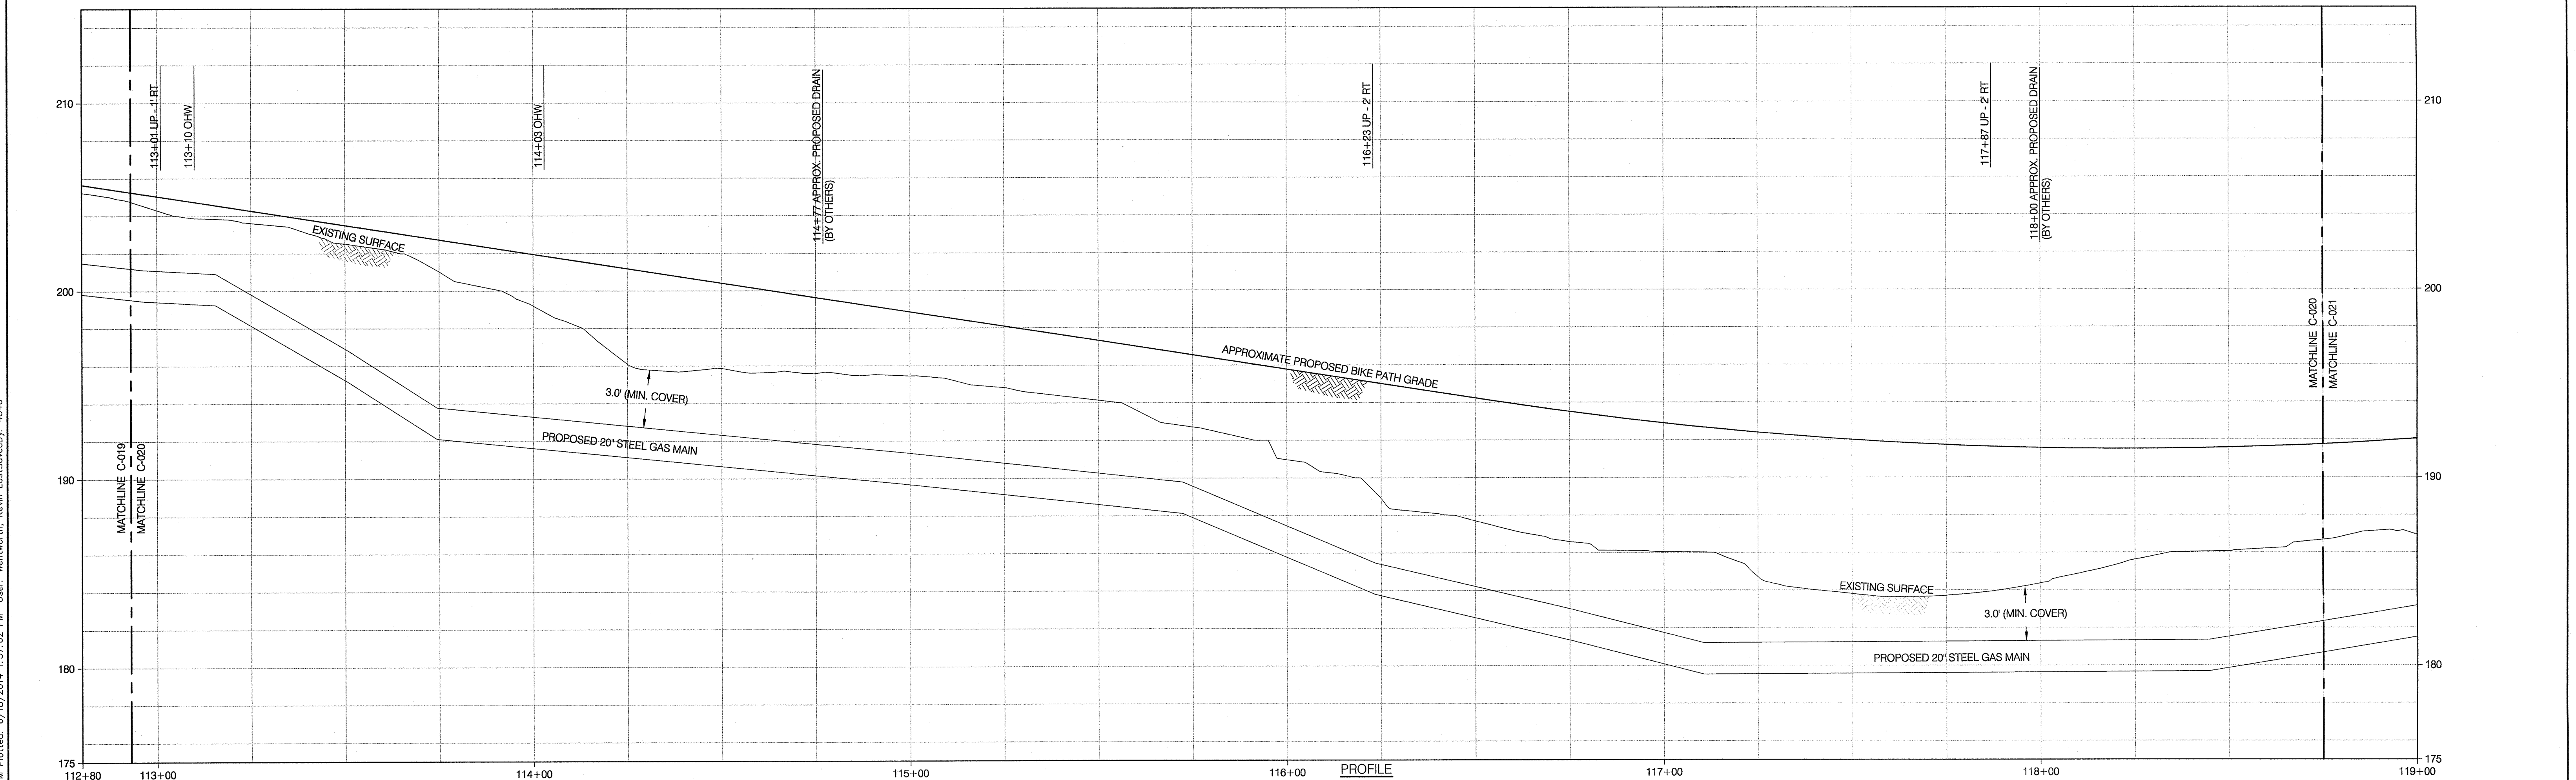
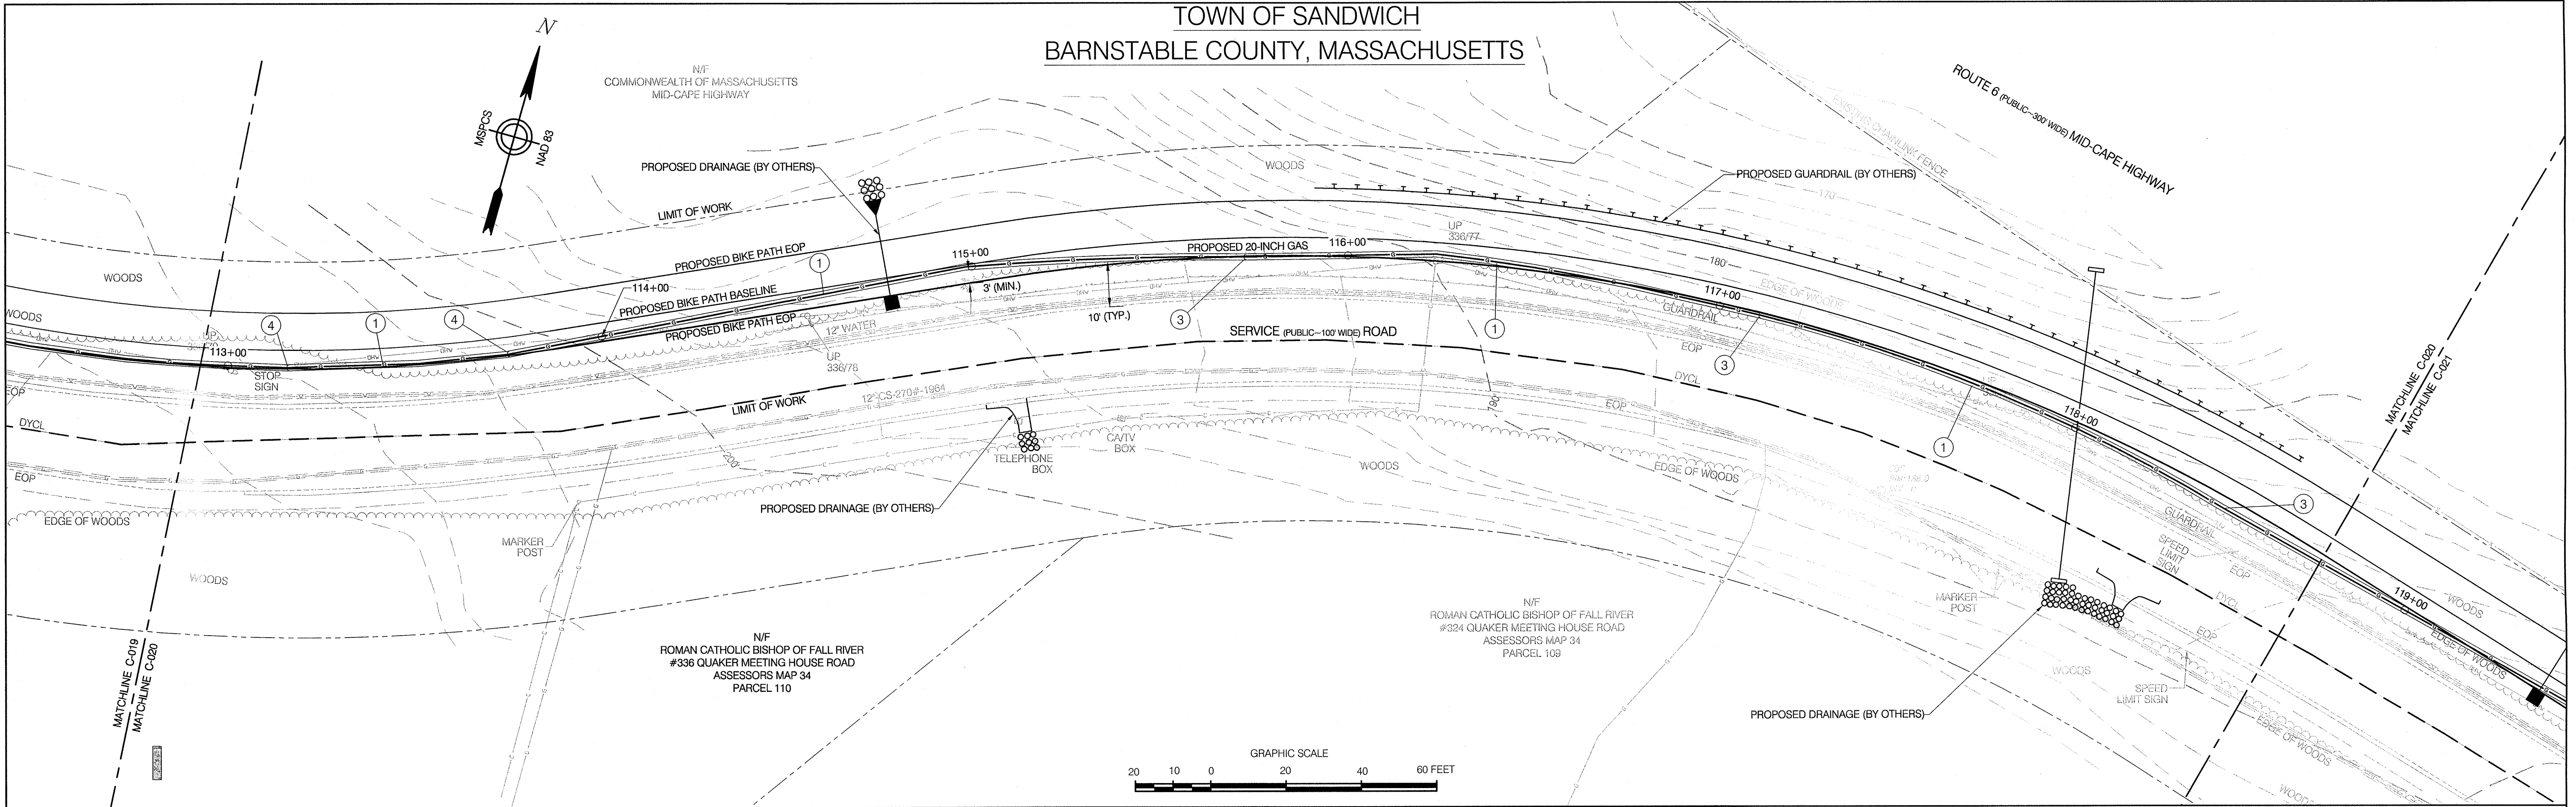


REFERENCE DRAWINGS				REVISIONS							
DRAWING NO.	TITLE	DRAWING NO.	TITLE	NO.	DATE	REMARKS	REV.	CKD.	COR.	APP.	
				0	6/14	REVISED FOR FINAL EFSB APPROVAL	KDW	SAB	KDW	JEO	

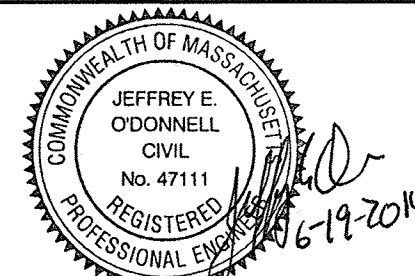CHIA 330 Bear Hill Road, Suite 304 Waltham, MA 02451 Main: (781) 962-7650 • www.chiacompanies.com		COLONIAL GAS COMPANY d/b/a nationalgrid GAS ENGINEERING DEPARTMENT 40 DYLAN RD. WALTHAM, MA 02451				NATIONAL GRID SERVICE COMPANY, USA SERVICE ROAD ALIGNMENT SANDWICH, MA BARNSTABLE COUNTY, MASSACHUSETTS File No.: 15-646.01 ALIGN.dwg		APPROVED BY DATE: SEPTEMBER 7, 2012 MANAGER NATIONAL GRID SERVICE COMPANY, USA 15-646.01-C-020	
---	--	---	--	---	--	---	--	--	--

File: W:\NATIONAL GRID\2011 RFP 01\01 SANDWICH\DRAWINGS\15-646.01 ALIGN 1-23_REV 0 (ISSUED FOR FINAL EFSB APPROVAL).DWG
Saved: 6/18/2014 1:41:05 PM Plotted: 6/18/2014 1:57:02 PM User: Wentworth, Kevin LastSavedBy: 4340

TOWN OF SANDWICH
BARNSTABLE COUNTY, MASSACHUSETTS

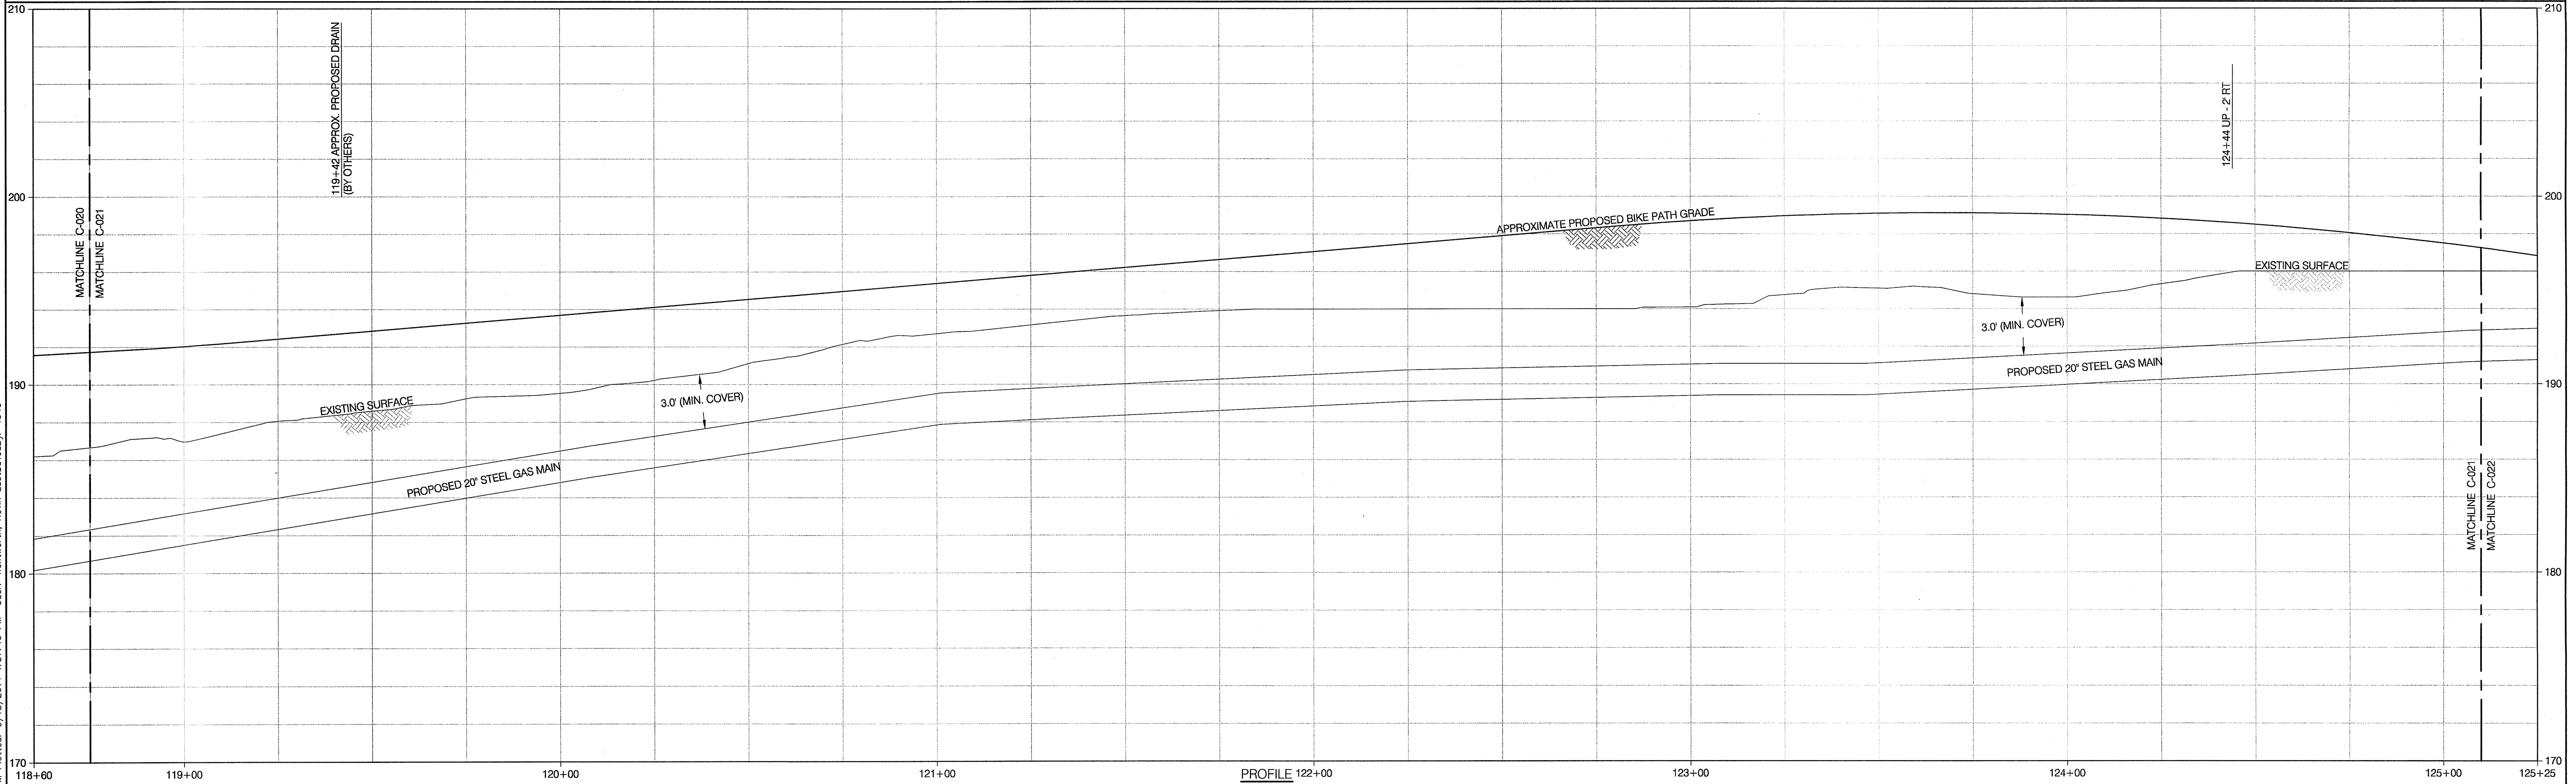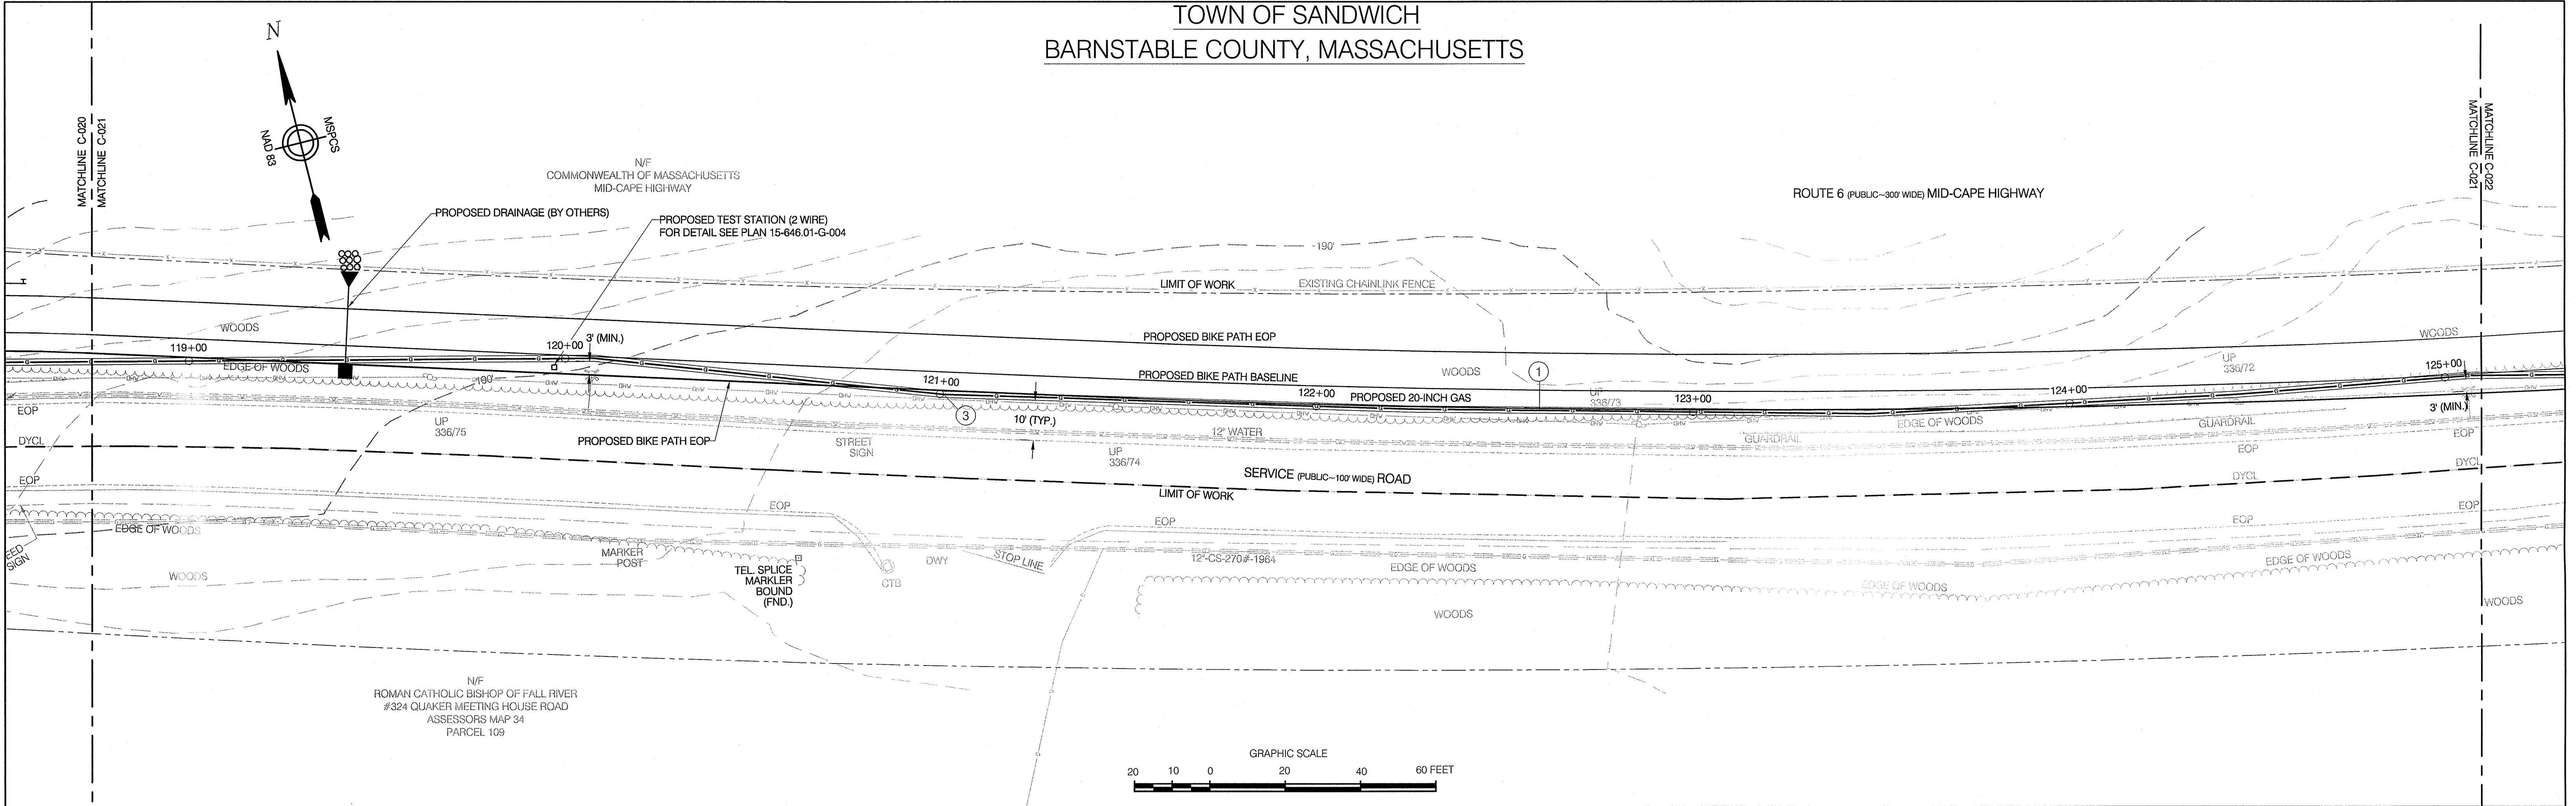




REFERENCE DRAWINGS				REVISIONS							
DRAWING NO.	TITLE	DRAWING NO.	TITLE	NO.	DATE	REMARKS	REV.	CKD.	COR.	APP.	
				0	6/14	REVISED FOR FINAL EFSB APPROVAL	KDW	SAB	KDW	JEO	

HORIZONTAL SCALE: 1"=20'		VERTICAL SCALE: 1"=4'	
DESIGN/ENGINEERING		PREPARED FOR:	
COLONIAL GAS COMPANY d/b/a nationalgrid		GAS ENGINEERING DEPARTMENT 40 BROWN RD WALTHAM, MA 02451	
330 Bear Hill Road, Suite 304 Waltham, MA 02451 Main: (781) 982-7650 • www.chacompanies.com		JEFFREY E. O'DONNELL CIVIL No. 47111 REGISTERED PROFESSIONAL ENGINEER 6-19-2014	



NATIONAL GRID SERVICE COMPANY, USA SERVICE ROAD ALIGNMENT SANDWICH, MA BARNSTABLE COUNTY, MASSACHUSETTS		APPROVED BY DATE: SEPTEMBER 7, 2012 MANAGER NATIONAL GRID SERVICE COMPANY, USA 15-646.01-C-021	
File No.: 15-646.01 ALIGN.dwg			

File: W:\NATIONAL GRID\2011 RFP 01\01 SANDWICH\DRAWINGS\15-646.01 ALIGN 1-23_REV 0 (ISSUED FOR FINAL EFSB APPROVAL).DWG
Saved: 6/18/2014 1:41:05 PM Plotted: 6/18/2014 1:57:45 PM User: Wentworth, Kevin LastSavedBy: 4340

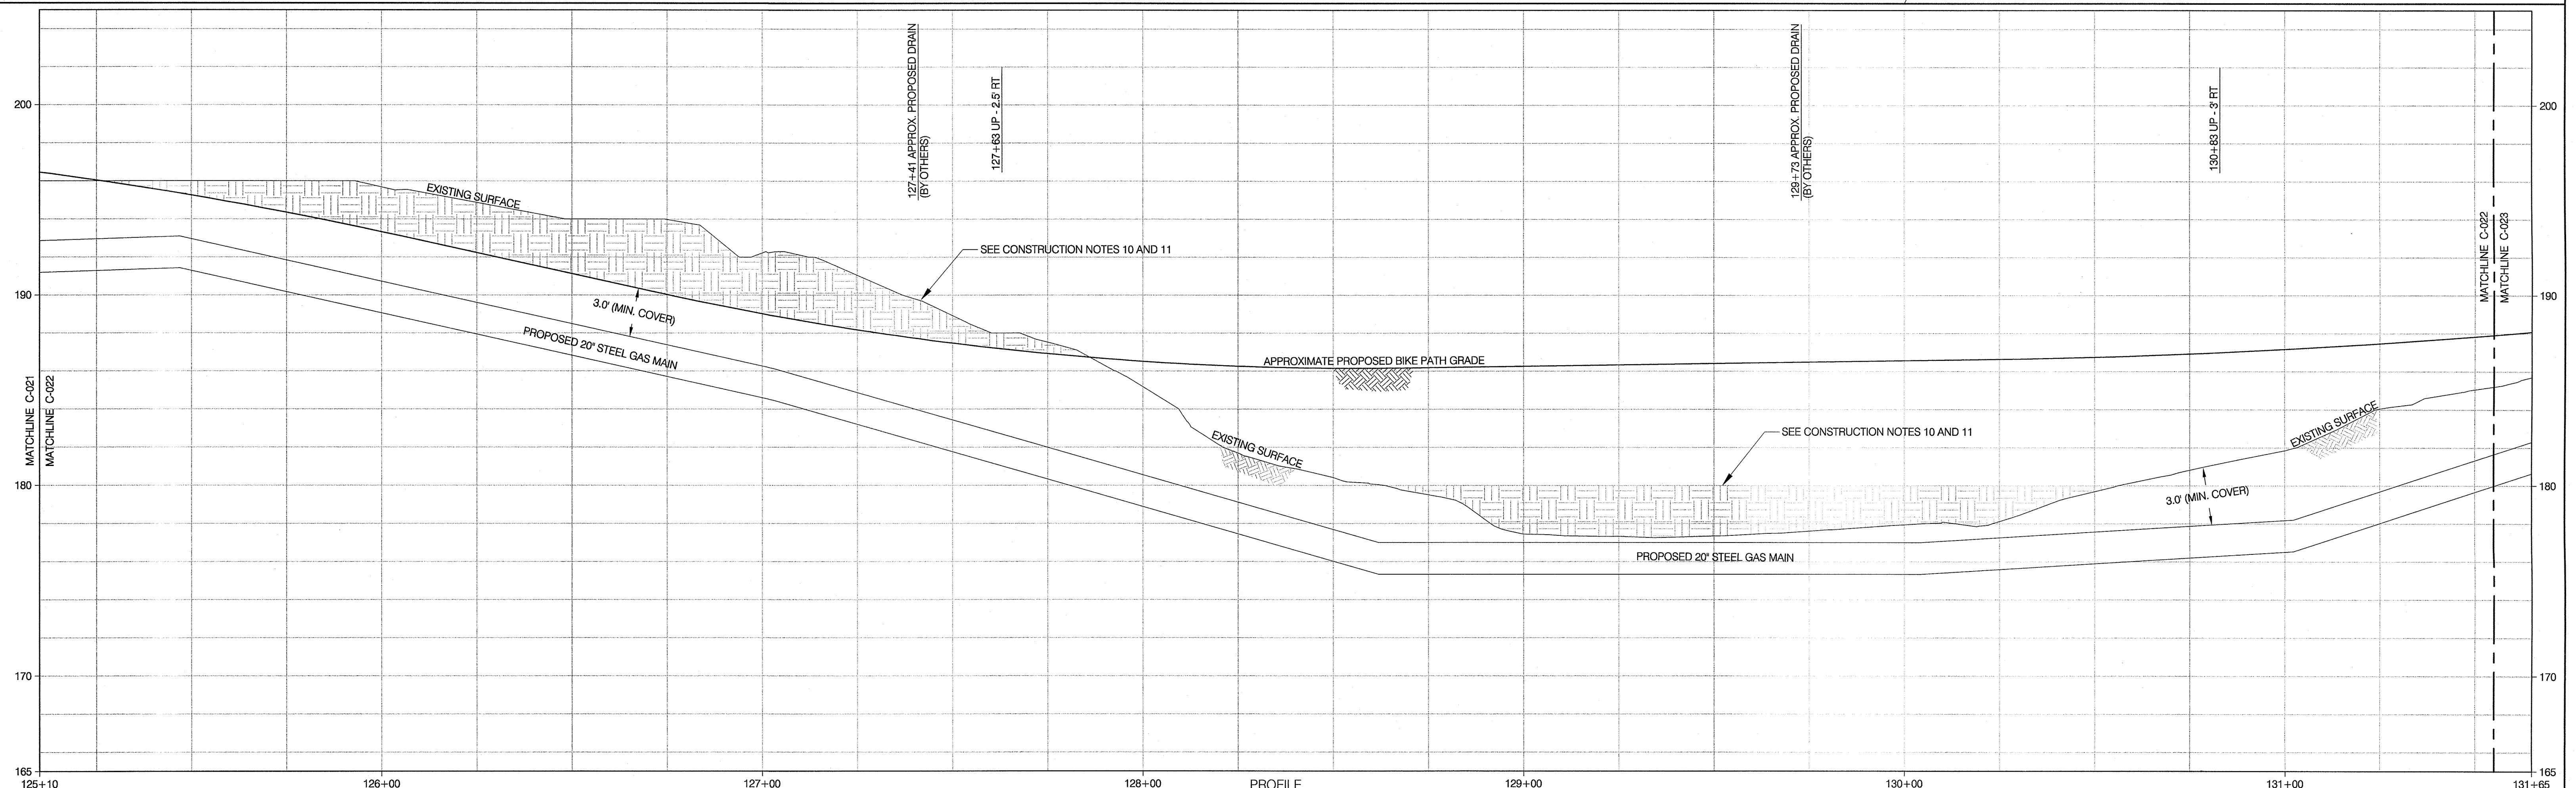[illegible][illegible]

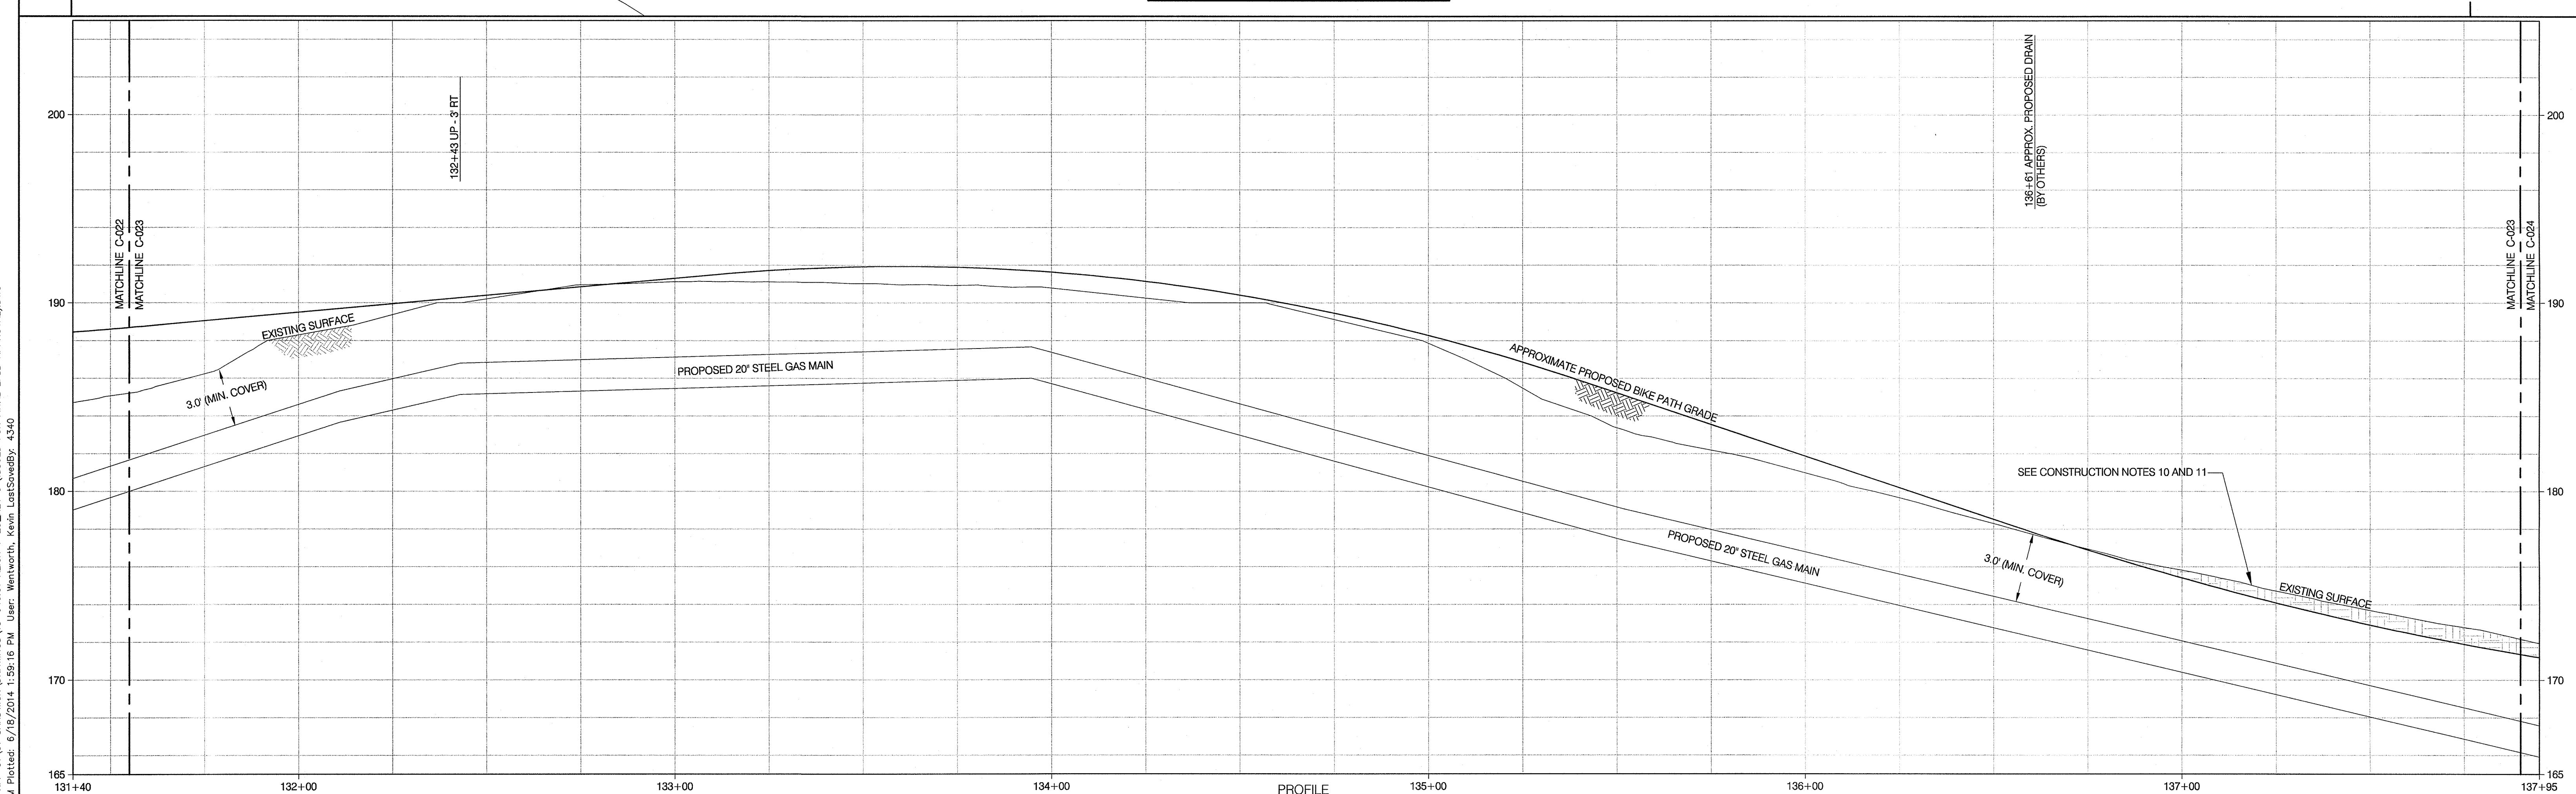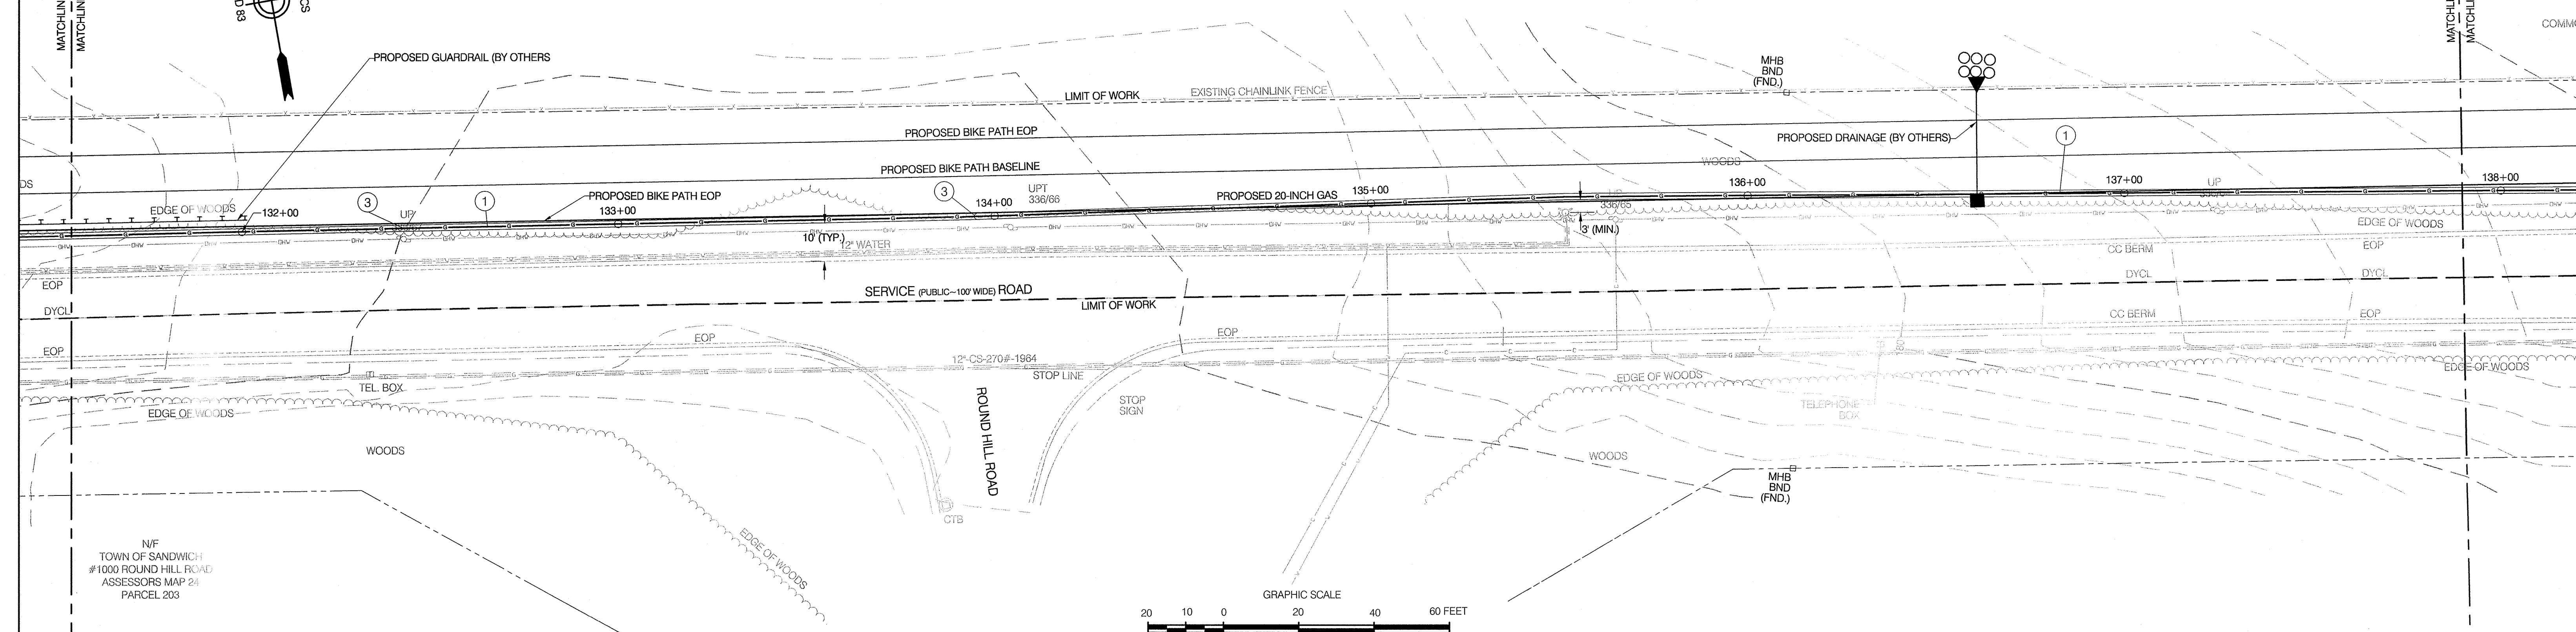[illegible]

 

File: w:\NATIONAL GRID\2011 RFP 01\01 SANDWICH\DRAWINGS\15-646.01 ALIGN 1-23_REV 0 (ISSUED FOR FINAL EFSB APPROVAL).DWG
Saved: 6/18/2014 1:41:05 PM Plotted: 6/18/2014 1:59:16 PM User: Wentworth, Kevin LastSavedBy: 4340

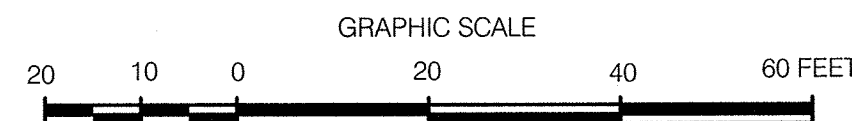

CHIA
330 Bear Hill Road, Suite 304
Waltham, MA 02451
Main: (781) 982-7650 • www.chiacompanies.com



APPROVED BY	
DATE: SEPTEMBER 7, 2012	MANAGER
NATIONAL GRID SERVICE COMPANY, USA	
15-646.01-C-024	

 
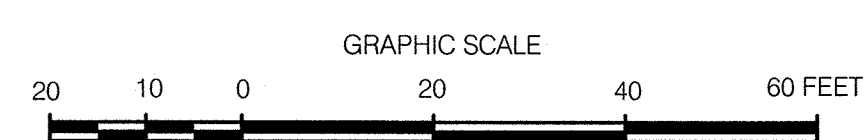


CHIA
330 Bear Hill Road, Suite 304
Waltham, MA 02451
Main: (781) 862-7650 • www.chiacompanies.com

APPROVED BY	
DATE: SEPTEMBER 7, 2012	MANAGER
NATIONAL GRID SERVICE COMPANY, USA	
15-646.01-C-025	

TOWN OF SANDWICH
BARNSTABLE COUNTY, MASSACHUSETTS

ROUTE 6 (PUBLIC~300' WIDE) MID-CAPE HIGHWAY

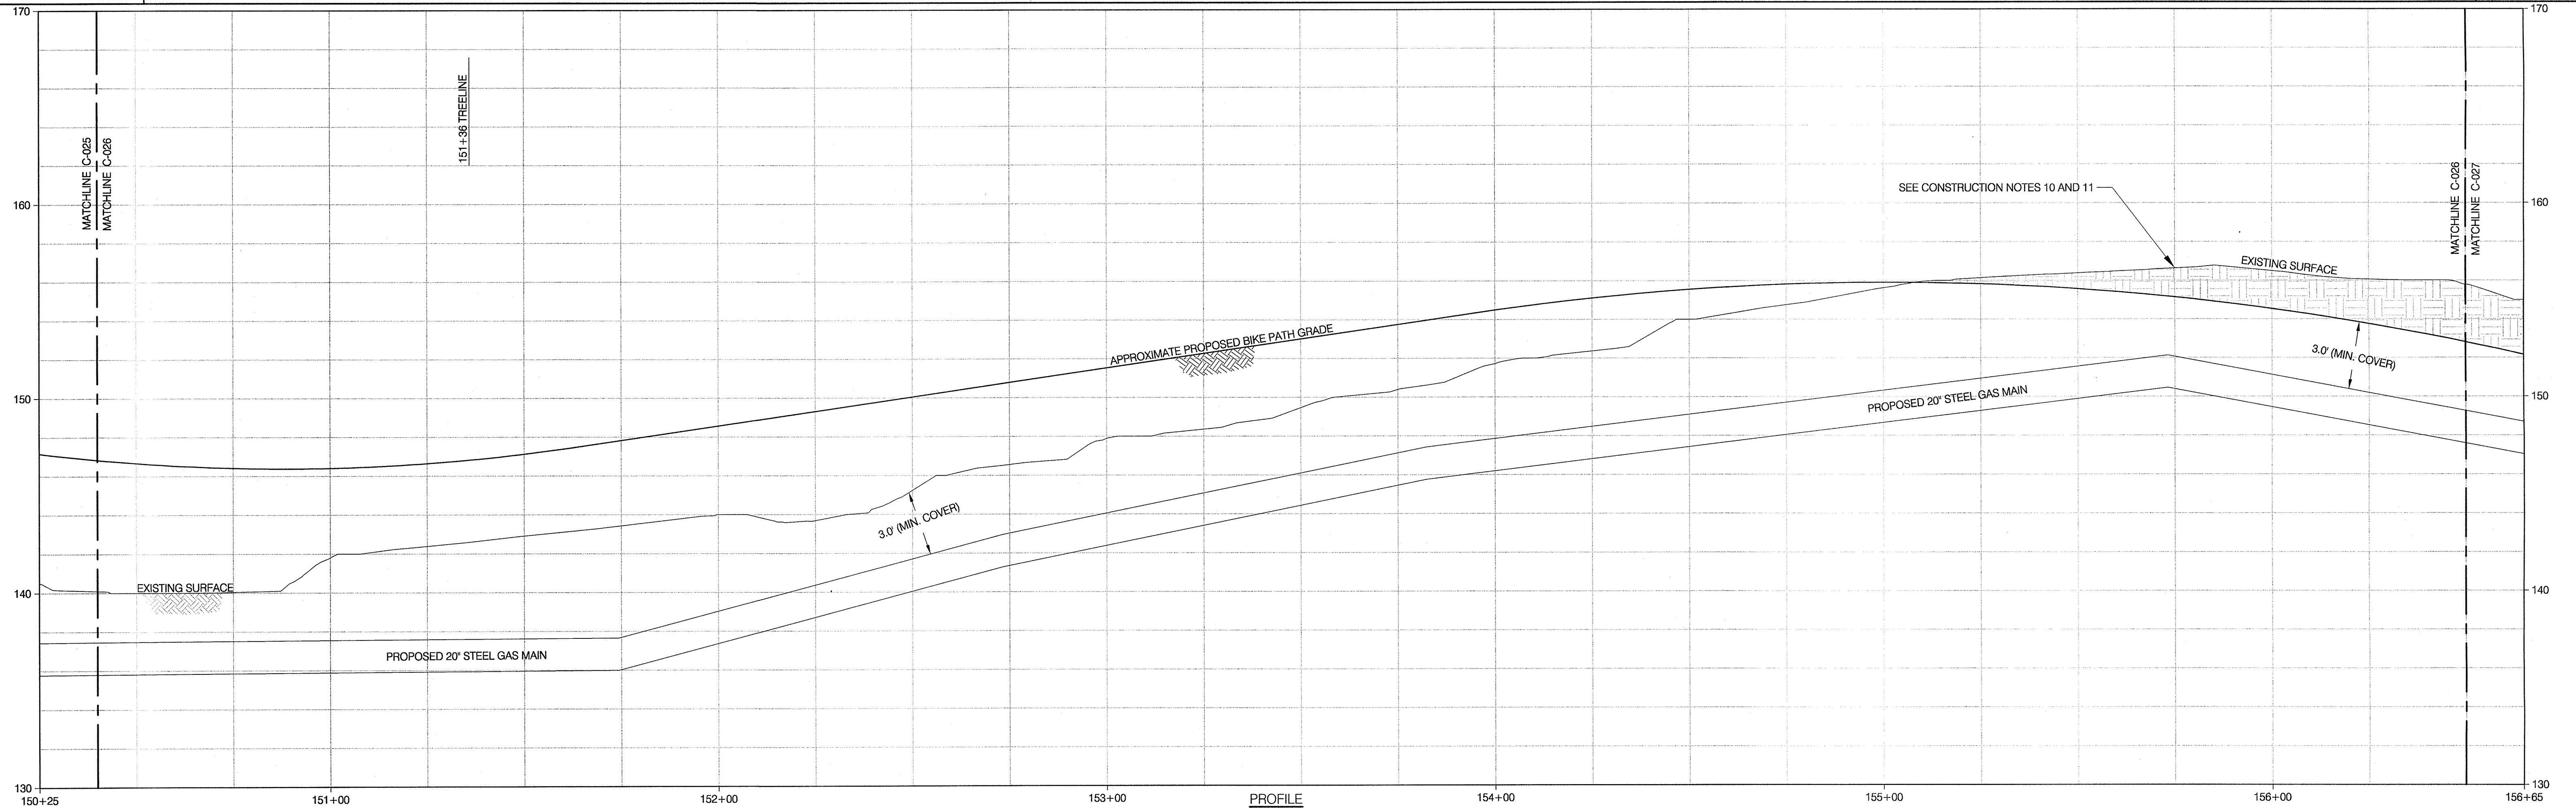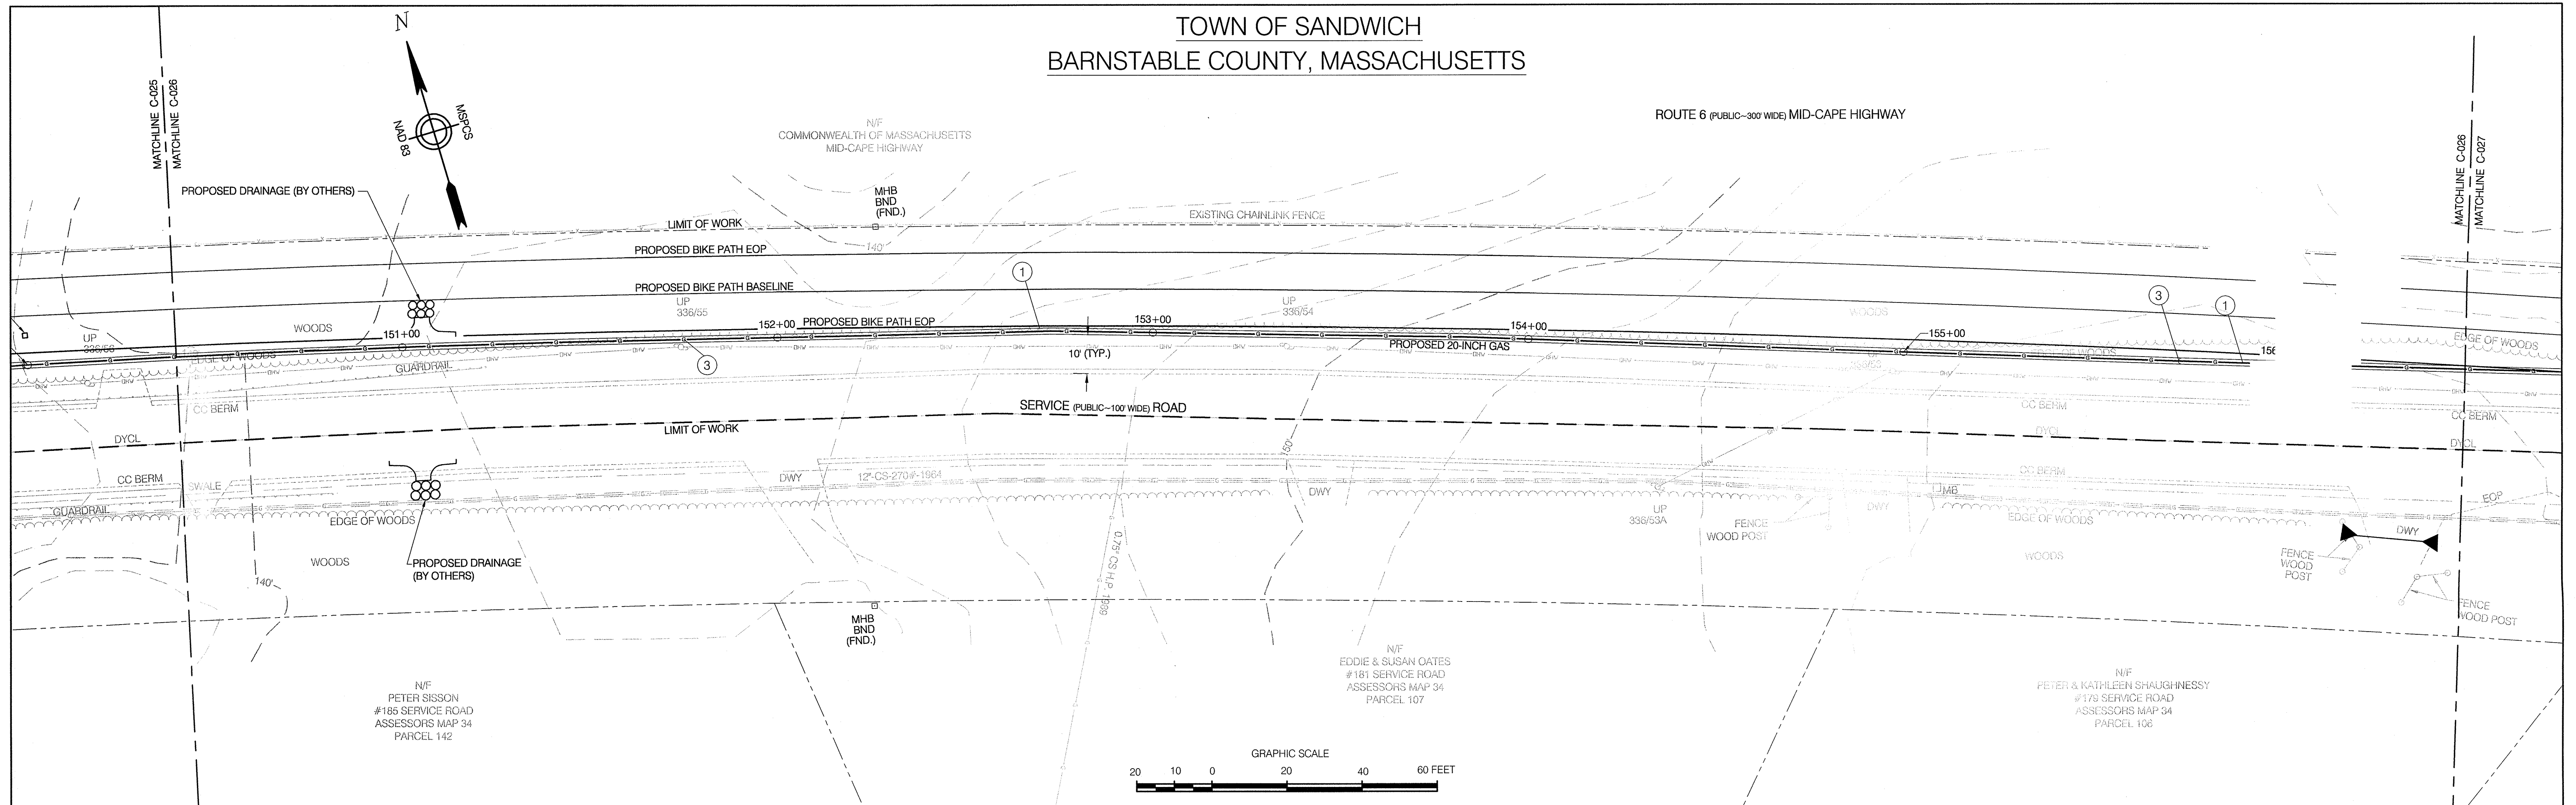[illegible]

Design/Engineering

Prepared For:


CHA

COLONIAL GAS COMPANY
d/b/a
nationalgrid

GAS ENGINEERING DEPARTMENT
46 SYLVAN RD.
WALTHAM, MA 02451

330 Bear Hill Road, Suite 304
Waltham, MA 02451

Main: (781) 982-7650 • www.chacompanies.com


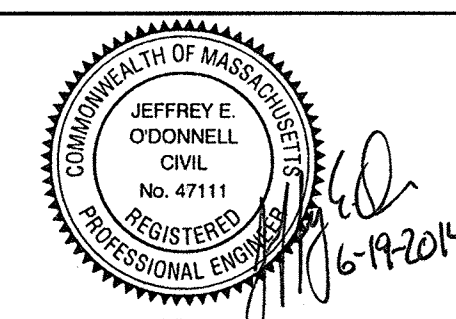


NATIONAL GRID SERVICE COMPANY, USA
SERVICE ROAD ALIGNMENT
SANDWICH, MA
BARNSTABLE COUNTY, MASSACHUSETTS




File No.: 15-646.01 ALIGN.dwg

APPROVED BY	
DATE: SEPTEMBER 7, 2012	MANAGER
NATIONAL GRID SERVICE COMPANY, USA	
15-646.01-C-026	

TOWN OF SANDWICH
BARNSTABLE COUNTY, MASSACHUSETTS

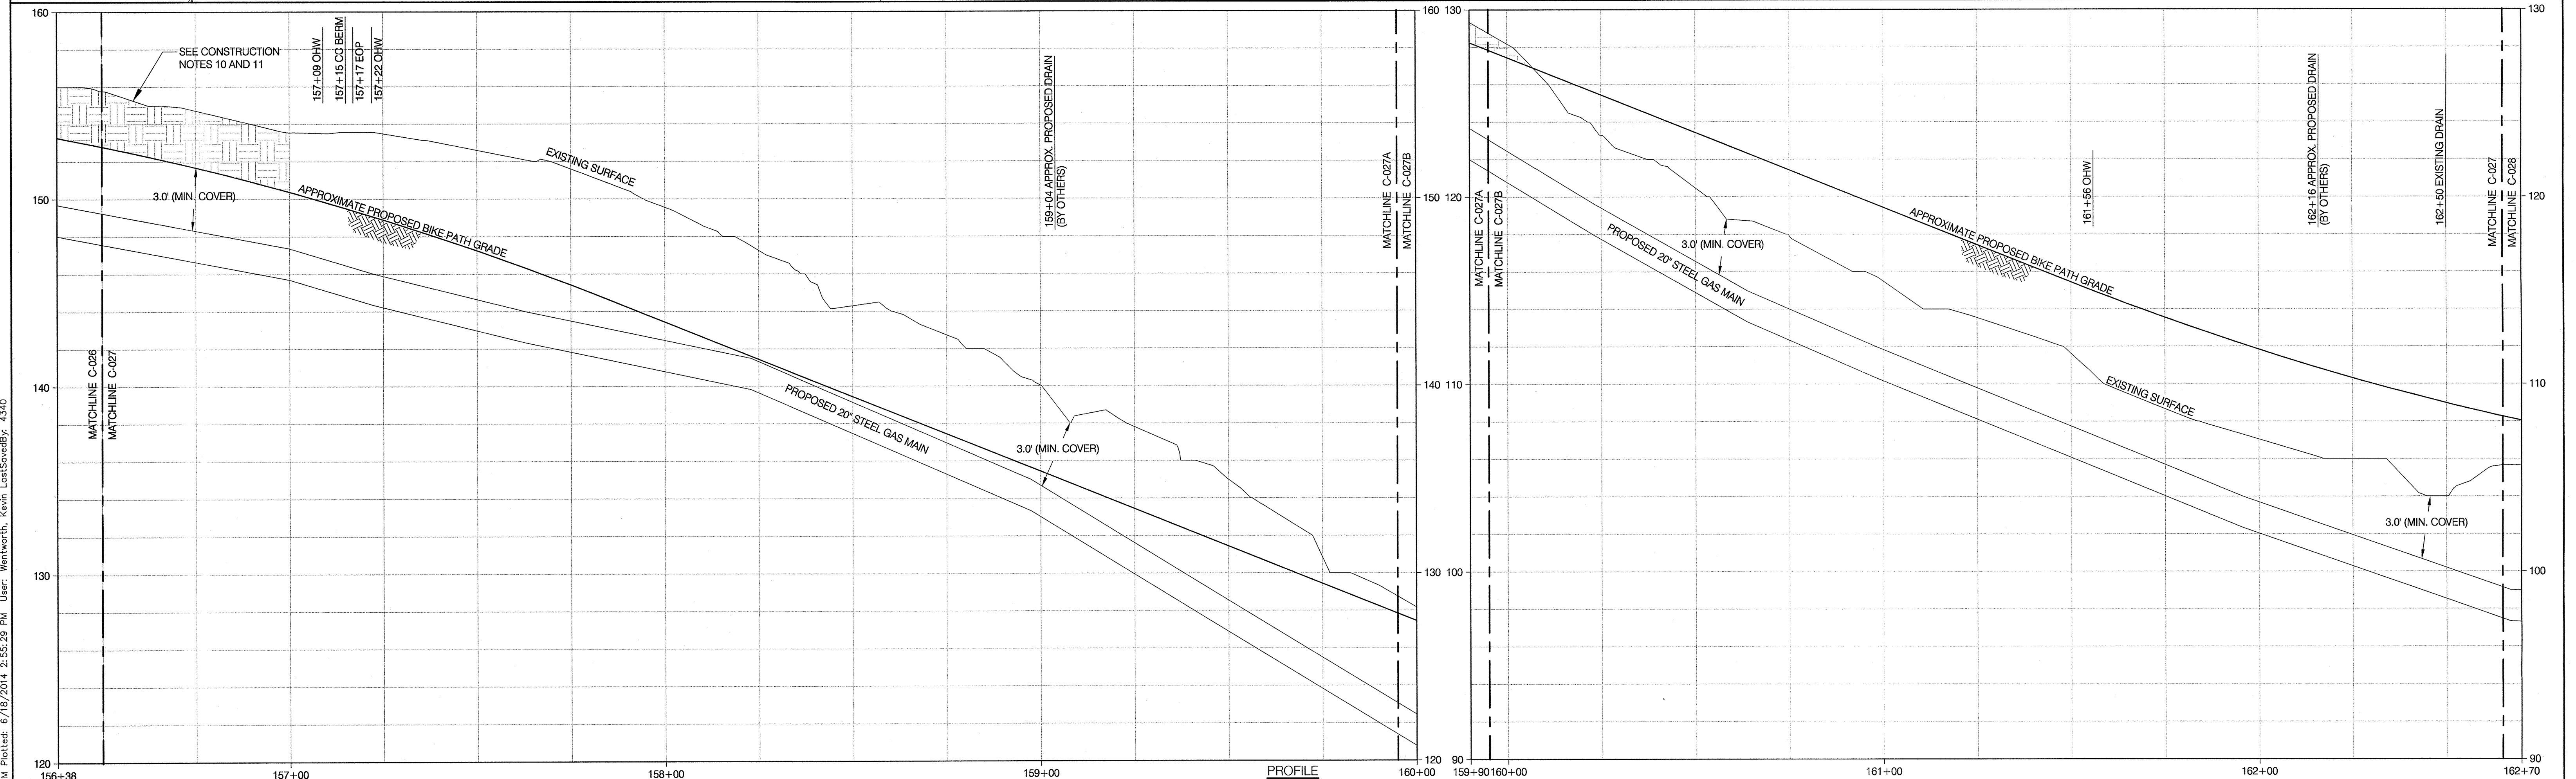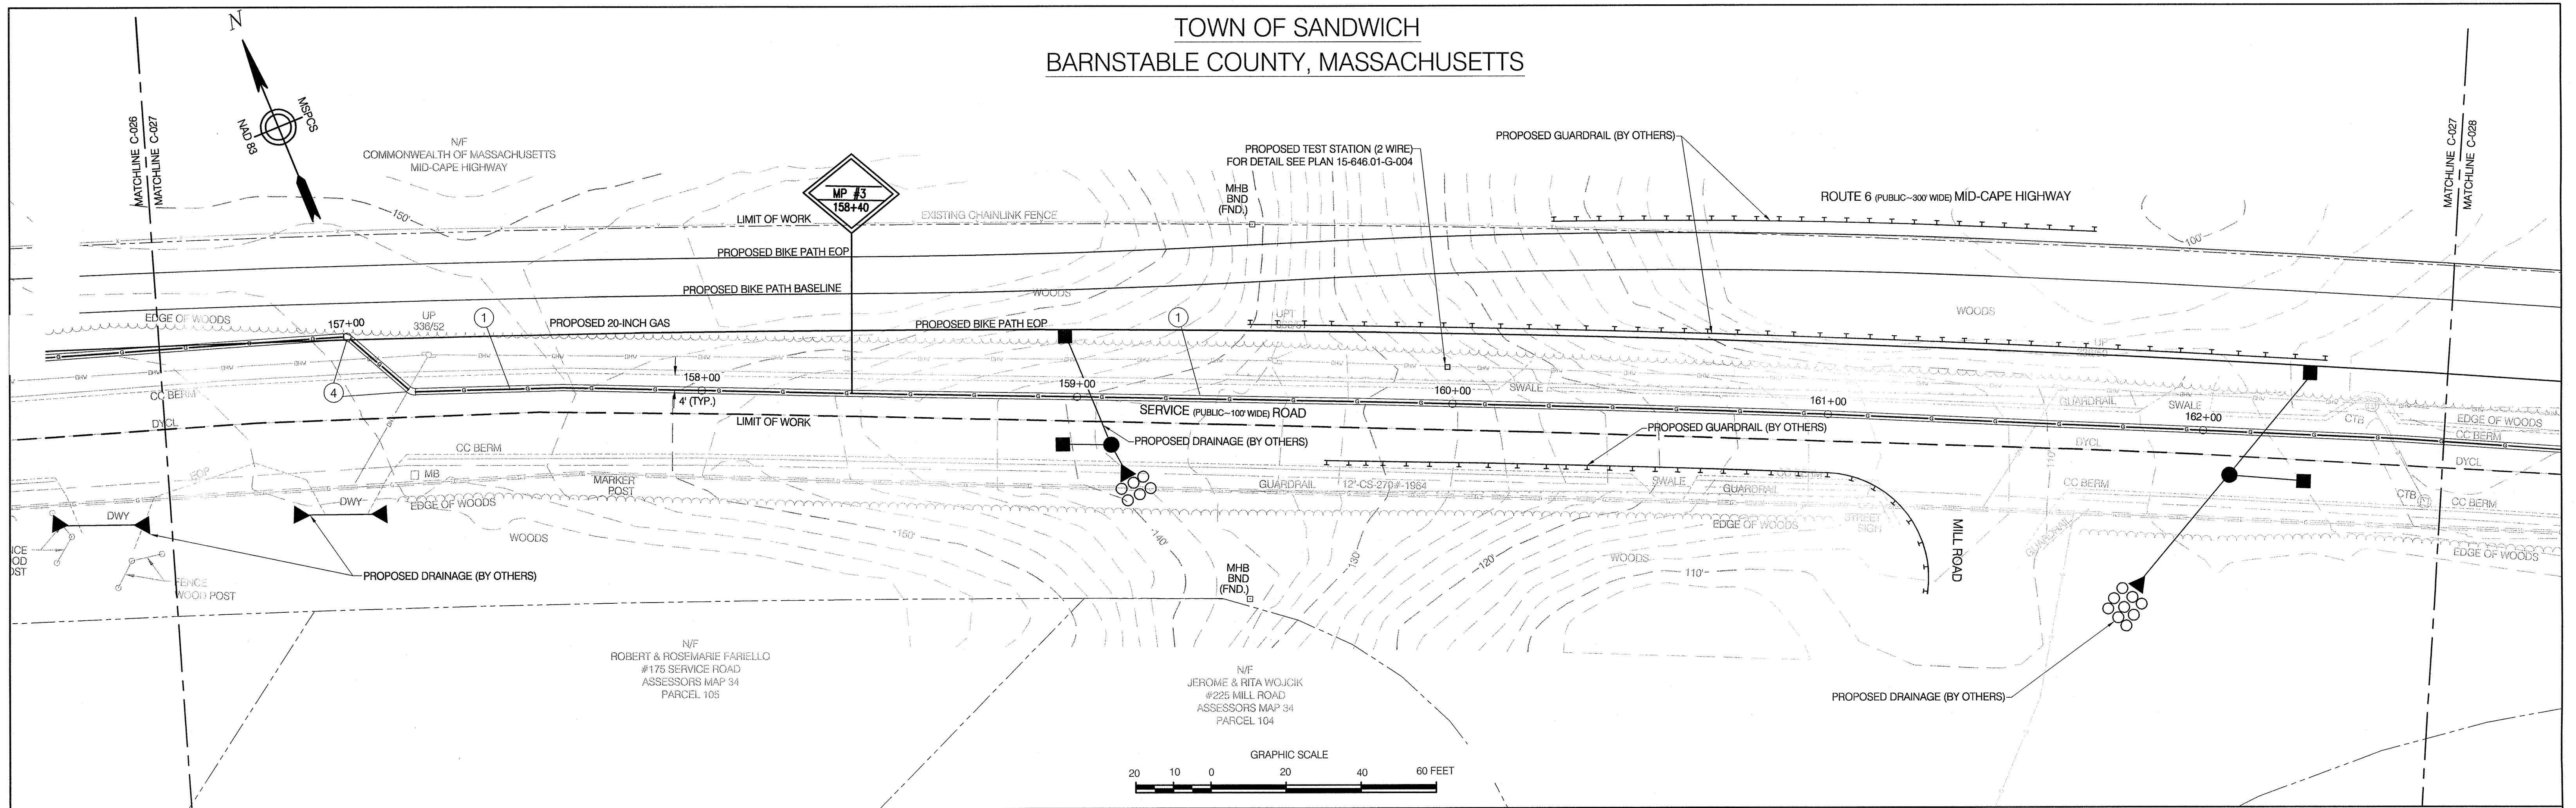[illegible]

 TOWN OF SANDWICH
BARNSTABLE COUNTY, MASSACHUSETTS

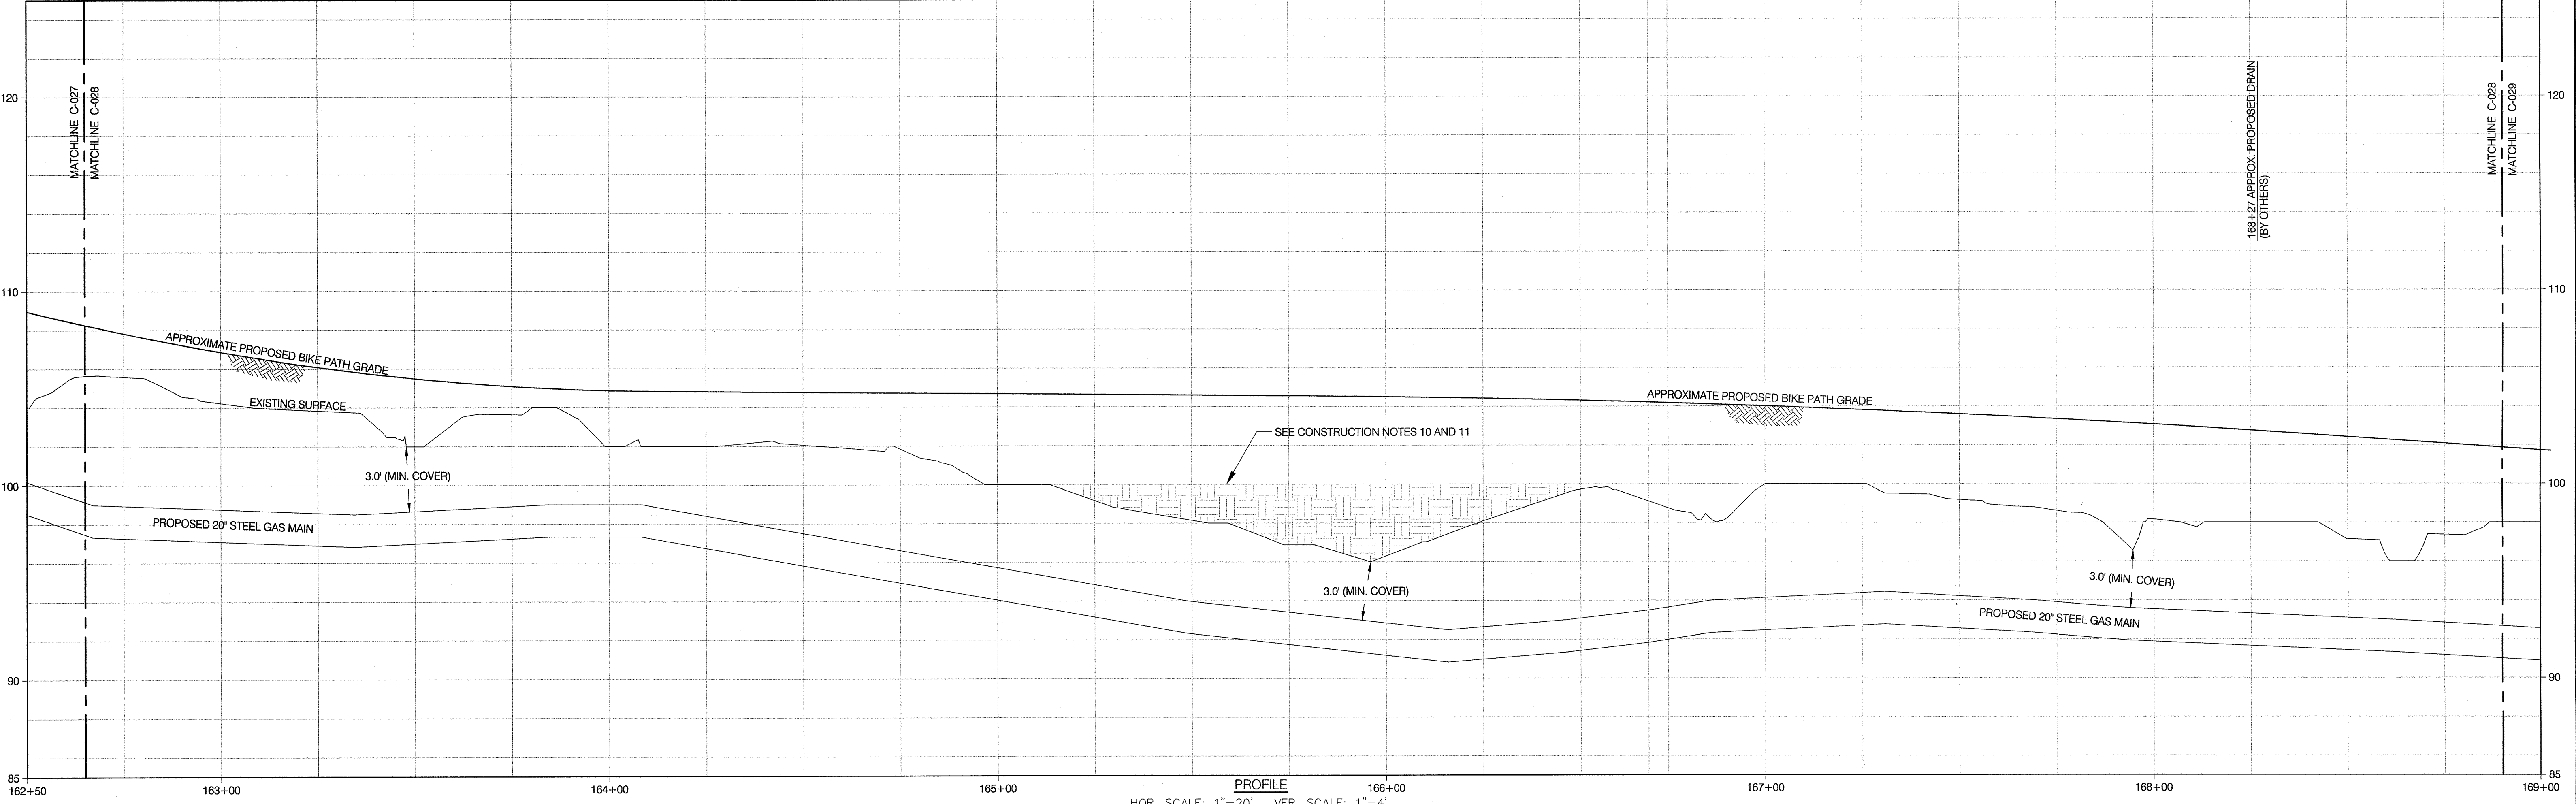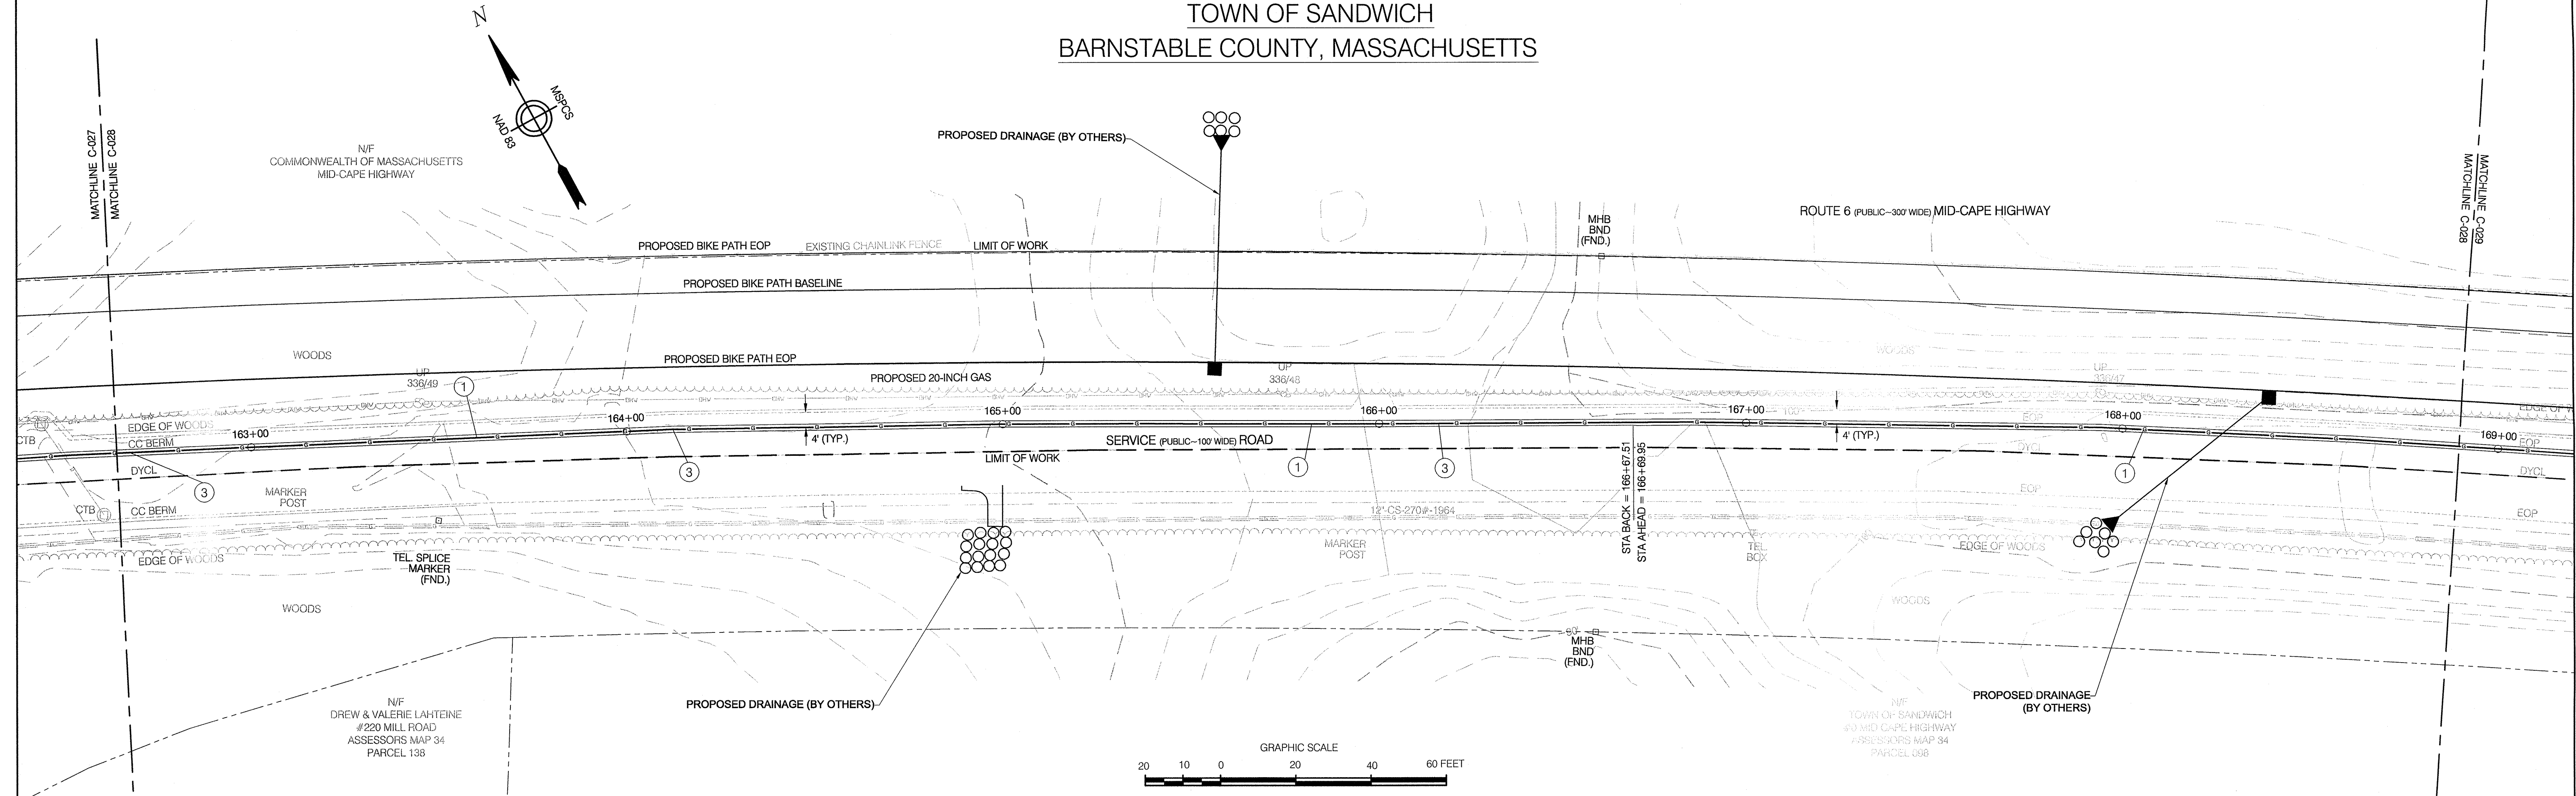


File: W:\NATIONAL GRID\2011 RFP 01\01 SANDWICH\DRAWINGS\15-646.01 ALIGN 24-38_REV 0 (ISSUED FOR FINAL EFSB APPROVAL).DWG
Saved: 6/18/2014 2:44:48 PM Plotted: 6/18/2014 2:56:10 PM User: Wenworth, Kevin LastSavedBy: 4340

REFERENCE DRAWINGS				REVISIONS			
DRAWING NO.	TITLE	DRAWING NO.	TITLE	NO.	DATE	REMARKS	
				0	6/14	REVISED FOR FINAL EFSB APPROVAL	





COLONIAL GAS COMPANY
d/b/a
nationalgrid
GAS ENGINEERING DEPARTMENT
40 SILVAM RD.
WALTHAM, MA 02451

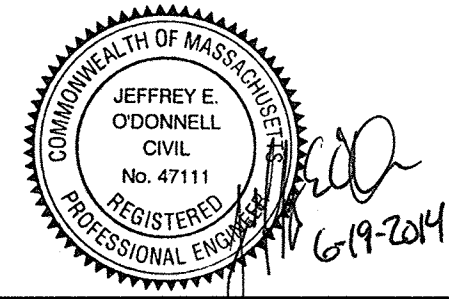

NATIONAL GRID SERVICE COMPANY, USA
SERVICE ROAD ALIGNMENT
SANDWICH, MA
BARNSTABLE COUNTY, MASSACHUSETTS
File No.: 15-646.01 ALIGN.dwg

APPROVED BY
DATE: SEPTEMBER 7, 2012
MANAGER
NATIONAL GRID SERVICE COMPANY, USA
15-646.01-C-028

TOWN OF SANDWICH
BARNSTABLE COUNTY, MASSACHUSETTS

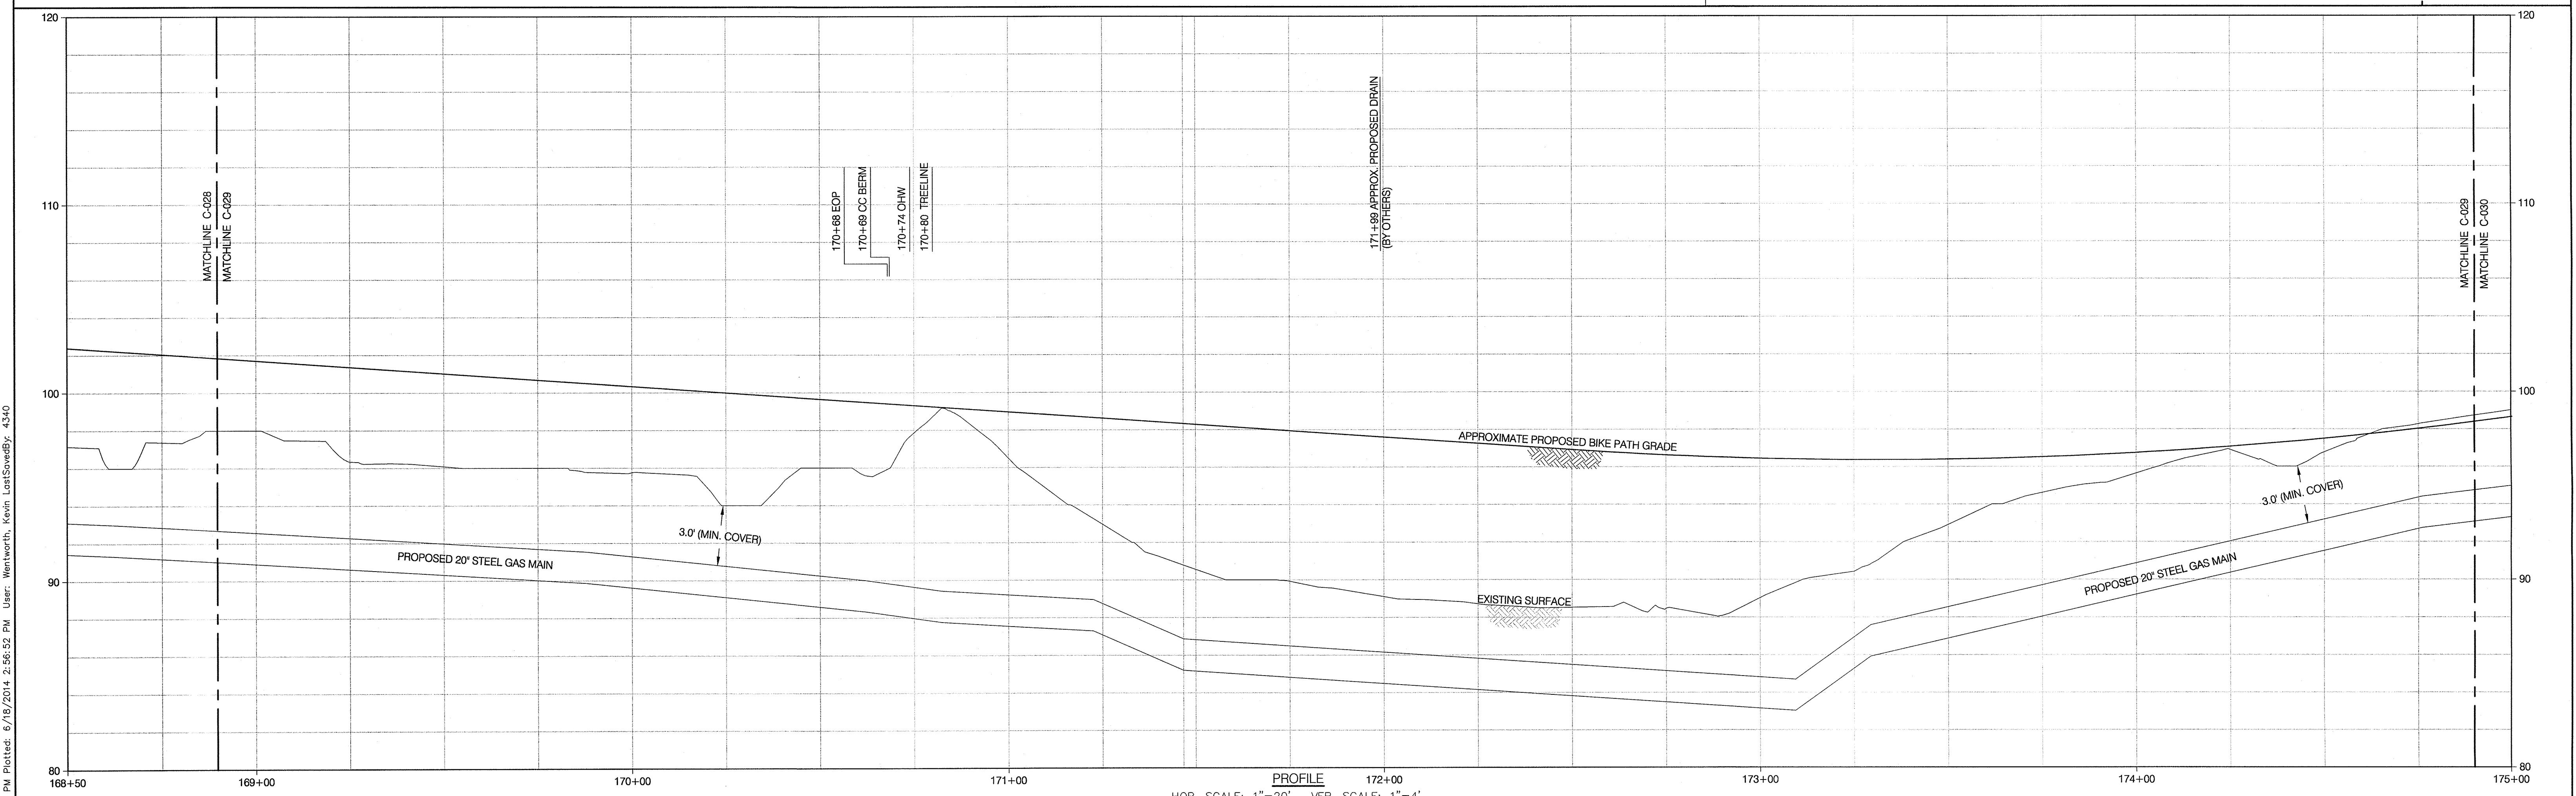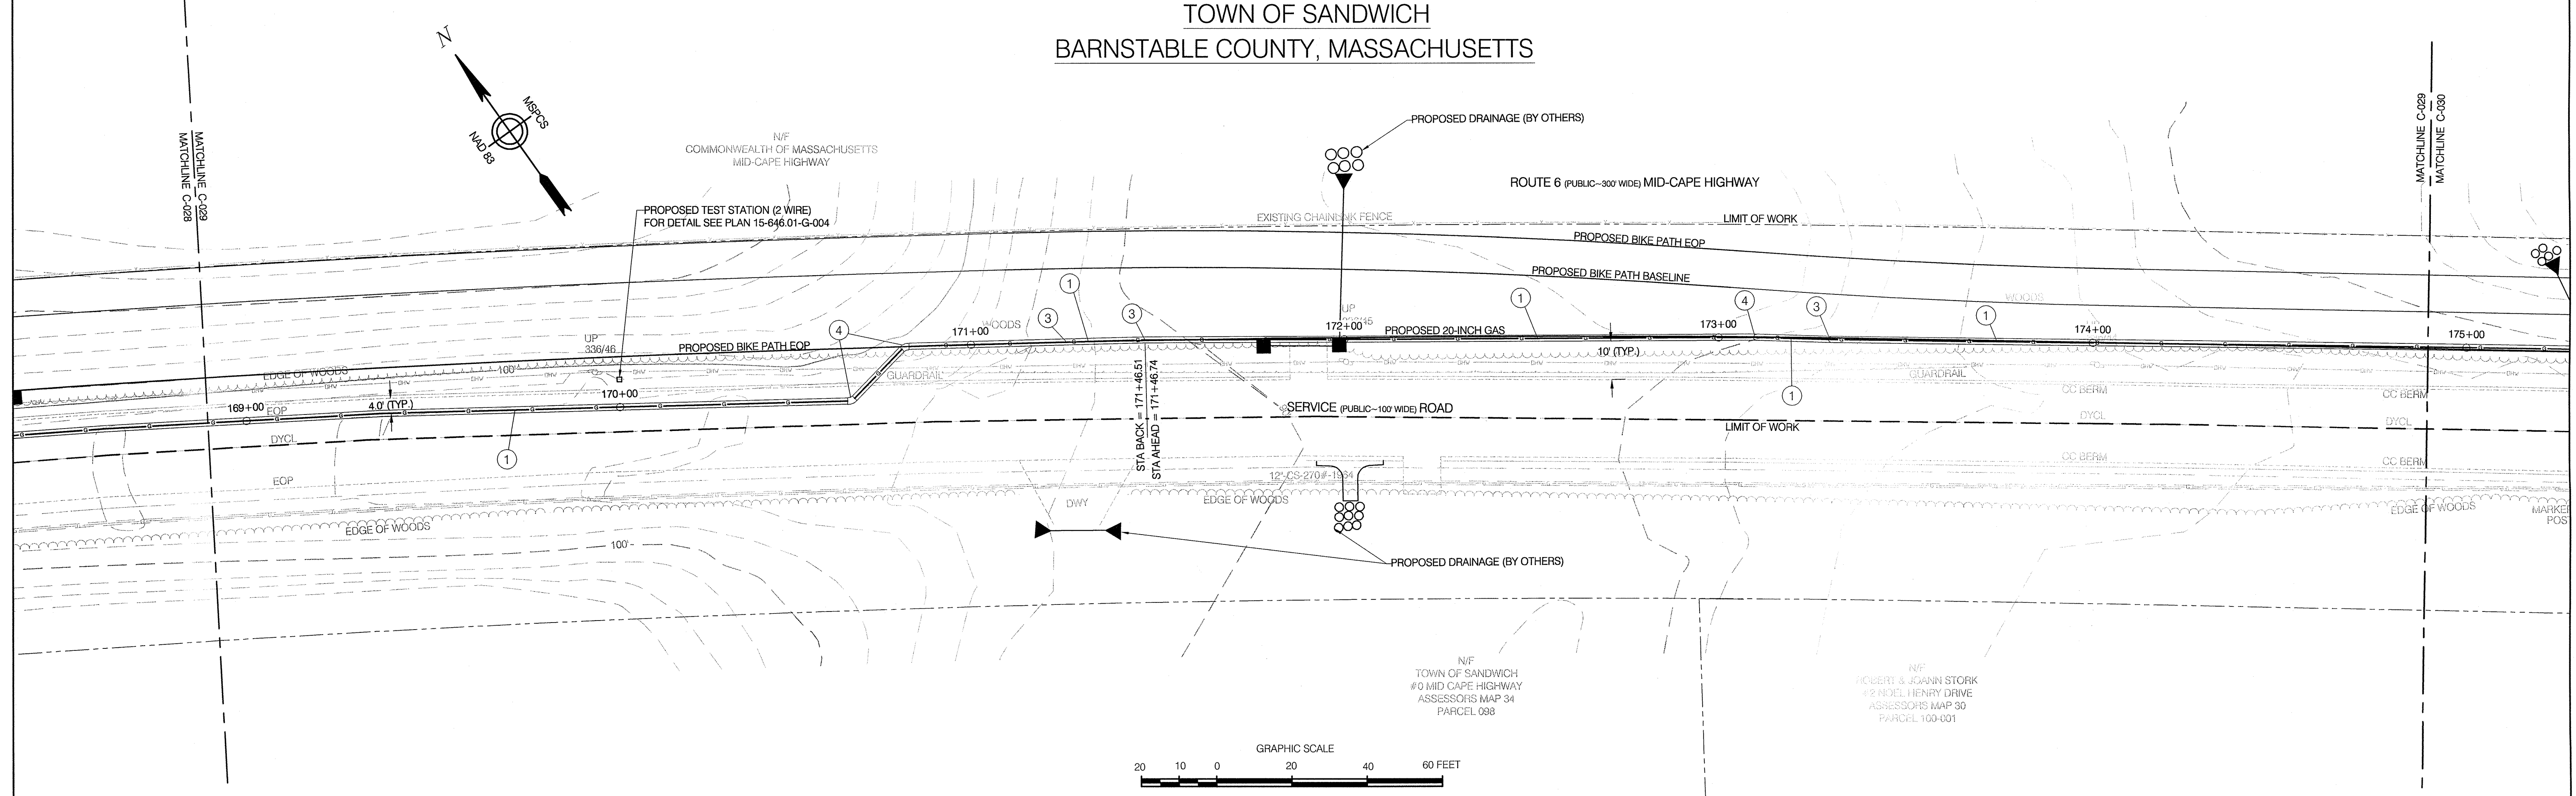

REFERENCE DRAWINGS				REVISIONS						
DRAWING NO.	TITLE	DRAWING NO.	TITLE	NO.	DATE	REMARKS	REV.	CKD.	COR.	APP.
				0	5/14	REVISED FOR FINAL EFSB APPROVAL	KDW	SAB	KDW	JEO

CIA
330 Bear Hill Road, Suite 304
Waltham, MA 02451
Main: (781) 982-7850 www.chacompanies.com



nationalgrid
GAS ENGINEERING DEPARTMENT
40 SYLVAN RD.
WALTHAM, MA 02451

NATIONAL GRID SERVICE COMPANY, USA
SERVICE ROAD ALIGNMENT
SANDWICH, MA
BARNSTABLE COUNTY, MASSACHUSETTS
File No.: 15-646.01 ALIGN.dwg

APPROVED BY
DATE: SEPTEMBER 7, 2012
MANAGER
NATIONAL GRID SERVICE COMPANY, USA
15-646.01-C-029

File: W:\NATIONAL GRID\2011 RFP_01\01 SANDWICH\DRAWINGS\15-646.01 ALIGN_24-38_REV C (ISSUED FOR FINAL EFSB APPROVAL).DWG
Saved: 6/18/2014 2:44:48 PM Plotted: 6/18/2014 2:56:32 PM User: Wentworth, Kevin LastSavedBy: 4340

TOWN OF SANDWICH
BARNSTABLE COUNTY, MASSACHUSETTS

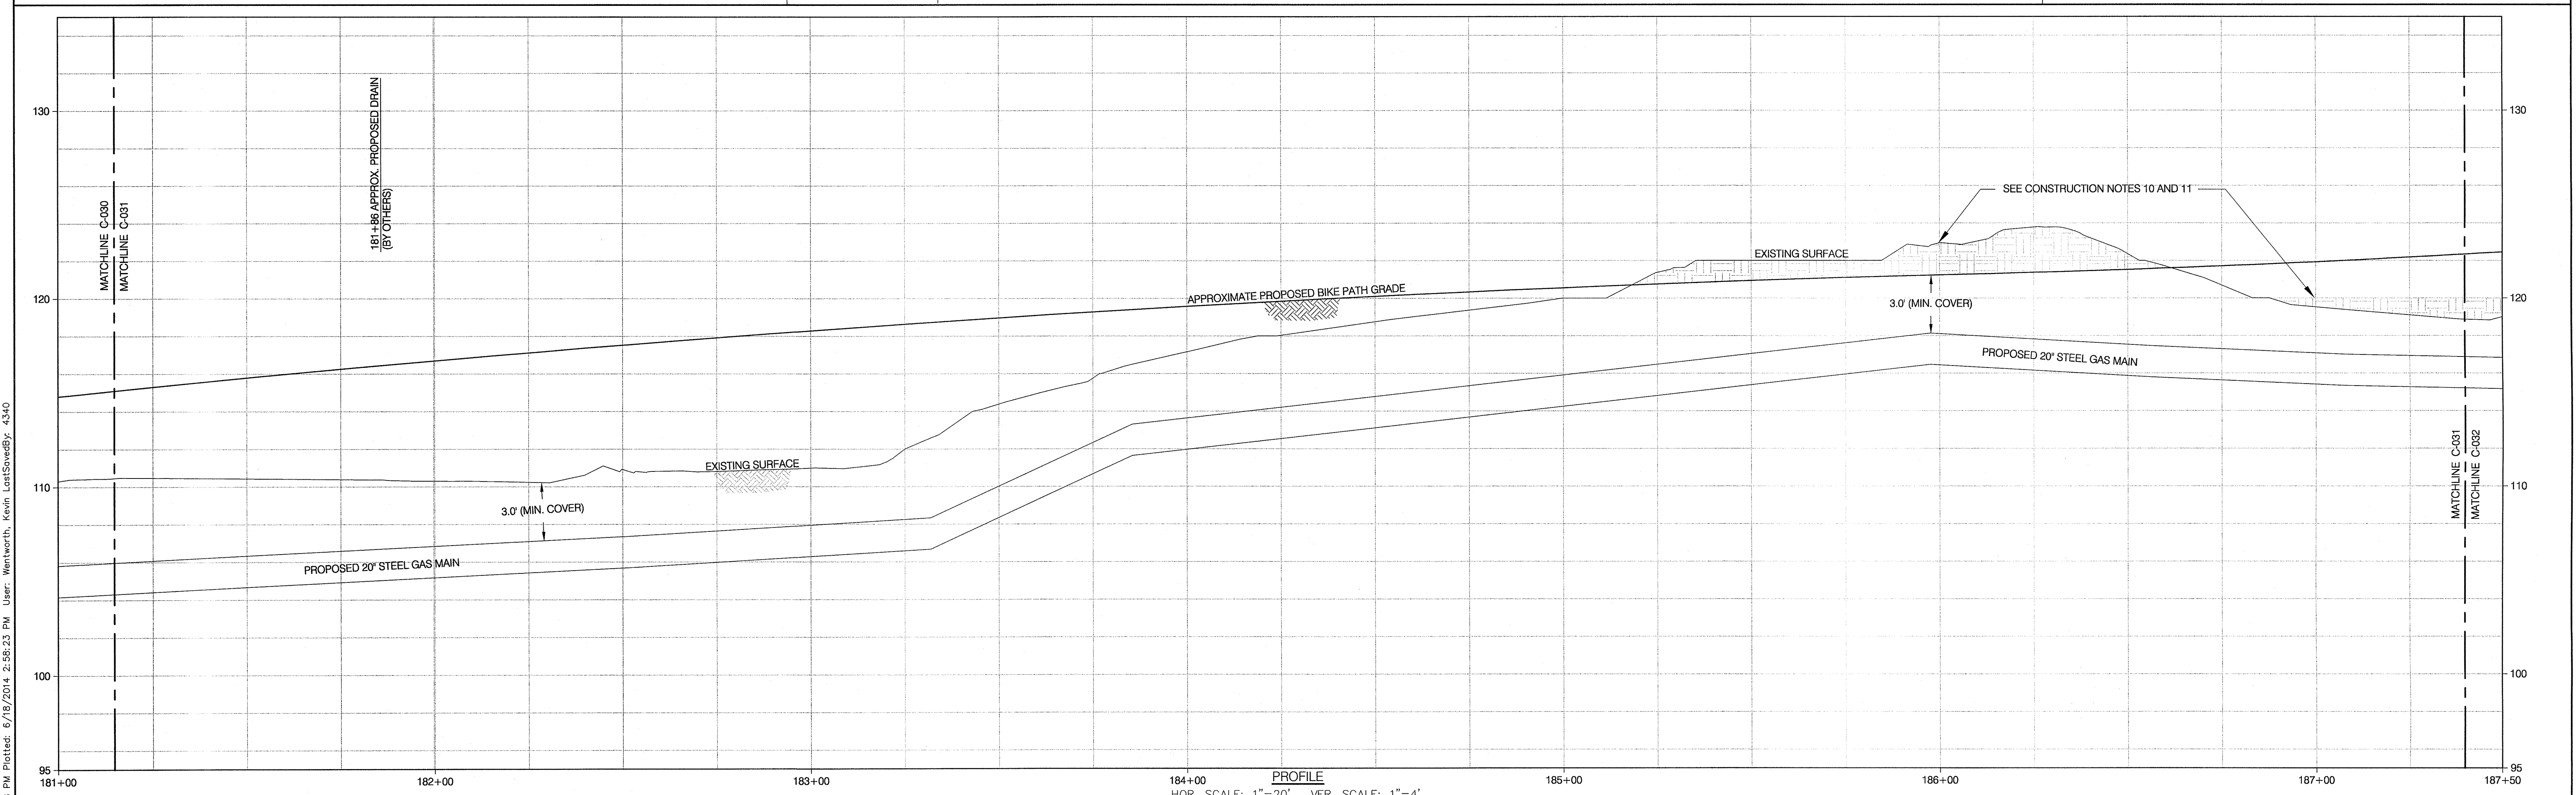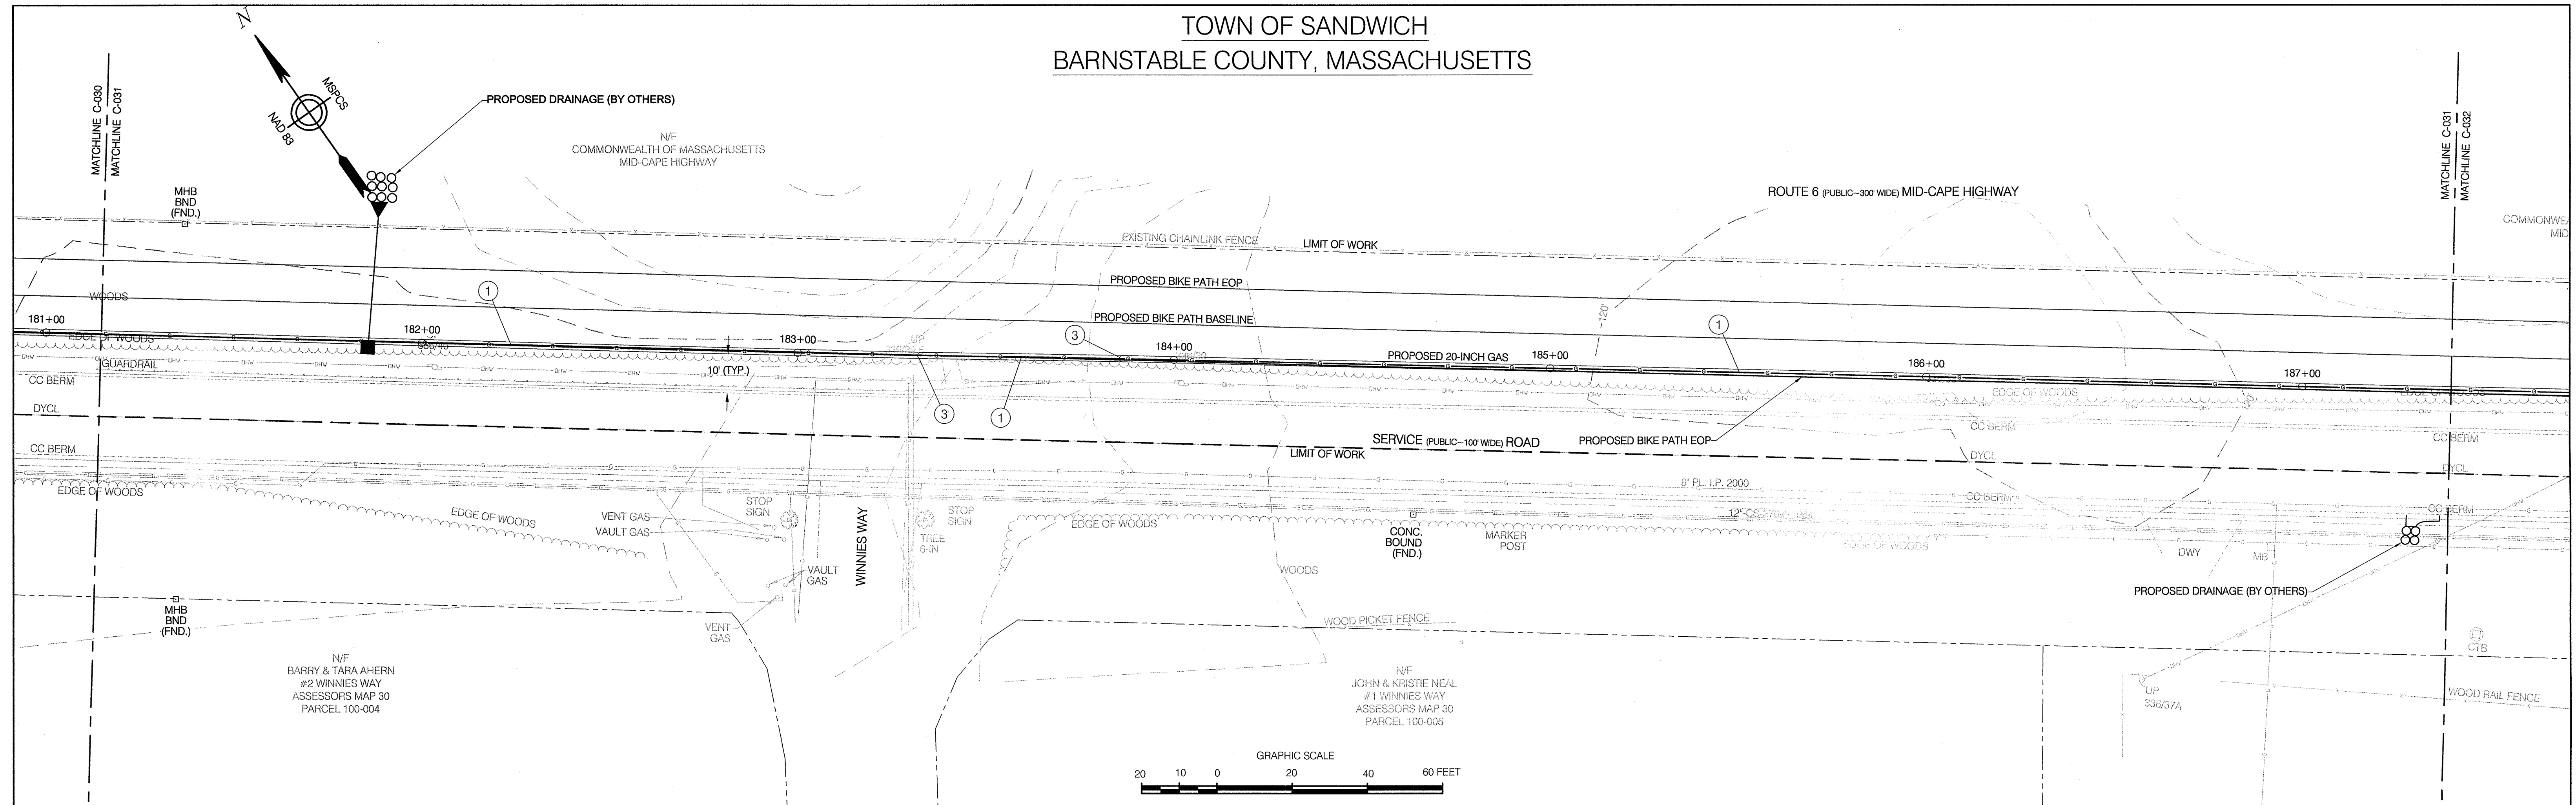

REFERENCE DRAWINGS				REVISIONS						
DRAWING NO.	TITLE	DRAWING NO.	TITLE	NO.	DATE	REMARKS	REV.	OKD.	COR.	APP.
				0	8/14	REVISED FOR FINAL EFSB APPROVAL	KDW	SAB	KDW	JEO

Design/Engineering

Prepared For:

COLONIAL GAS COMPANY
d/b/a
nationalgrid
GAS ENGINEERING DEPARTMENT
40 SYLVAN RD.
WALTHAM, MA 02451
Main: (781) 982-7850 • www.ngscorporates.com

JEFFREY E. O'DONNELL
CIVIL
No. 47111
REGISTERED
PROFESSIONAL ENGINEER

NATIONAL GRID SERVICE COMPANY, USA
SERVICE ROAD ALIGNMENT
SANDWICH, MA
BARNSTABLE COUNTY, MASSACHUSETTS
File No.: 15-646.01 ALIGN.dwg

 

APPROVED BY

DATE: SEPTEMBER 7, 2012


MANAGER

NATIONAL GRID SERVICE COMPANY, USA


15-646.01-C-031

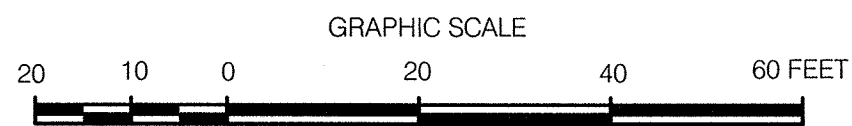



P 0	Design/Engineering	Prepared For:
		COLONIAL GAS COMPANY d/b/a nationalgrid GAS ENGINEERING DEPARTMENT 40 SYLVAN RD. WALTHAM, MA 02451
	330 Bear Hill Road, Suite 304 Waltham, MA 02451 Main: (781) 902-7650 • www.chacompanies.com	

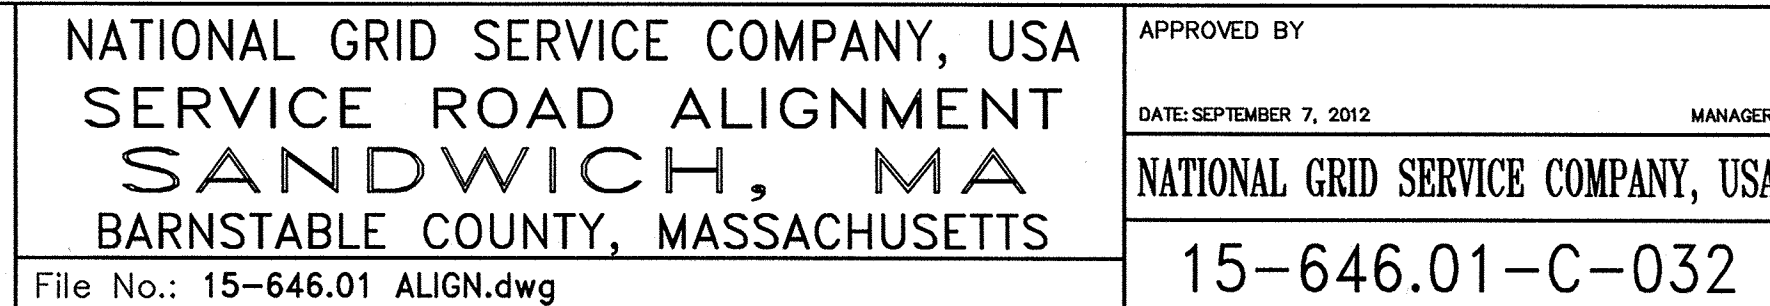


N/F
COMMONWEALTH OF MASSACHUSETTS
MID-CAPE HIGHWAY

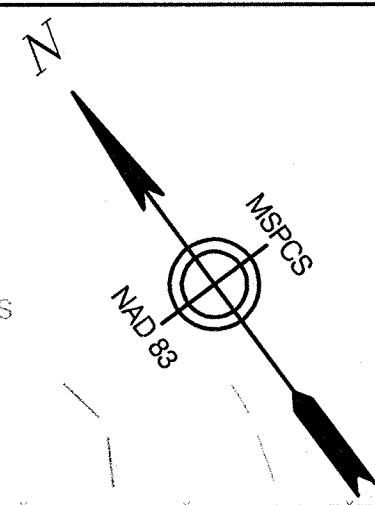

ROUTE 6 (PUBLIC~300' WIDE) MID-CAPE HIGHWAY

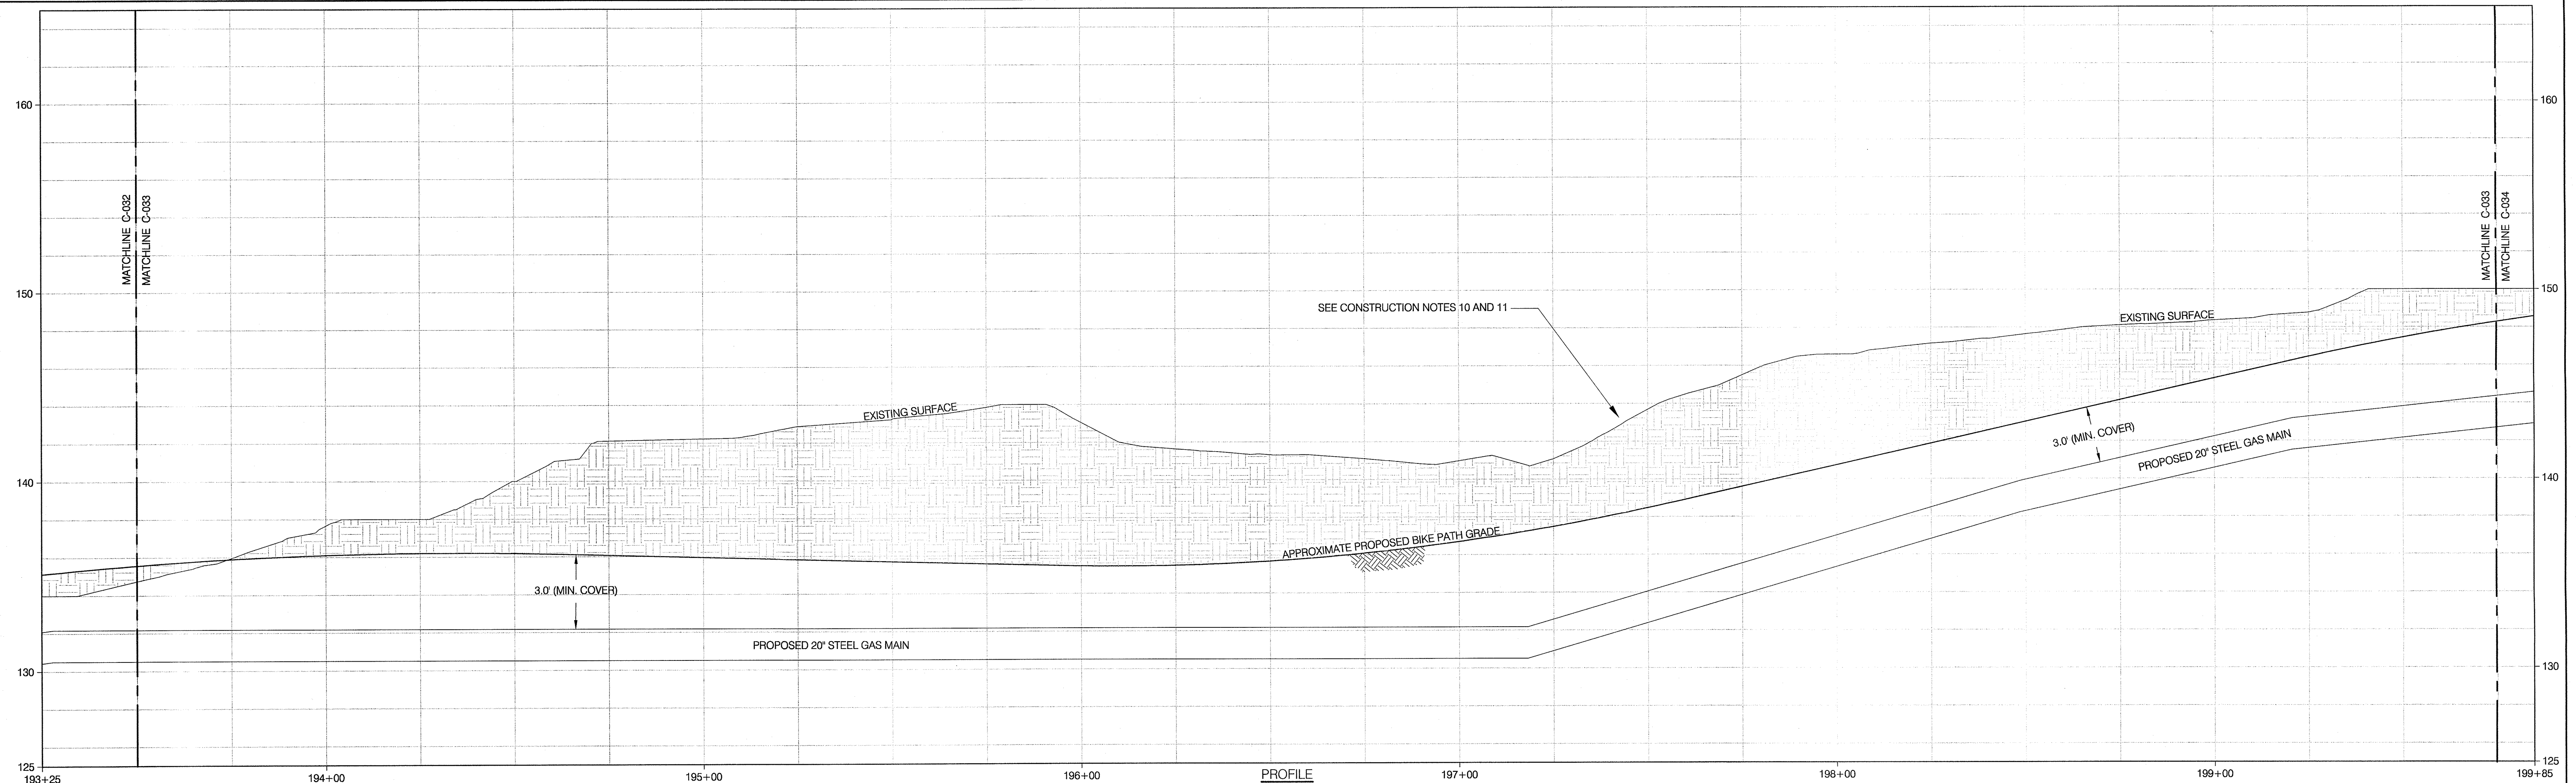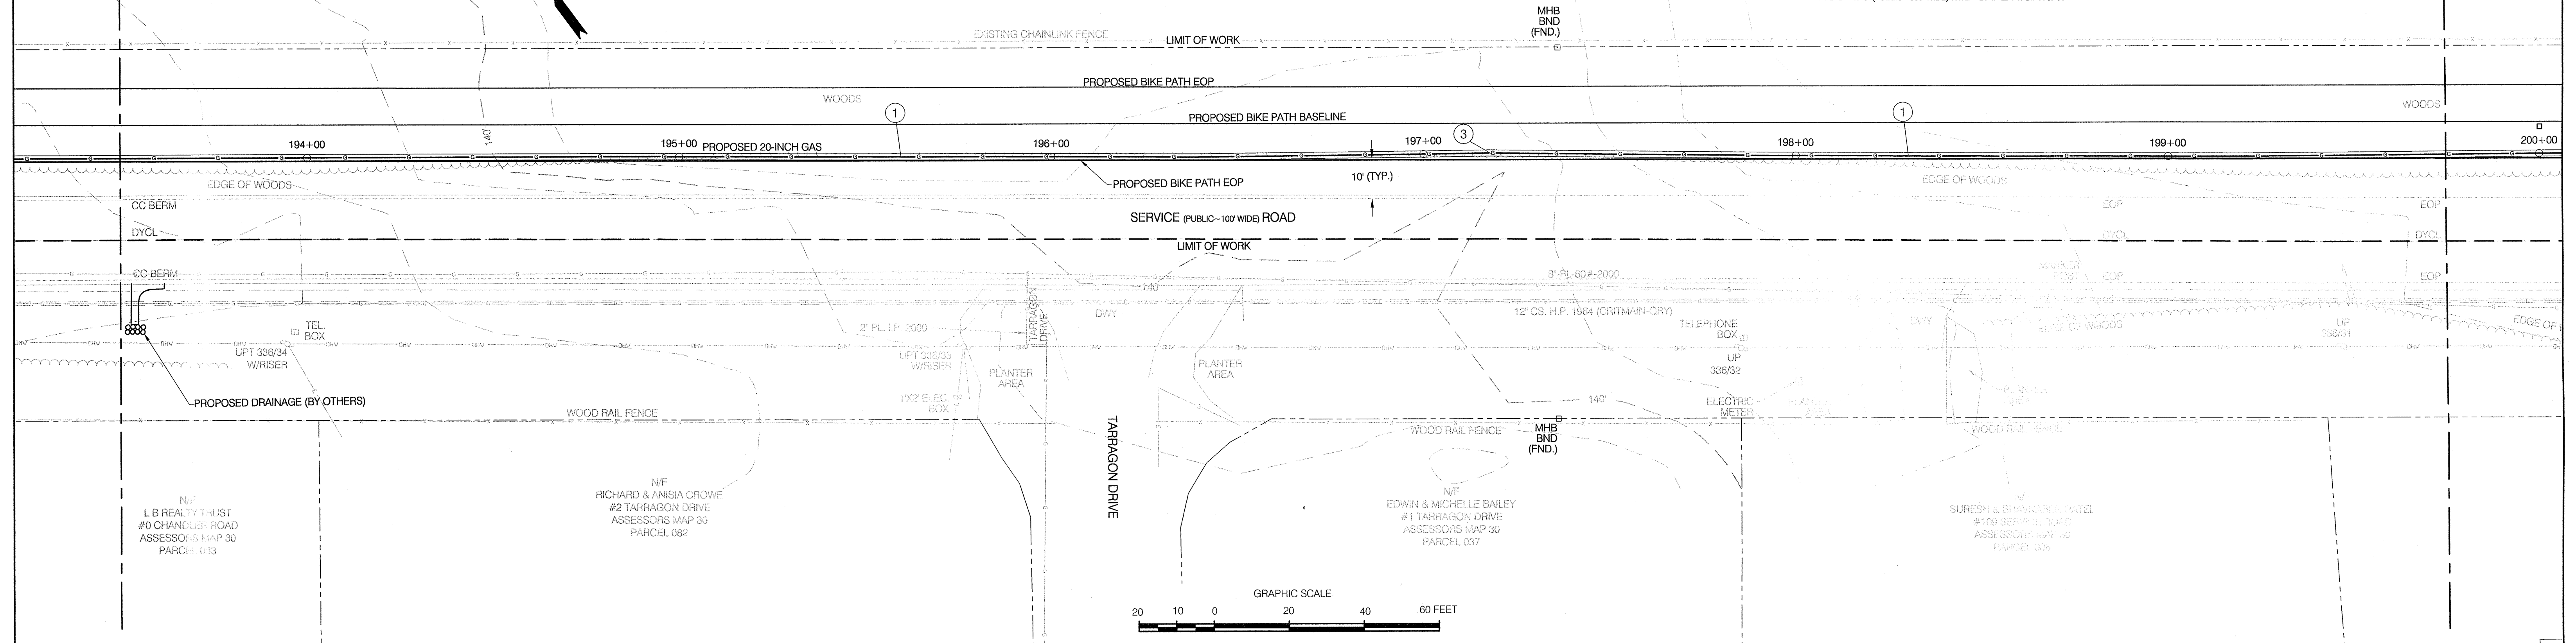[illegible]

COLONIAL GAS COMPANY
d/b/a
nationalgrid
GAS ENGINEERING DEPARTMENT
40 SYLVAN RD.
WALTHAM, MA 02451


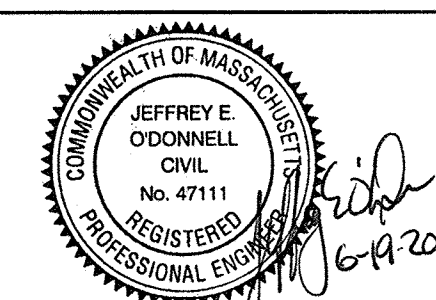


NATIONAL GRID SERVICE COMPANY, USA
SERVICE ROAD ALIGNMENT
SANDWICH, MA
BARNSTABLE COUNTY, MASSACHUSETTS

File No.: 15-646.01 ALIGN.dwg

APPROVED BY	
DATE: SEPTEMBER 7, 2012	MANAGER
NATIONAL GRID SERVICE COMPANY, USA	
15-646.01-C-033	

 A map of the state of Massachusetts. A line representing a road or path runs from the top left towards the bottom right. A circle is drawn on this line, with the text 'NAD 83' written below it. To the right of the circle, the text 'MSPCS' is written. In the top left corner, there is a north arrow pointing towards the top left, labeled with a large 'N'. The word 'MASSACHUSETTS' is written in the bottom left corner.


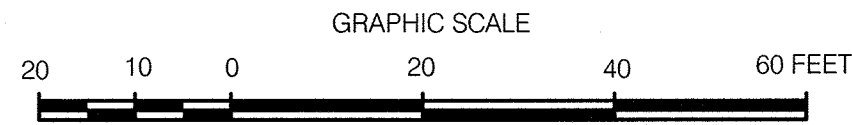


CHA
330 Bear Hill Road, Suite 304
Waltham, MA 02451
Main: (781) 862-7650 • www.chacompanies.com



APPROVED BY	
DATE: SEPTEMBER 7, 2012	MANAGER
NATIONAL GRID SERVICE COMPANY, USA	
15-646.01-C-034	

 A map of the study area in the Commonwealth of Massachusetts. The map shows the Cape Cod Canal, the Cape Cod National Seashore (MSPCS), and the Mid-Cape Highway (N/A 83). The highway is shown as a line with arrows indicating traffic flow. The map also shows the location of the Cape Cod Canal and the Cape Cod National Seashore (MSPCS).

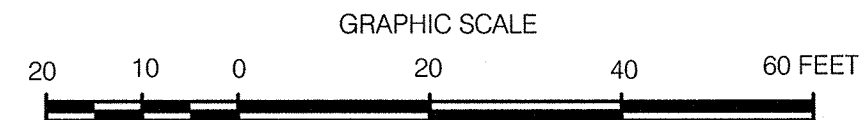

CHA
330 Bear Hill Road, Suite 304
Waltham, MA 02451
Main: (781) 982-7650 • www.chacompanies.com

APPROVED BY	
DATE: SEPTEMBER 7, 2012	MANAGER
NATIONAL GRID SERVICE COMPANY, USA	
15-646.01-C-035	

**TOWN OF SANDWICH
BARNSTABLE COUNTY, MASSACHUSETTS**

ROUTE 6 (PUBLIC-300' WIDE) MID-CAPE HIGHWAY

SERVICE (PUBLIC-100' WIDE) ROAD

MAPLE SWAMP ROAD

PROPOSED BIKE PATH EOP
PROPOSED BIKE PATH BASELINE
PROPOSED 20-INCH GAS

LIMIT OF WORK
EXISTING CHAINLINK FENCE
GUARDRAIL
SWALE
CC-BERM
DYCL
EDGE OF WOODS
WOODS
PROPOSED DRAINAGE (BY OTHERS)
UP 336/23
UP 336/22
UP 336/21
MARKER POST
EDGE OF PLANTER
SIGN
12" CS. H.P. 1864 (CRITMAIN-GRV)
6" PL-60#-2002
10' (TYP.)
1

N/F COMMONWEALTH OF MASSACHUSETTS MID-CAPE HIGHWAY


N/F TOWN OF SANDWICH #67 SERVICE ROAD ASSESSORS MAP 30 PARCEL 012


N/F MARK, PATRICIA & MIRINDA TYO #2 MAPLE SWAMP ROAD ASSESSORS MAP 30 PARCEL 246

N/F VIRGINIA BRISTOL #1 MAPLE SWAMP ROAD ASSESSORS MAP 30 PARCEL 015

MATCHLINE C-035
MATCHLINE C-036
MATCHLINE C-037
MATCHLINE C-038


GRAPHIC SCALE
20 10 0 20 40 60 FEET

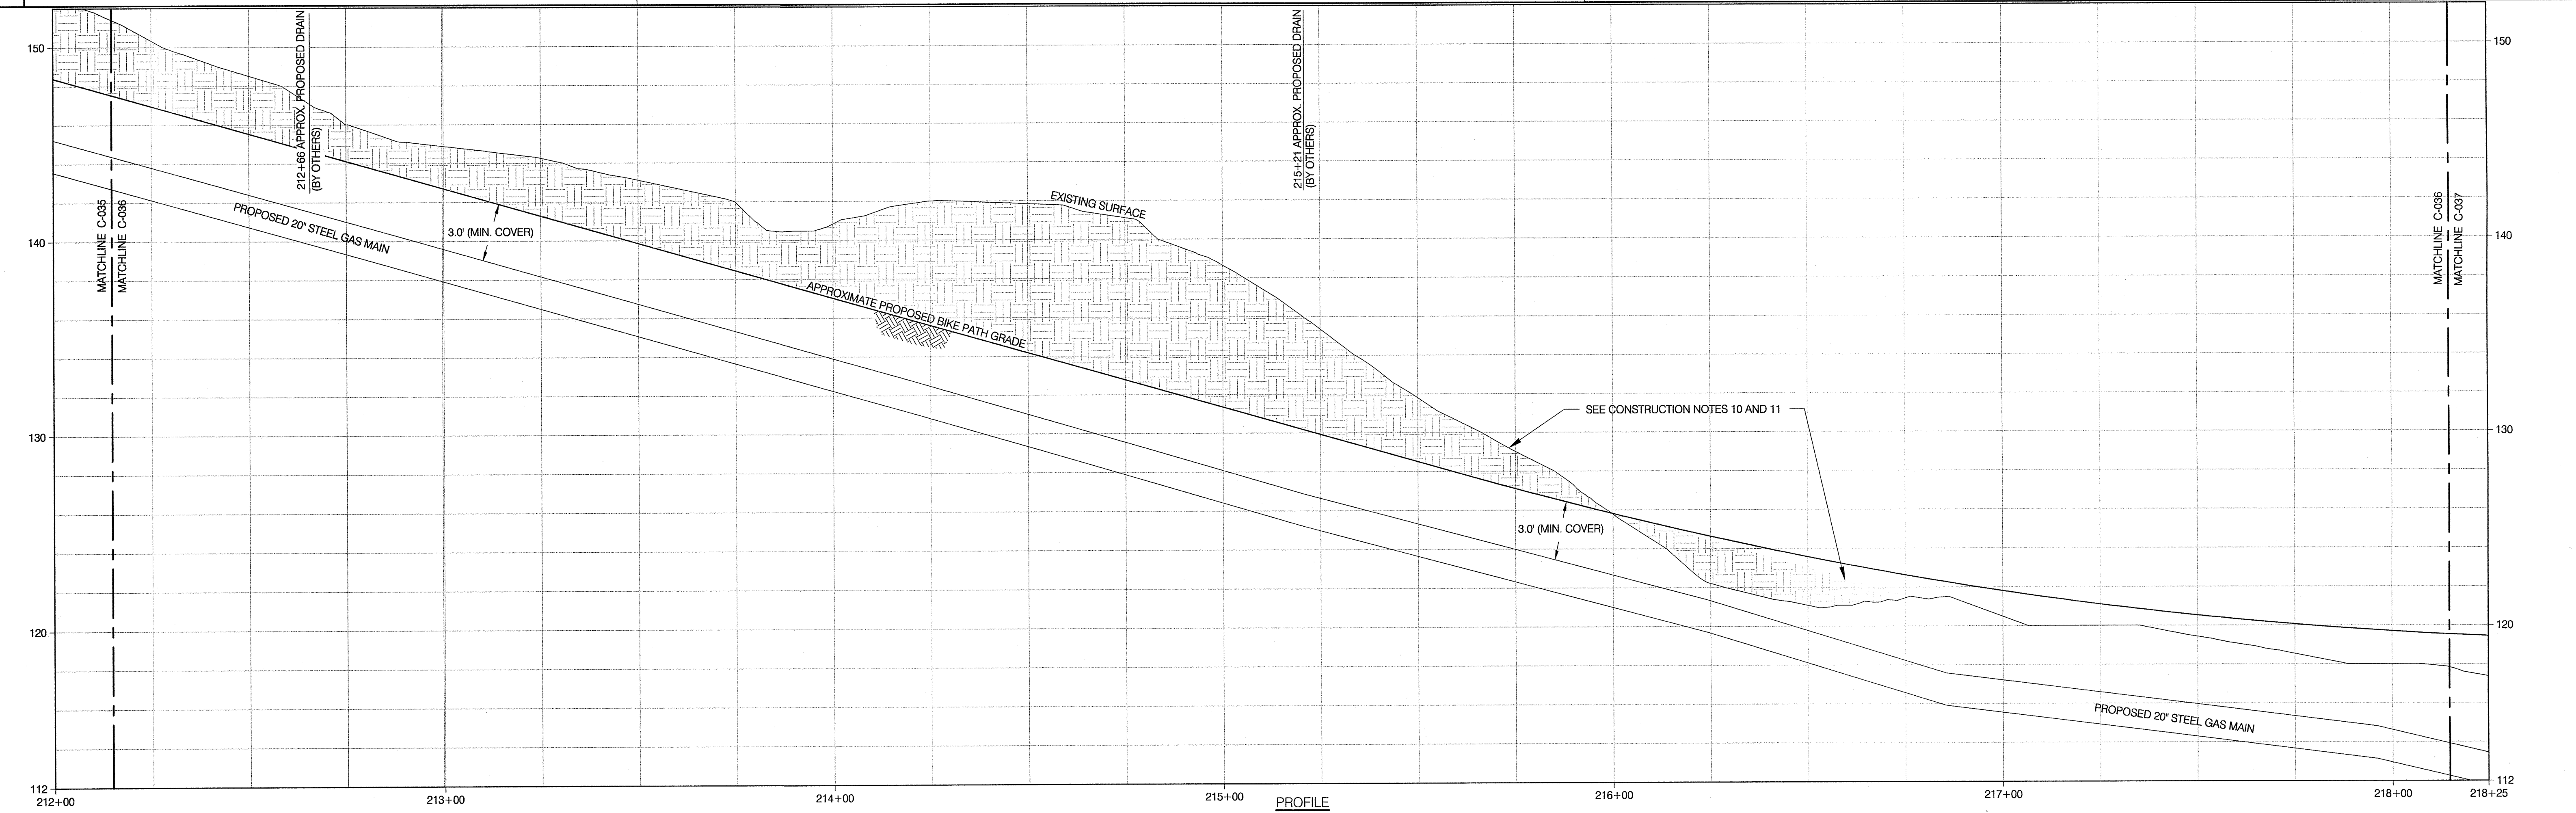[illegible]

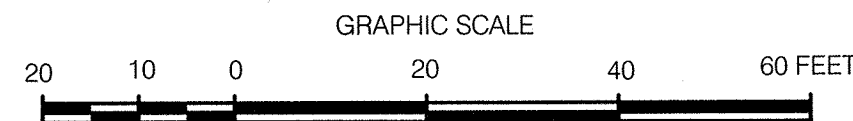

CHA
330 Bear Hill Road, Suite 304
Waltham, MA 02451
Main: (781) 982-7650 • www.chacompanies.com

COLONIAL GAS COMPANY
d/b/a
nationalgrid
GAS ENGINEERING DEPARTMENT
40 SYLVAN RD.
WALTHAM, MA 02451

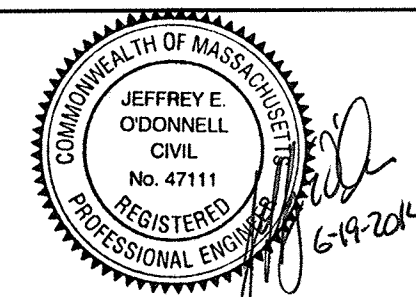

NATIONAL GRID SERVICE COMPANY, USA
SERVICE ROAD ALIGNMENT
SANDWICH, MA
BARNSTABLE COUNTY, MASSACHUSETTS

 

File No.: 15-646.01 ALIGN.dwg

APPROVED BY _____


DATE: SEPTEMBER 7, 2012 _____ MANAGER

NATIONAL GRID SERVICE COMPANY, USA

15-646.01-C-037


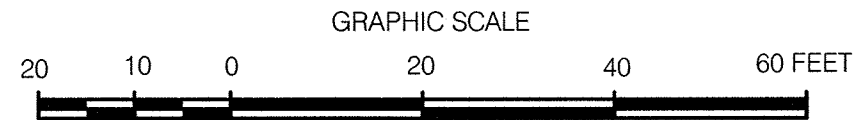


HOR. SCALE: 1"=20'		VER. SCALE: 1"=4'	
Design/Engineering		Prepared For:	
		COLONIAL GAS COMPANY	
		a/b/a	
		nationalgrid	
330 Bear Hill Road, Suite 304 Waltham, MA 02451		GAS ENGINEERING DEPARTMENT 40 SYLVAN RD. WALTHAM, MA 02451	
Main: (781) 852-7650 - www.ciandcompanies.com			

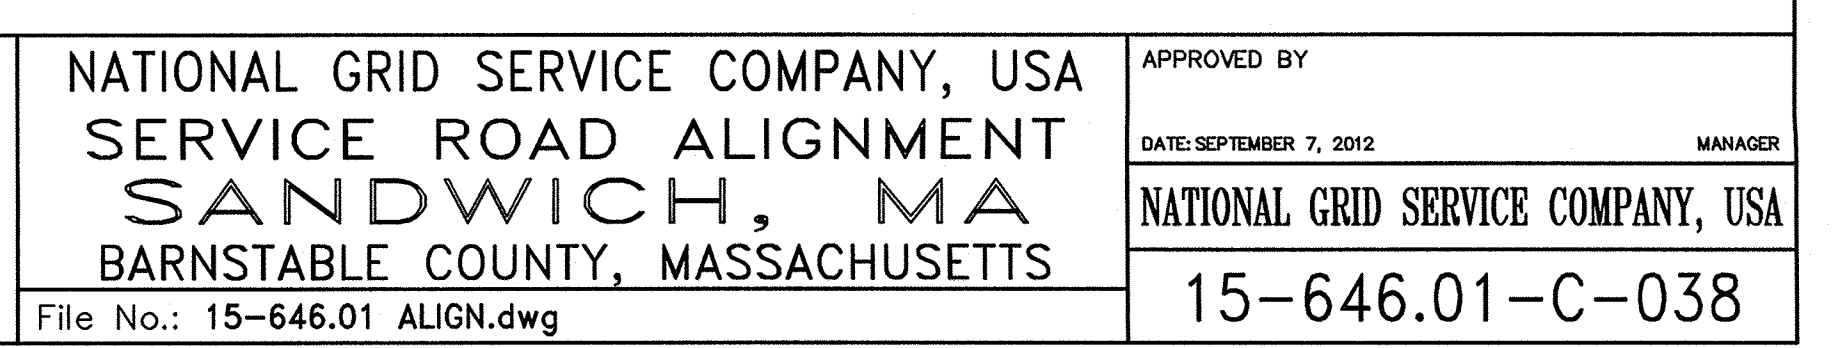

GENERAL NOTES

1. SITE DETAIL SHOWN HEREON IS BASED UPON TOPOGRAPHIC DETAIL SURVEY CONDUCTED BY COLER & COLANTONIO, INC. IN JULY 2011 AND DETAIL SURVEY PROVIDED BY BSC.
2. PROPERTY LINES SHOWN HEREON ARE BASED ON TAX MAP LOCATION AND DO NOT REPRESENT A PROPERTY LINE RETRACEMENT SURVEY EFFORT.
3. LOCATION OF ANY IDENTIFIED UNDERGROUND UTILITIES IS APPROXIMATE ONLY, AND IS NOT WARRANTED TO BE CORRECT. ADDITIONAL UTILITIES MAY EXIST WHICH ARE NOT INDICATED ON THESE PLANS. ALL EXISTING UTILITIES SHALL BE VERIFIED BY THE CONTRACTOR FOR SERVICE, SIZE, INVERT ELEVATIONS, LOCATION, ETC. CONTRACTOR MUST NOTIFY DIG-SAFE AT 1-888-344-7233 AT LEAST 72 HOURS PRIOR TO ANY CONSTRUCTION.
4. SURVEY WAS CONDUCTED IN MASSACHUSETTS MAINLAND ZONE 2001, NAD83 HORIZONTAL COORDINATE SYSTEM. ELEVATIONS ARE BASED ON NAVD 1988, US SURVEY FEET. ELEVATIONS WERE TRANSFERRED TO THIS SITE VIA STATIC GPS SURVEY METHODS AND REFERENCED TO TEMPORARY BENCHMARKS AS SHOWN ON THE PLAN.
5. THE PURPOSE OF THIS PLAN IS TO IDENTIFY TO THE APPROPRIATE PERMITTING AGENCY THE PROPOSED LOCATION FOR A GAS PIPELINE AND ITS LOCATION RELATIVE TO EXISTING UTILITIES WITHIN THE LIMITS OF A ROAD RIGHT-OF-WAY, INCLUDING ELEVATION INFORMATION WHERE OBTAINABLE.
6. THE PROPOSED 20-INCH STEEL PIPE ROAD CROSSING WILL BE CONSTRUCTED VIA PIPE JACKING CONSTRUCTION METHODS.
7. ALL CONSTRUCTION SIGNING, DRUMS, BARRICADES AND OTHER DEVICES SHALL CONFORM WITH PART VI OF THE 2003 MANUAL ON UNIFORM TRAFFIC CONTROL DEVICES (M.U.T.C.D.) REVISION 3 AND AS AMENDED.
8. ALL VEHICLES ARE TO BE HIGHLY VISIBLE USING ROTATING BEACONS AND BE MARKED BY USE OF TRAFFIC CONES.
9. NATIONAL GRID SHALL NOTIFY EACH ADJUTTER AT LEAST 48 HOURS IN ADVANCE OF THE START OF ANY WORK THAT WILL REQUIRE THE TEMPORARY OBSTRUCTION OF ACCESS.
10. BACKFILL MATERIAL WILL CONSIST OF SUITABLE EXCAVATED MATERIAL COMPACTED.
11. BLASTING NOT PERMITTED.

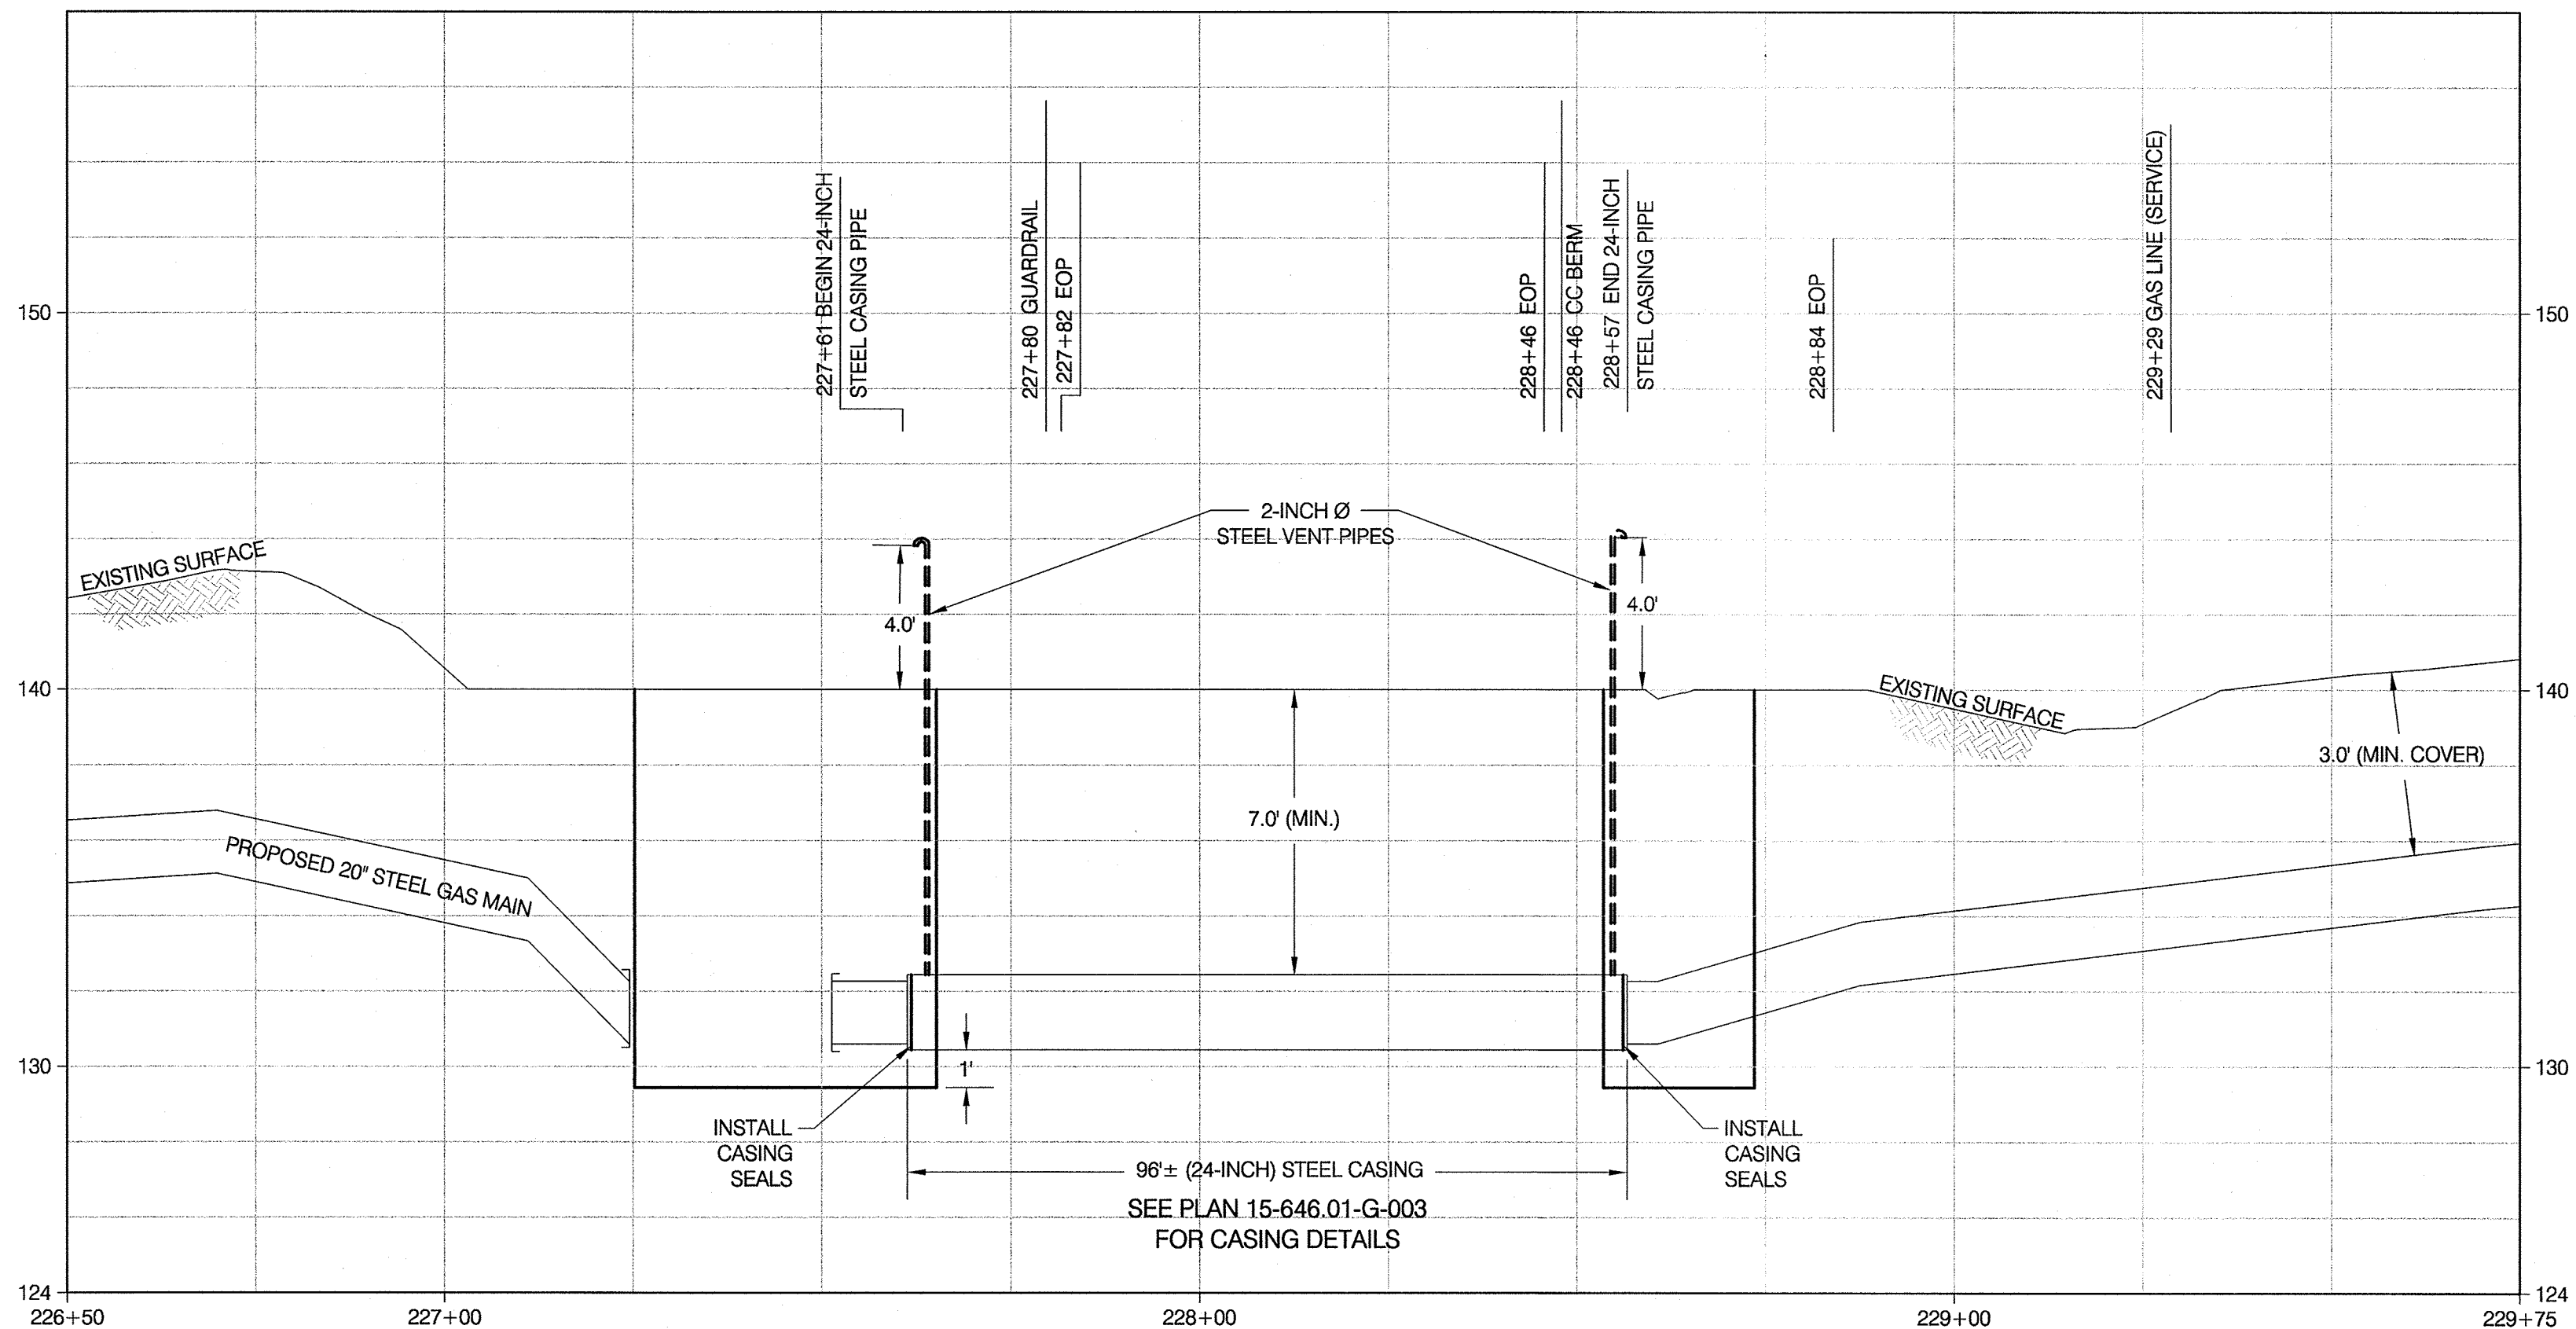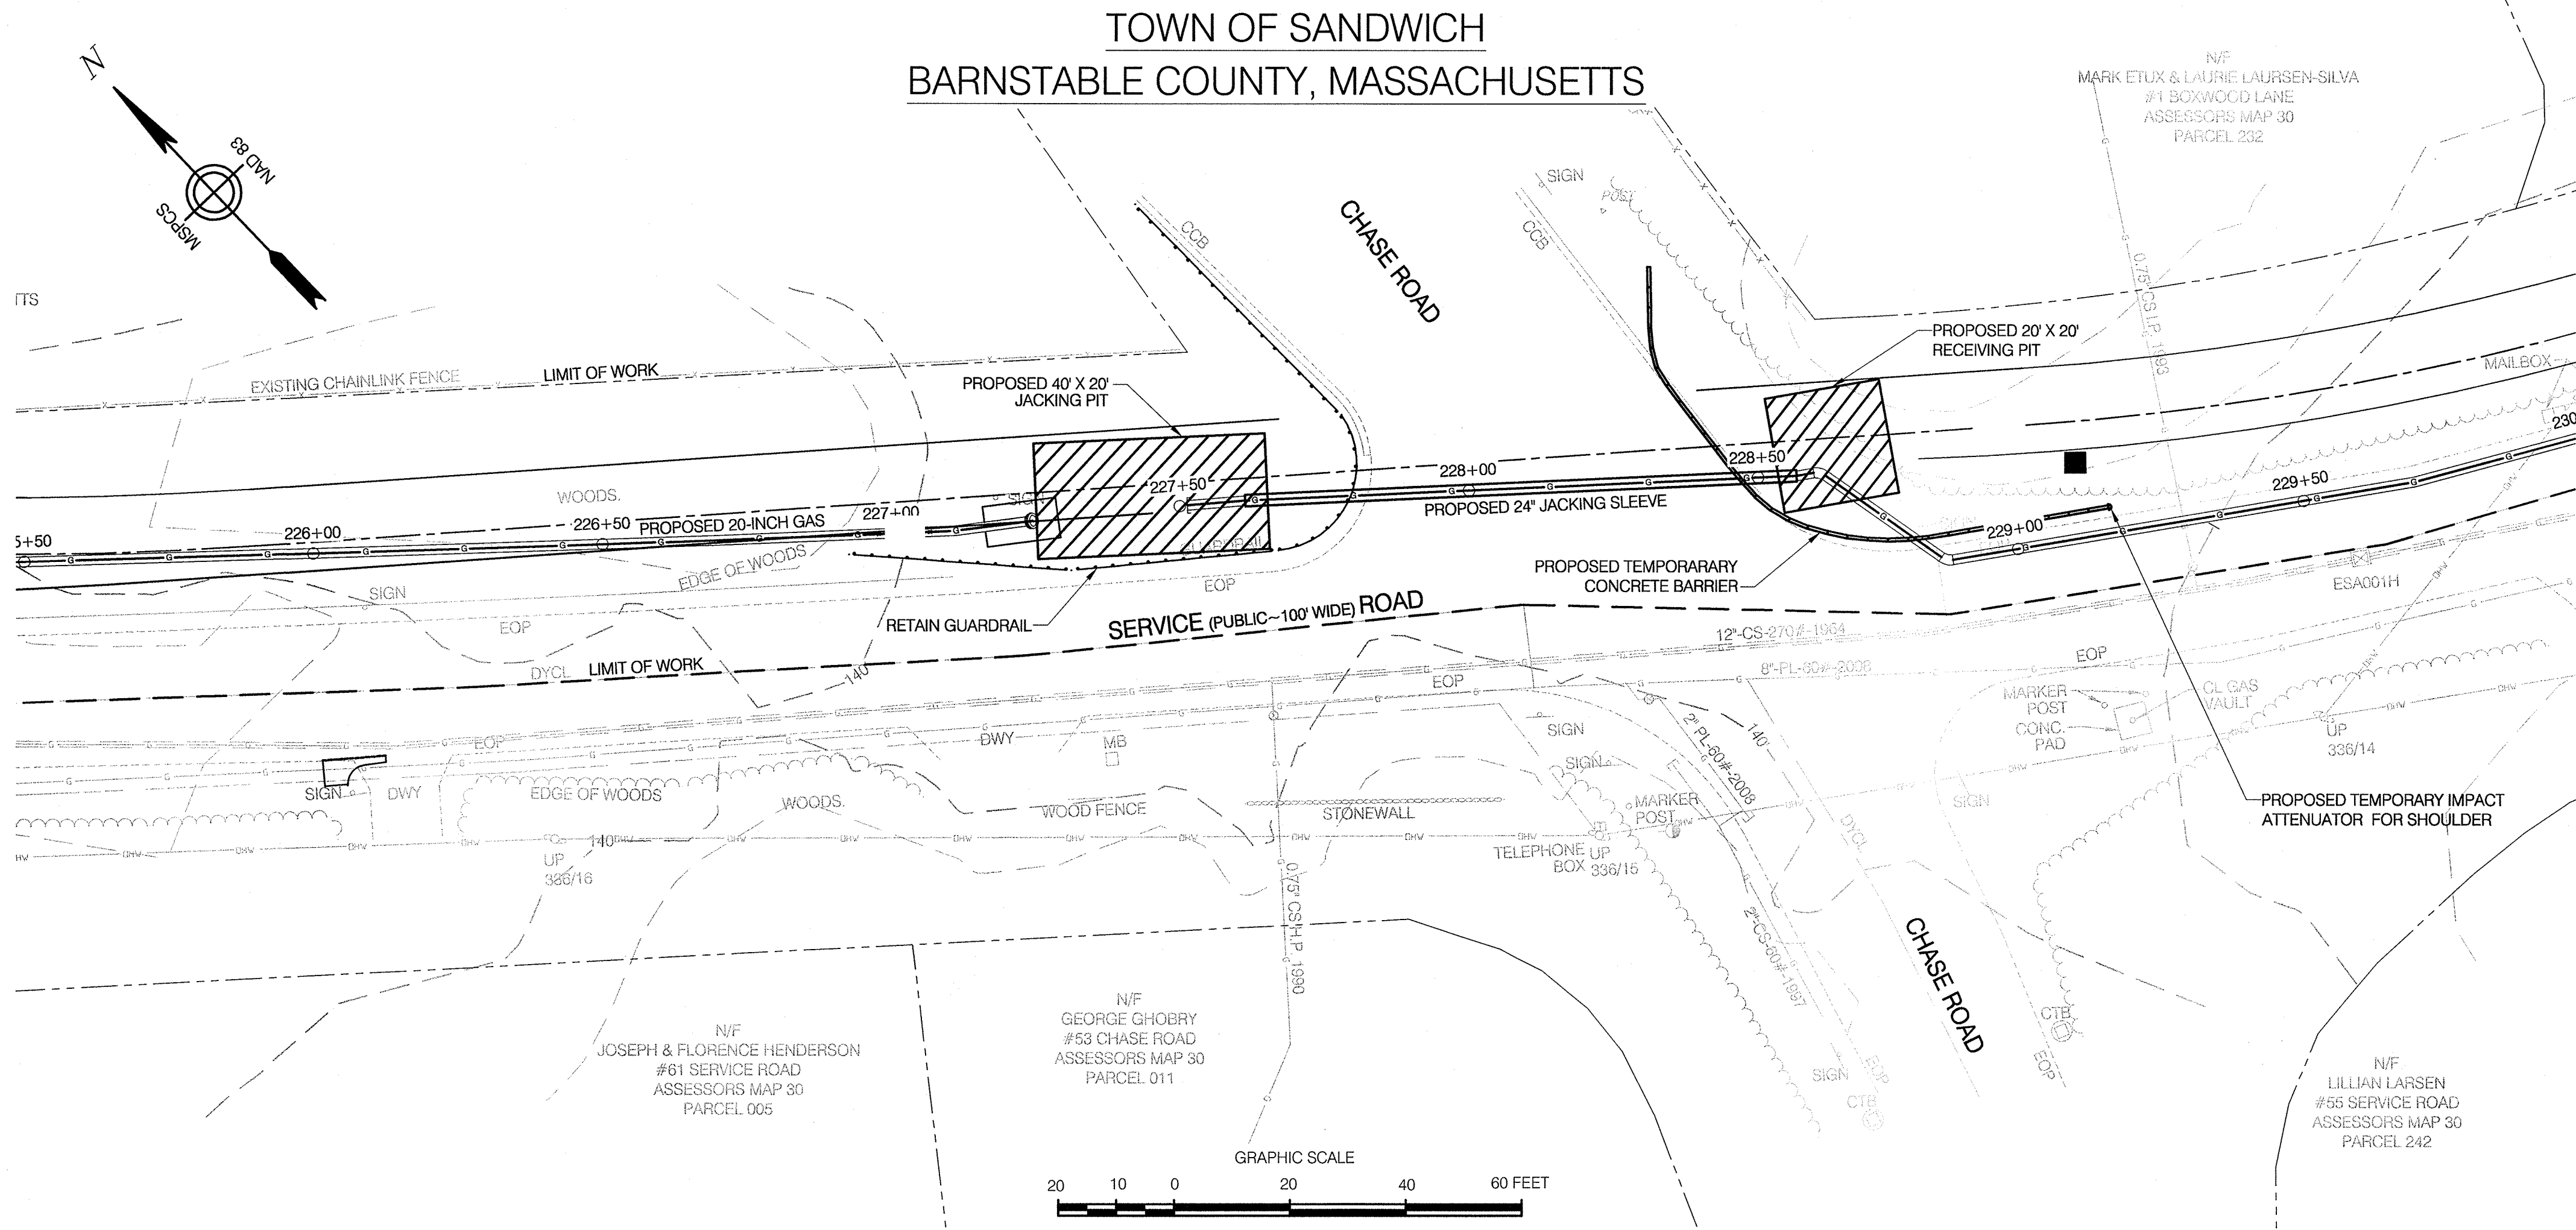

PROFILE
HOR. SCALE: 1"=20'
VER. SCALE: 1"=5'

REFERENCE DRAWINGS

DRAWING NO.	TITLE	DRAWING NO.	TITLE	NO.	DATE	REVISIONS	REV.	CKD.	COR.	APP.
				0	5/14	REVISED FOR FINAL EFSB APPROVAL	KDW	SAB	KDW	JEO


REVISIONS

Design/Engineering

Prepared For:



COLONIAL GAS COMPANY
d/b/a
nationalgrid
GAS ENGINEERING DEPARTMENT
40 SILVERDALE
WALTHAM, MA 02451

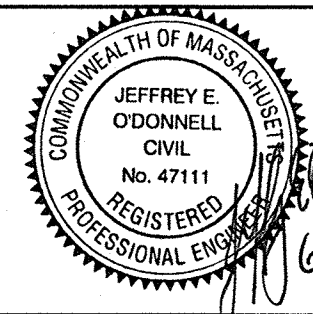

NATIONAL GRID
PROPOSED 20-INCH GAS MAIN
CHASE ROAD CROSSING DETAIL
SANDWICH, MASSACHUSETTS

File No.: 15-646.01 JACK & BORE DETAILS.dwg

APPROVED BY

DATE: SEPTEMBER 24, 2012

MANAGER

NATIONAL GRID SERVICE COMPANY, USA

15-646.01-C-038A